


FOUNDATION PLAN

SCALE 1/4" = 1'-0"

This plan is provided as a dimension control and plumbing drain penetration location. It is the General Contractor's responsibility to have this plan engineered by a Professional Engineer according to the soils report. Korel Home Designs assumes no liability.

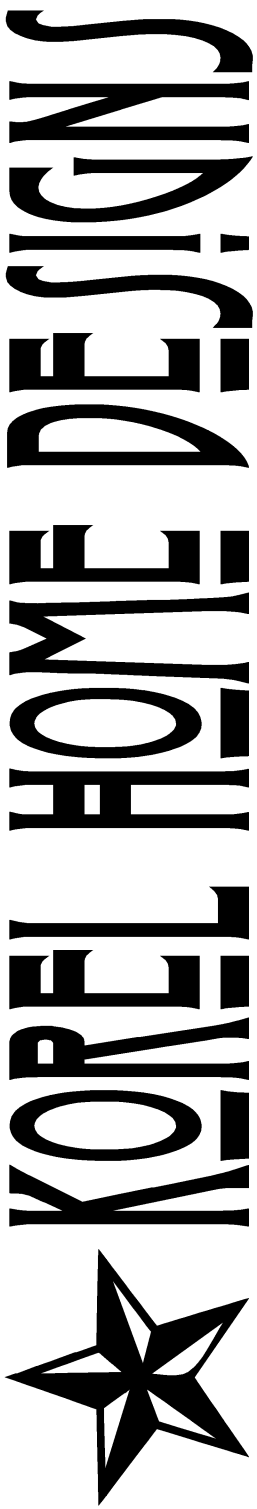

P.O. Box 866986, Plano, Texas 75086-6986 - 1.800.400.9220

Please Note: Prior to any construction or foundation, the general contractor must verify all dimensions and locations of all plumbing fixtures and zoning ordinances and all conditions. Any changes to the plan must be approved by the designer. The designer is not responsible for any action taken by the general contractor. Korel Home Designs assumes no liability for any structural engineering or foundation work. This plan is a license only to the owner. All rights reserved. Copyright (C) 2017.

copyright (c) 2017 Korel Home Designs

Design No.:

HILL

Sheet:

01

Builder's name

Owner's name