



PHOTO OR RENDERING

FOR ILLUSTRATION ONLY

Disclaimer: Measurements are approximate and are for illustrative purposes only. While we do not doubt the plans accuracy, we make no guarantee, warranty or representation as to the accuracy and completeness of the floor plan. You or your advisors should conduct a careful, independent investigation of the property to determine to your satisfaction as to the suitability of the property for your space requirements.

REVISION TABLE	
NUMBER	DESCRIPTION

COVER SHEET

DRAWING:  
DESIGNED BY: D HAYDEN  
DRAWN BY: D HAYDEN  
CHECKED BY:  
FILE NAME

DATE:  
7/23/2018

SCALE:

SHEET:  
P-1





**RENDERING**  
FOR ILLUSTRATION ONLY

REVISION TABLE	
NUMBER	DESCRIPTION

3D GARAGE SIDE

DRAWING:

DESIGNED BY: D HAYDEN

DRAWN BY: D HAYDEN

CHECKED BY:

FILE NAME

DATE:

7/23/2018

SCALE:

SHEET:

P-2





**RENDERING**  
FOR ILLUSTRATION ONLY

REVISION TABLE	
NUMBER	DESCRIPTION

--

3D MASTER BEDROOM  
CORNER

DRAWING:	DESIGNED BY: D HAYDEN
	DRAWN BY: D HAYDEN
	CHECKED BY:
	FILE NAME

DATE:  
7/23/2018

SCALE:

SHEET:  
P-3





**RENDERING**  
FOR ILLUSTRATION ONLY

REVISION TABLE	
NUMBER	DESCRIPTION

3D PATIO SIDE

DRAWING:	DESIGNED BY: D HAYDEN
	DRAWN BY: D HAYDEN
	CHECKED BY:
	FILE NAME

DATE:
7/23/2018

SCALE:

SHEET:
P-4

 




**RENDERING**  
FOR ILLUSTRATION ONLY

Disclaimer: Measurements are approximate and are for illustrative purposes only. While we do not doubt the plans accuracy, we make no guarantee, warranty or representation as to the accuracy and completeness of the floor plan. You or your advisors should conduct a careful, independent investigation of the property to determine to your satisfaction as to the suitability of the property for your space requirements.

REVISION TABLE	
NUMBER	DATE



**3D DOLL HOUSE VIEW,  
FLOOR PLAN**

DRAWING: DESIGNED BY: D HAYDEN  
DRAWN BY: D HAYDEN  
CHECKED BY: FILE NAME

DATE:  
7/23/2018

SCALE:

SHEET:

P-5





**RENDERING**  
FOR ILLUSTRATION ONLY

Disclaimer: Measurements are approximate and are for illustrative purposes only. While we do not doubt the plans accuracy, we make no guarantee, warranty or representation as to the accuracy and completeness of the floor plan. You or your advisors should conduct a careful, independent investigation of the property to determine to your satisfaction as to the suitability of the property for your space requirements.

REVISION TABLE	
NUMBER	DESCRIPTION



3D LIVING ROOM

DRAWING: DESIGNED BY: D HAYDEN  
DRAWN BY: D HAYDEN  
CHECKED BY: FILE NAME

DATE:  
7/23/2018

SCALE:



SHEET:

P-6



**RENDERING**  
FOR ILLUSTRATION ONLY

REVISION TABLE	
NUMBER	DESCRIPTION

3D KITCHEN

DRAWING:

DESIGNED BY: D HAYDEN

DRAWN BY: D HAYDEN

CHECKED BY:

FILE NAME

DATE:

7/23/2018

SCALE:

SHEET:

P-7





**RENDERING**  
FOR ILLUSTRATION ONLY

REVISION TABLE	
NUMBER	DESCRIPTION

3D MASTER BEDROOM

DRAWING:	DESIGNED BY: D HAYDEN
	DRAWN BY: D HAYDEN
	CHECKED BY:
	FILE NAME

DATE:
7/23/2018

SCALE:

SHEET:
P-8





**RENDERING**  
FOR ILLUSTRATION ONLY

Disclaimer: Measurements are approximate and are for illustrative purposes only. While we do not doubt the plans accuracy, we make no guarantee, warranty or representation as to the accuracy and completeness of the floor plan. You or your advisors should conduct a careful, independent investigation of the property to determine to your satisfaction as to the suitability of the property for your space requirements.

REVISION TABLE	
NUMBER	DESCRIPTION

Guest Bedroom

DRAWING: DESIGNED BY: D HAYDEN  
DRAWN BY: D HAYDEN  
CHECKED BY: FILE NAME



DATE:  
7/23/2018

SCALE:

SHEET:  
P-9

1461 BATTLEGROUND DRIVE  
MURFREESBORO, TN 37129  
(615) 269-3906



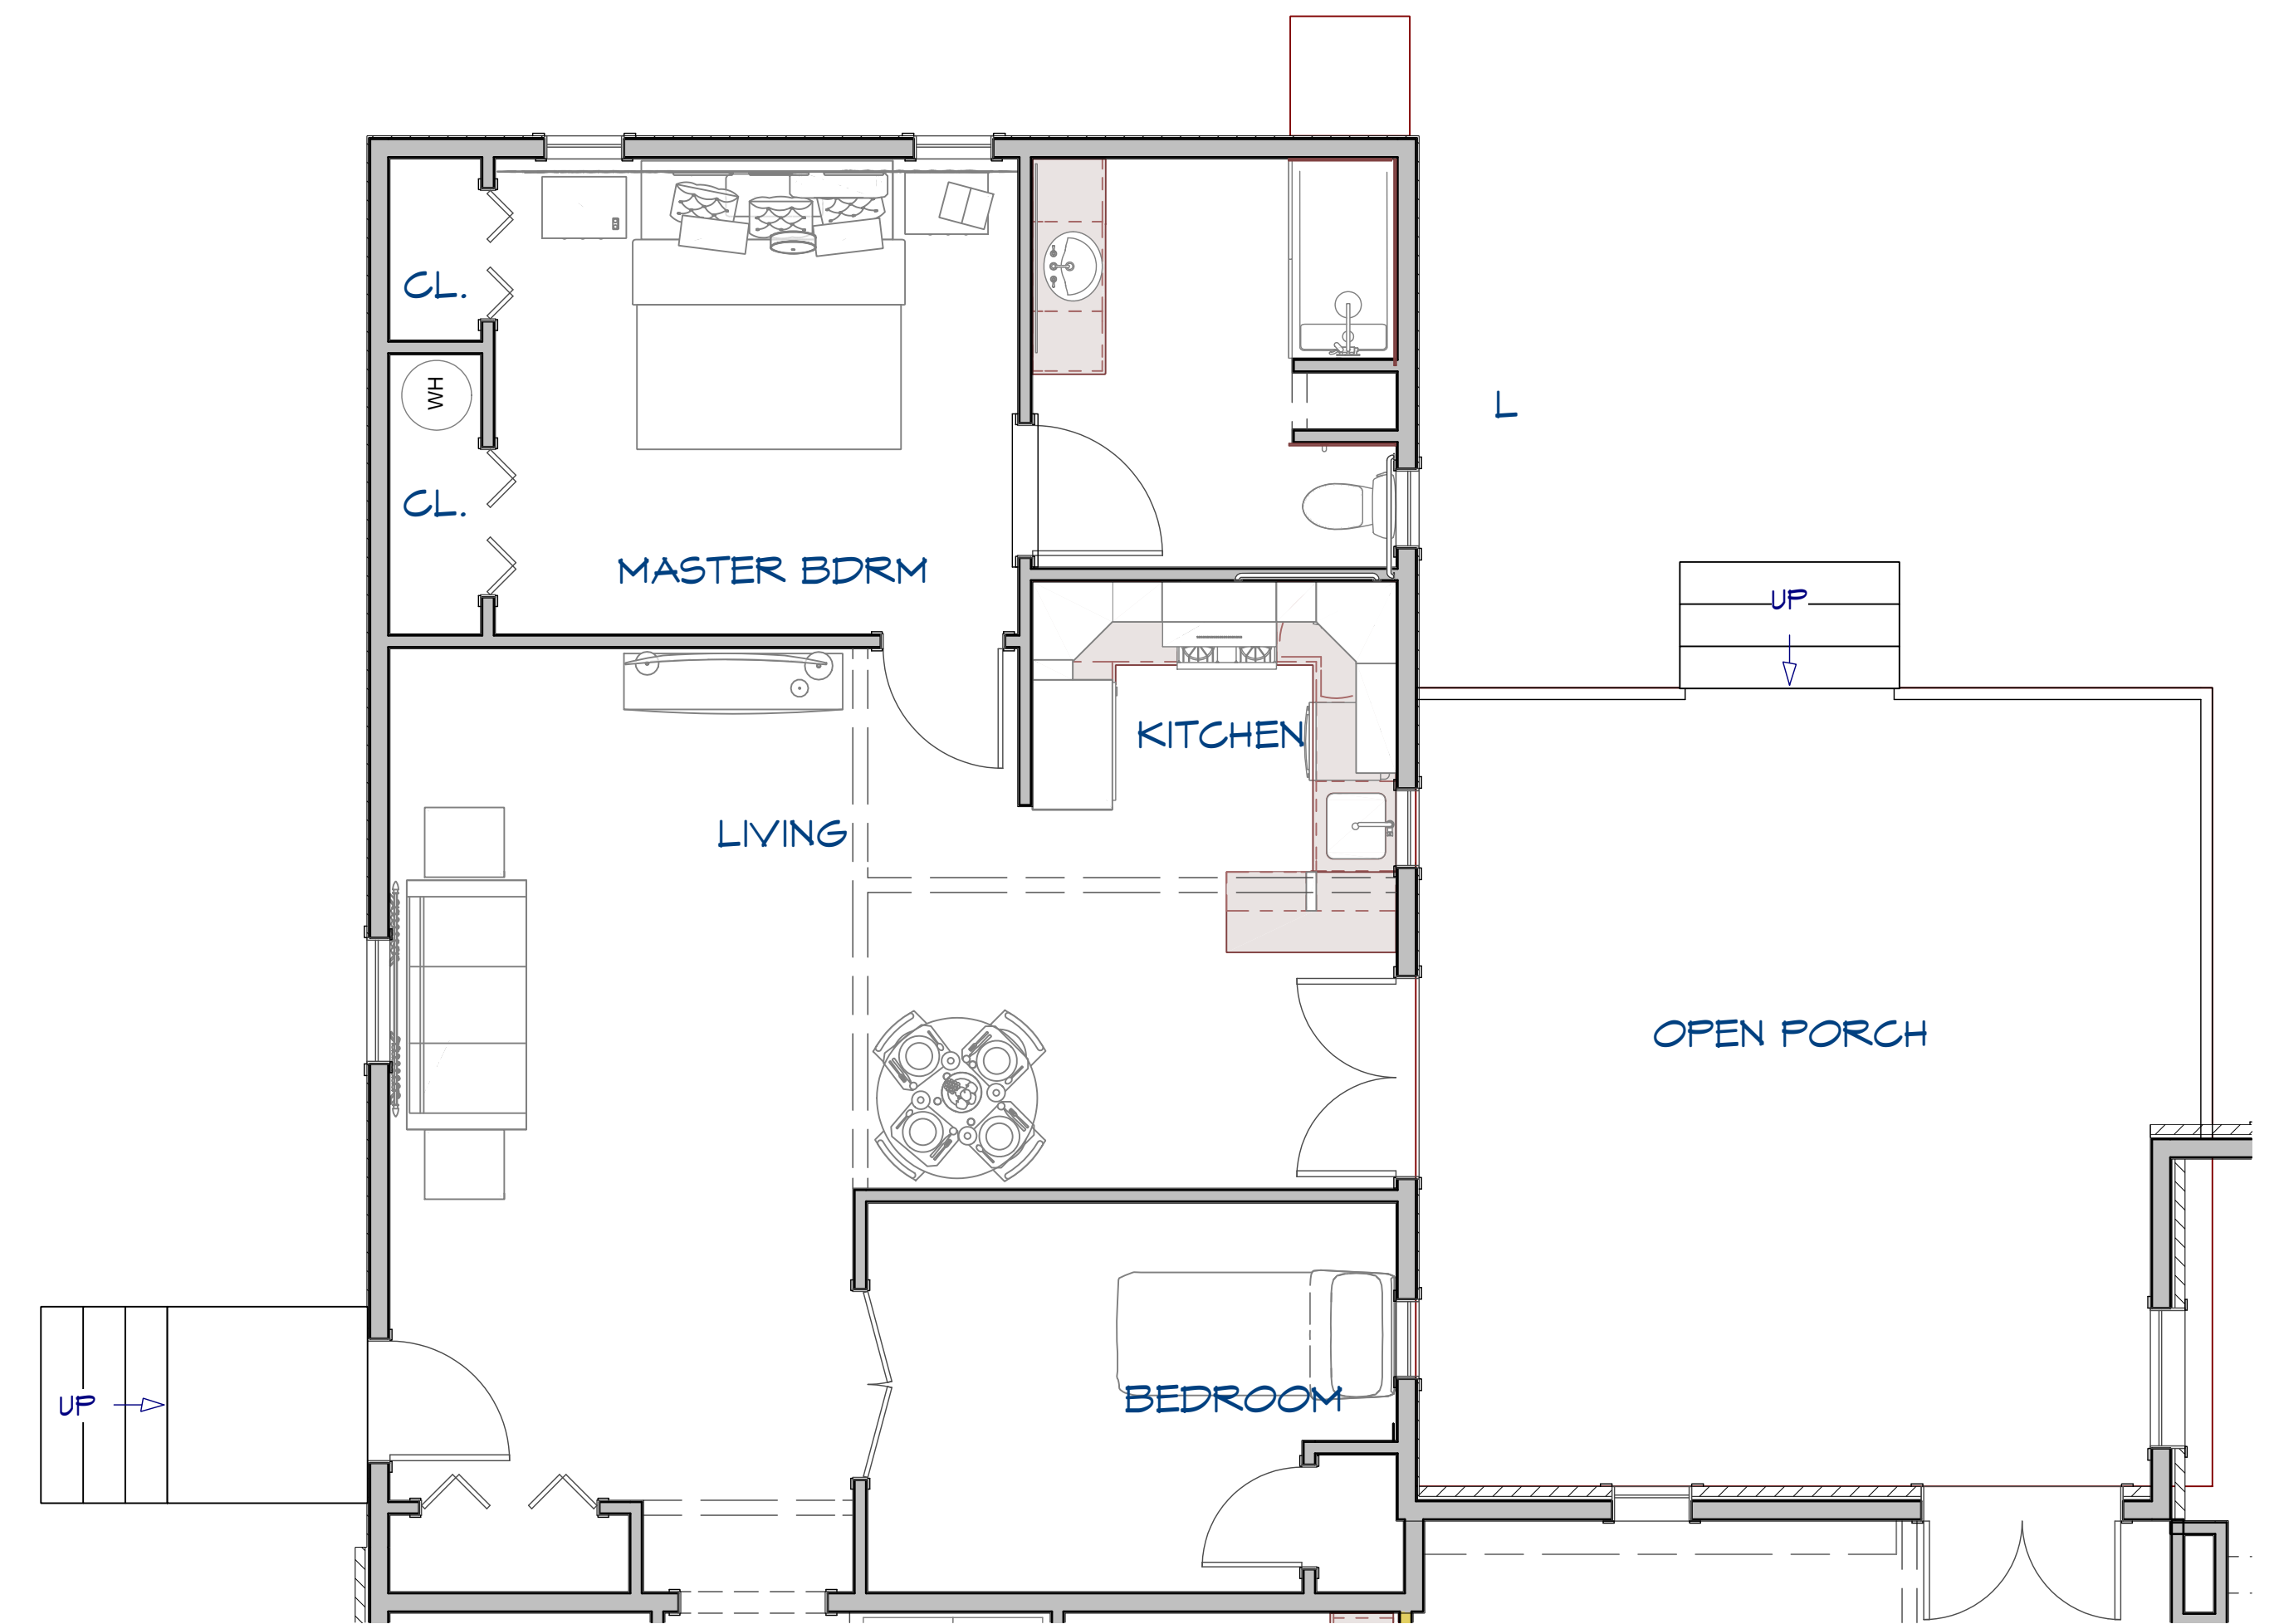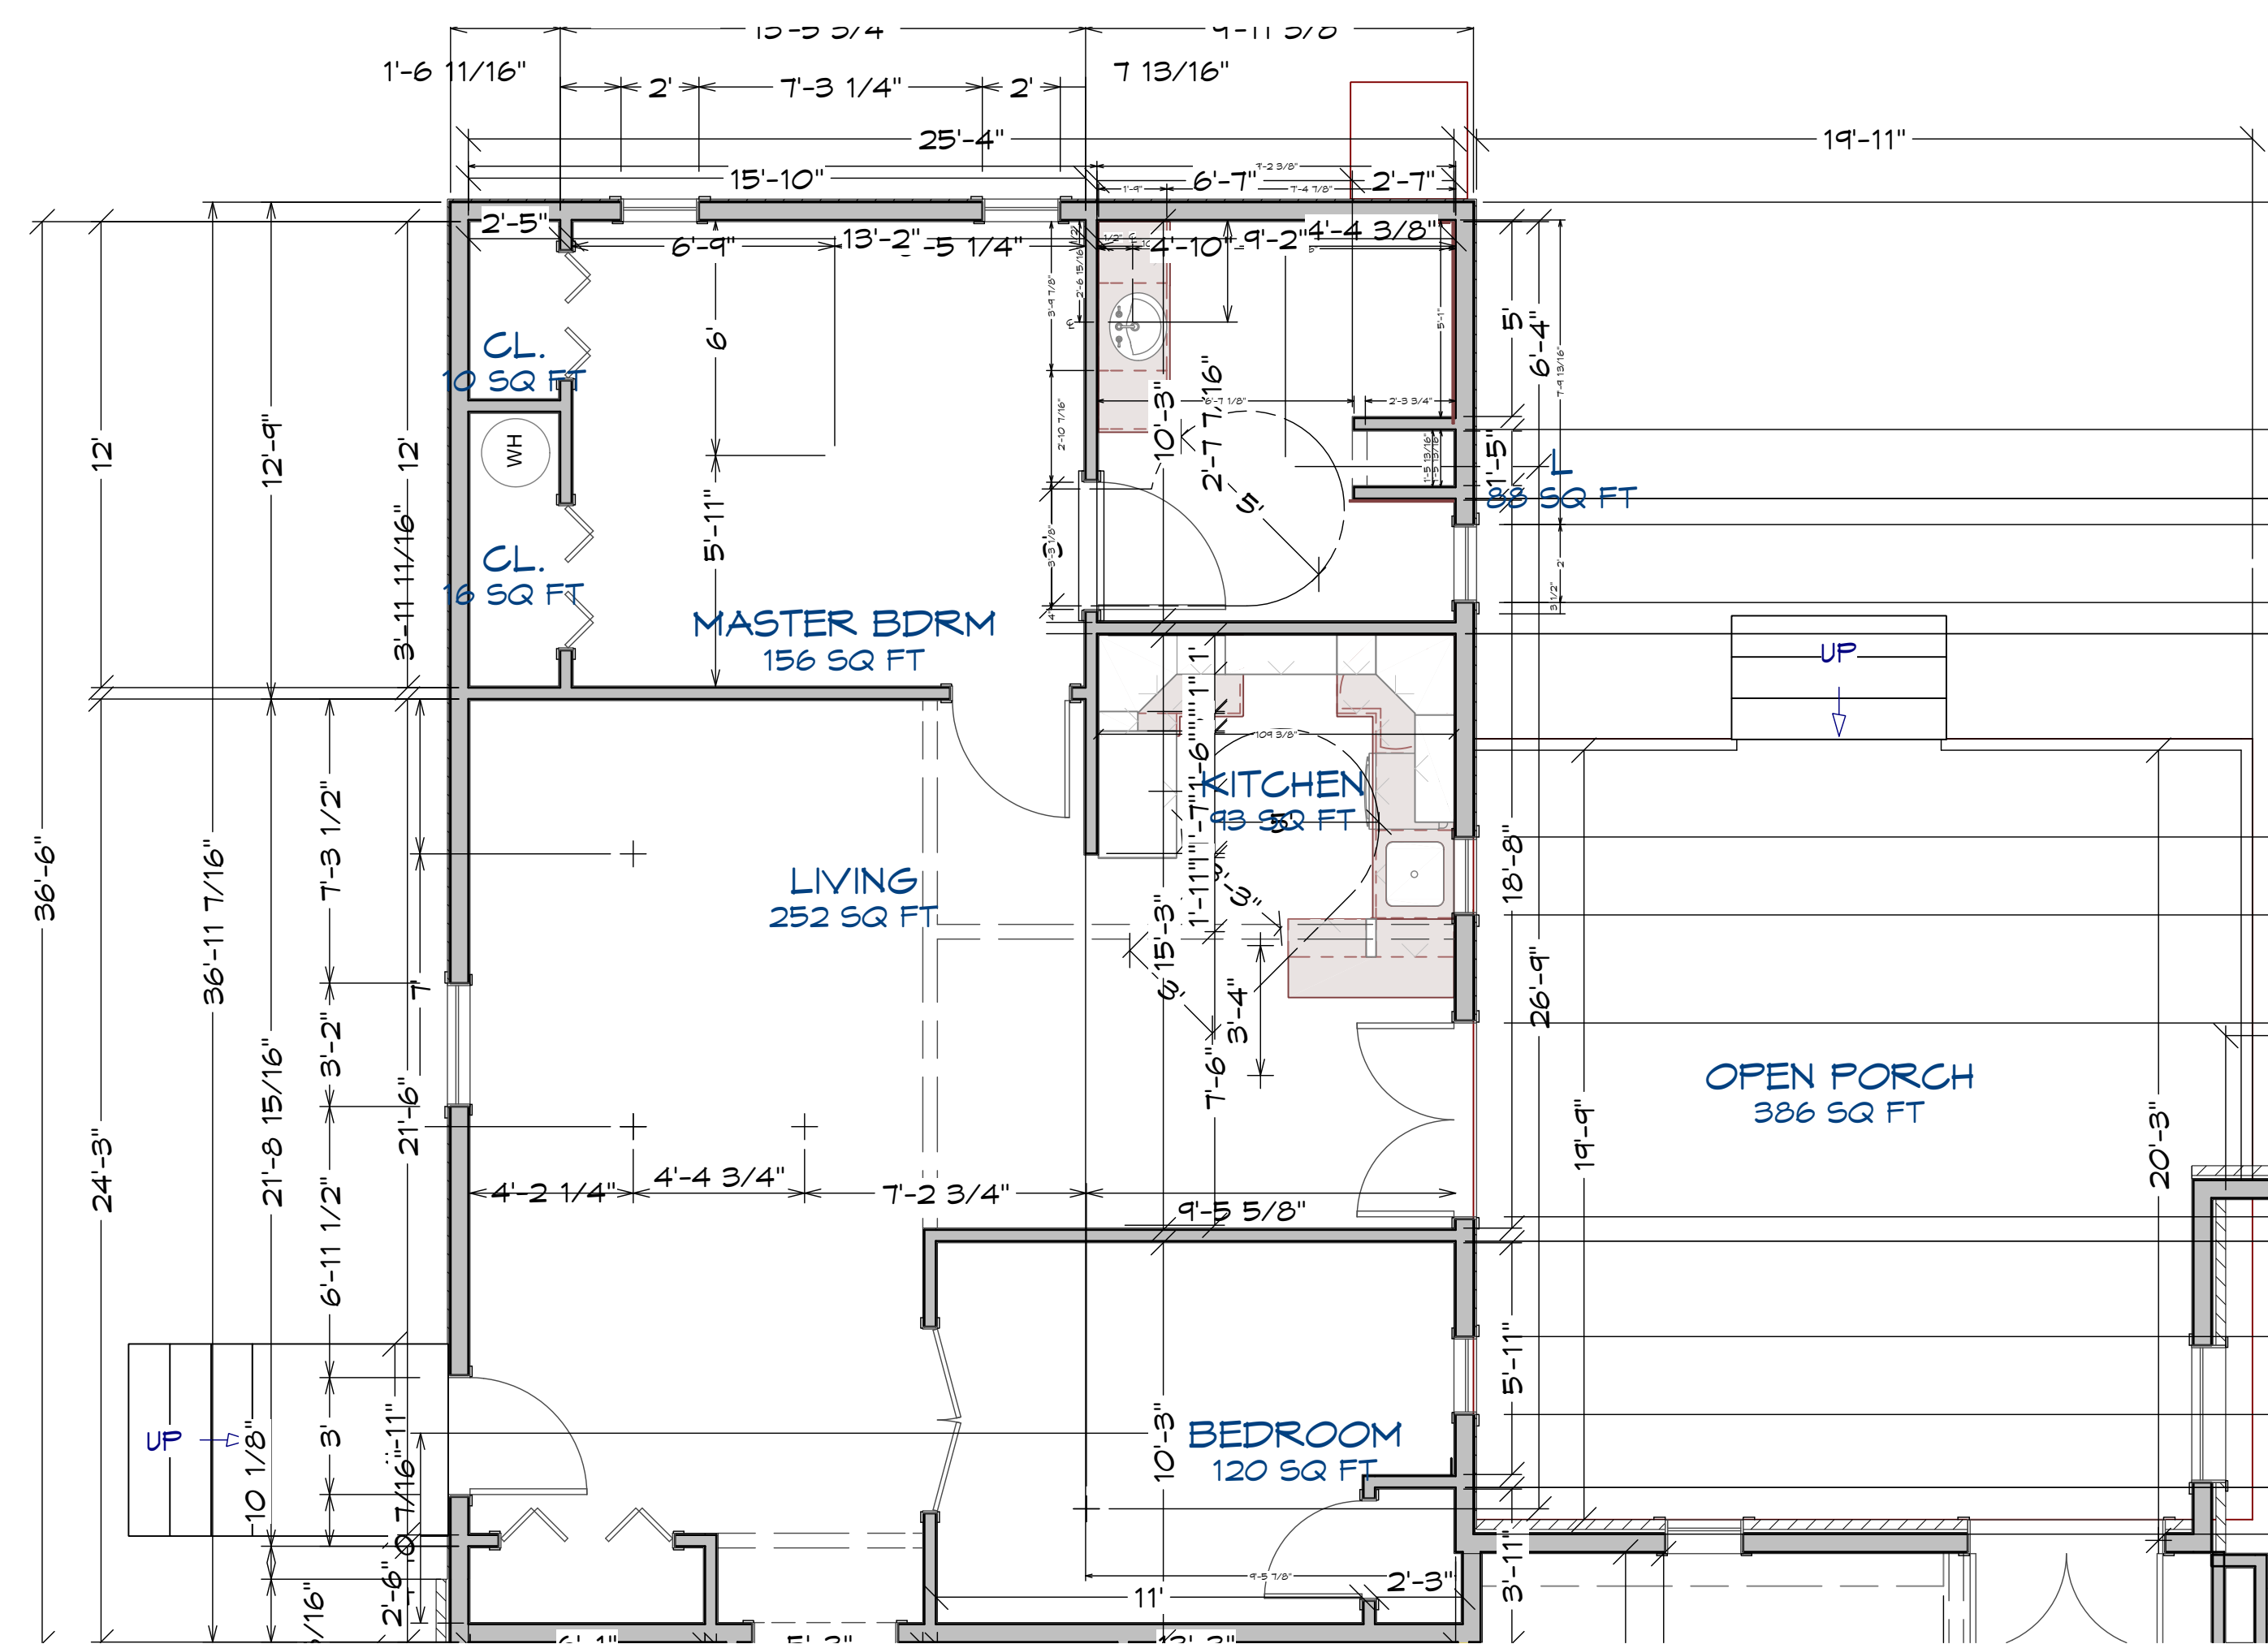

NUMBER	DATE	REVISED BY	DESCRIPTION

# 1st FLOOR PLAN

DESIGNED BY:	D HAYDEN
DRAWN BY:	D HAYDEN
CHECKED BY:	
FILE NAME	

DATE:
7/23/2018

SCALE:


SHEET:

P-10

Disclaimer: Measurements are approximate and are for illustrative purposes only. While we do not doubt the plans accuracy, we make no guarantee, warranty or representation as to the accuracy and completeness of the floor plan. You or your advisors should conduct a careful, independent investigation of the property to determine to your satisfaction as to the suitability of the property for your space requirements.


1 BATTLEGROUND DRIVE  
FRESBORO, TN 37129  
15) 269-3906



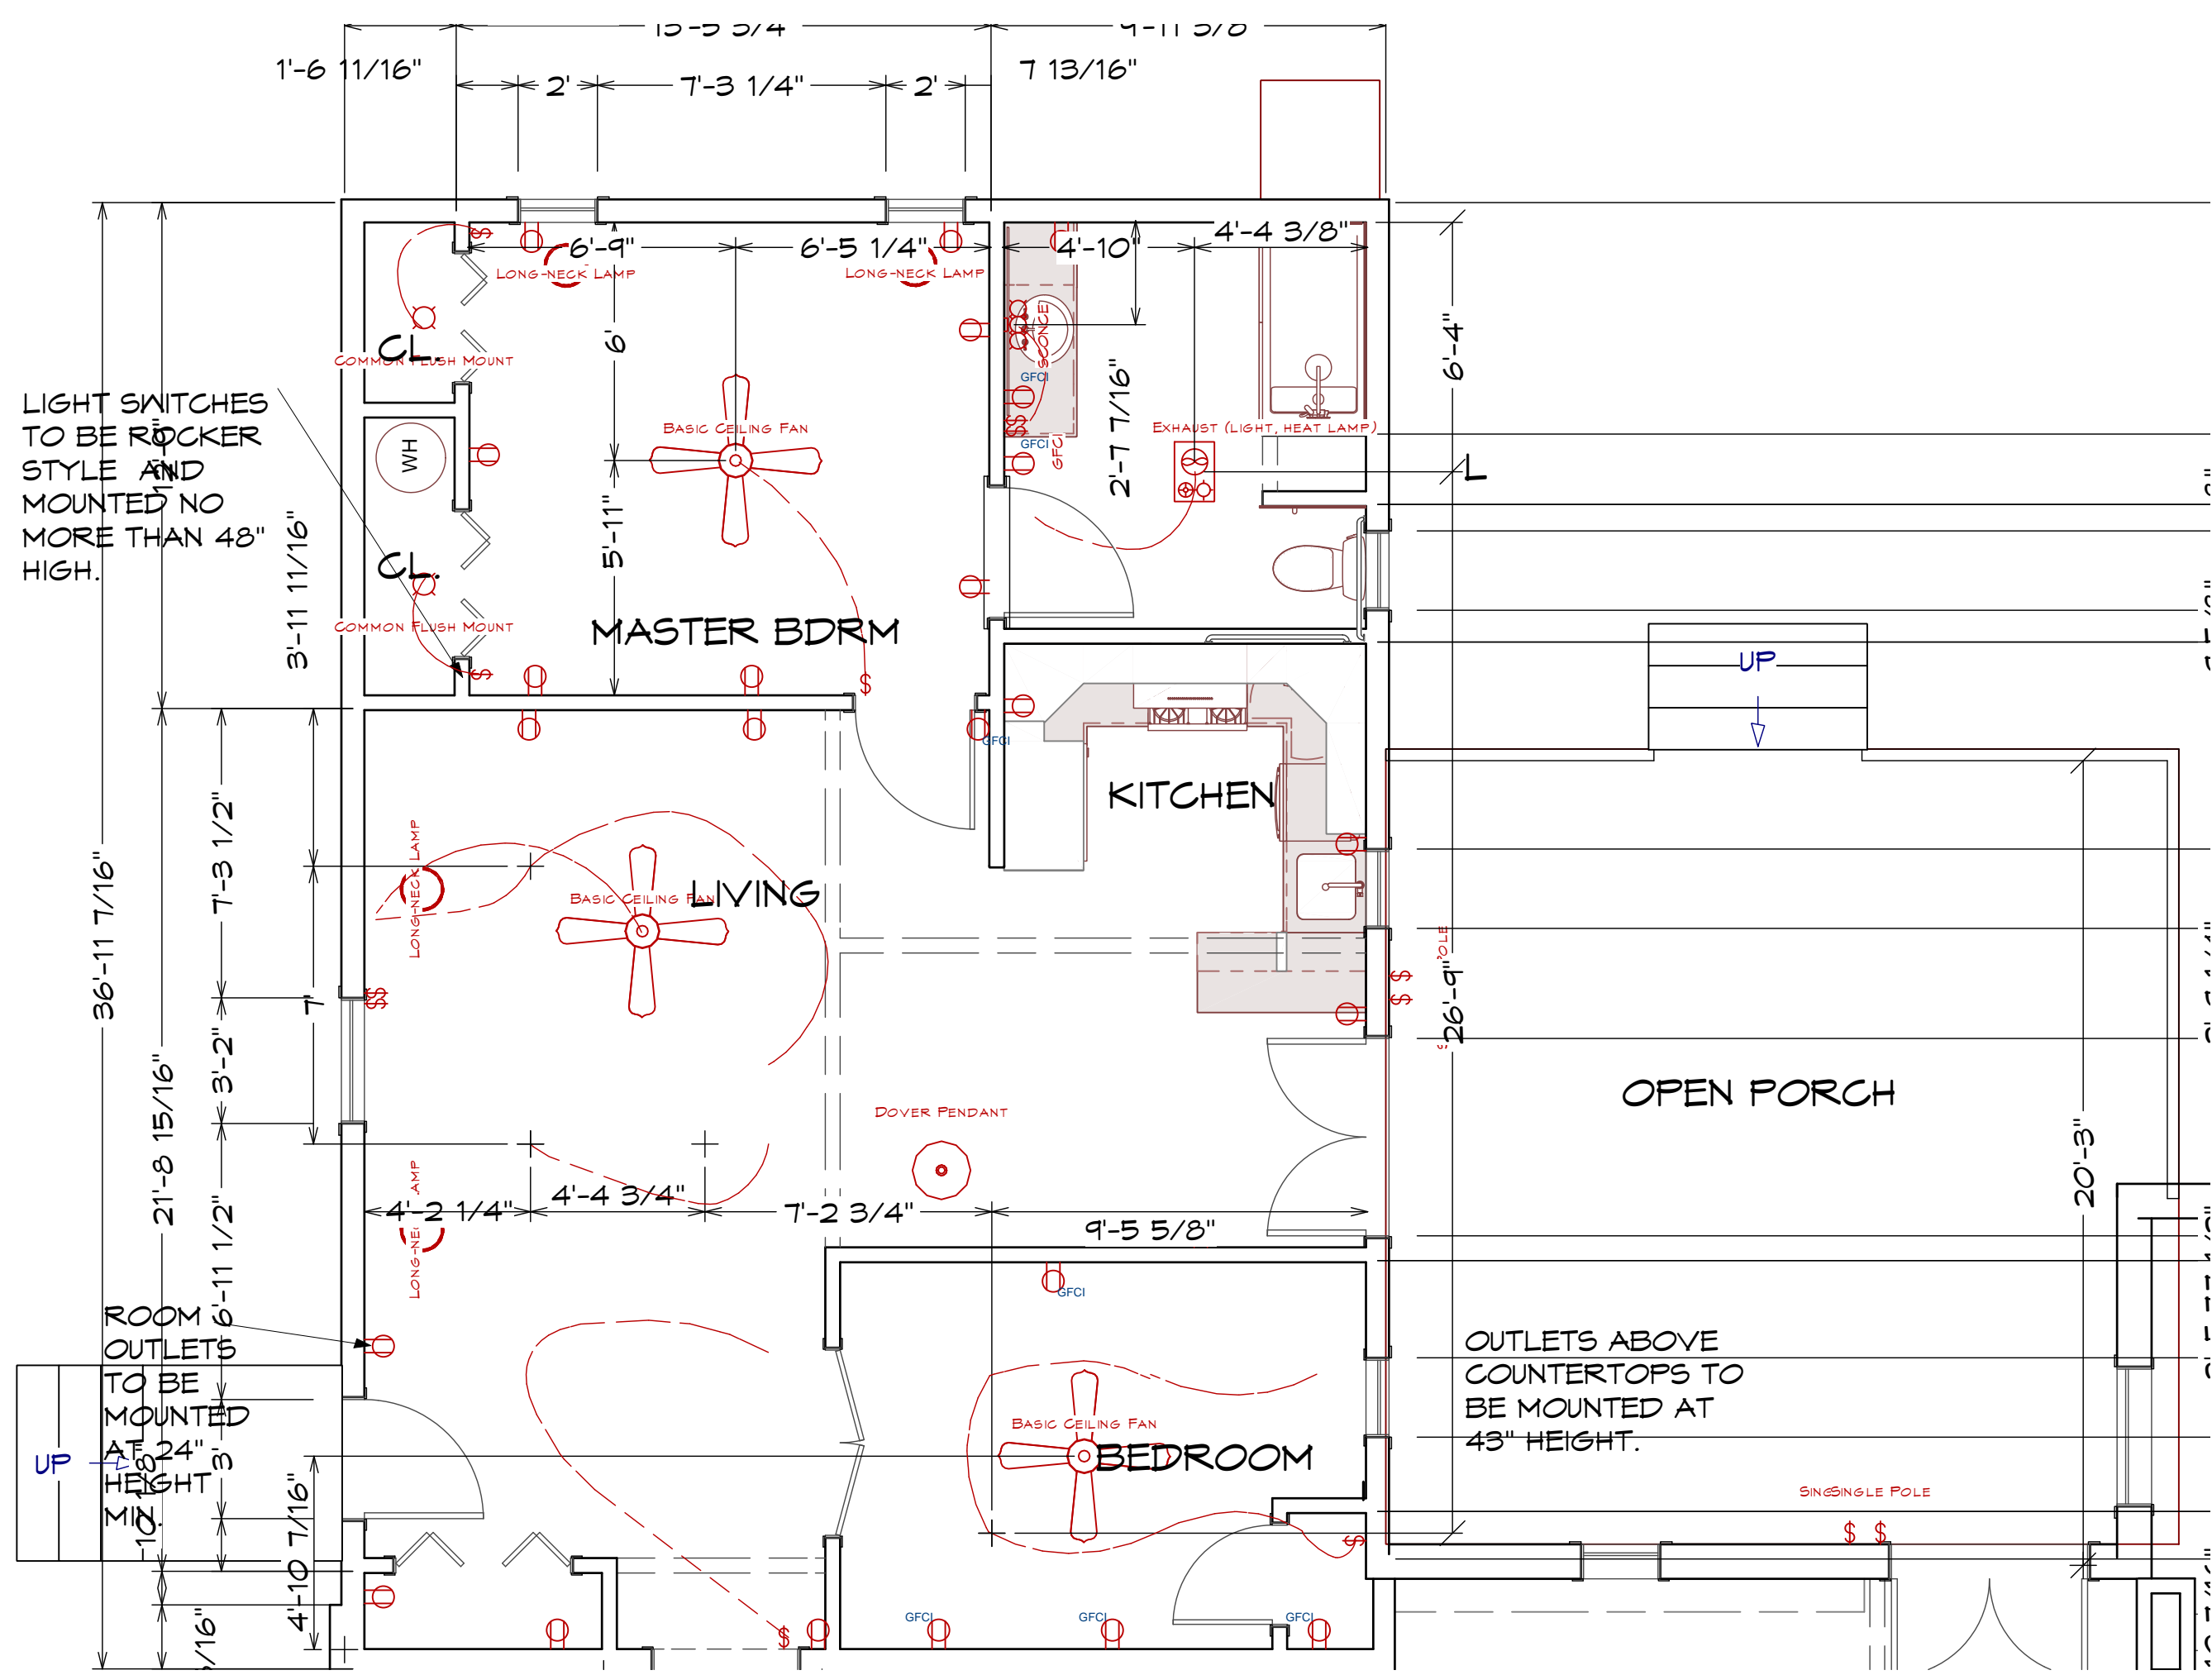

ELECTRICAL PLAN

1/4"=1'

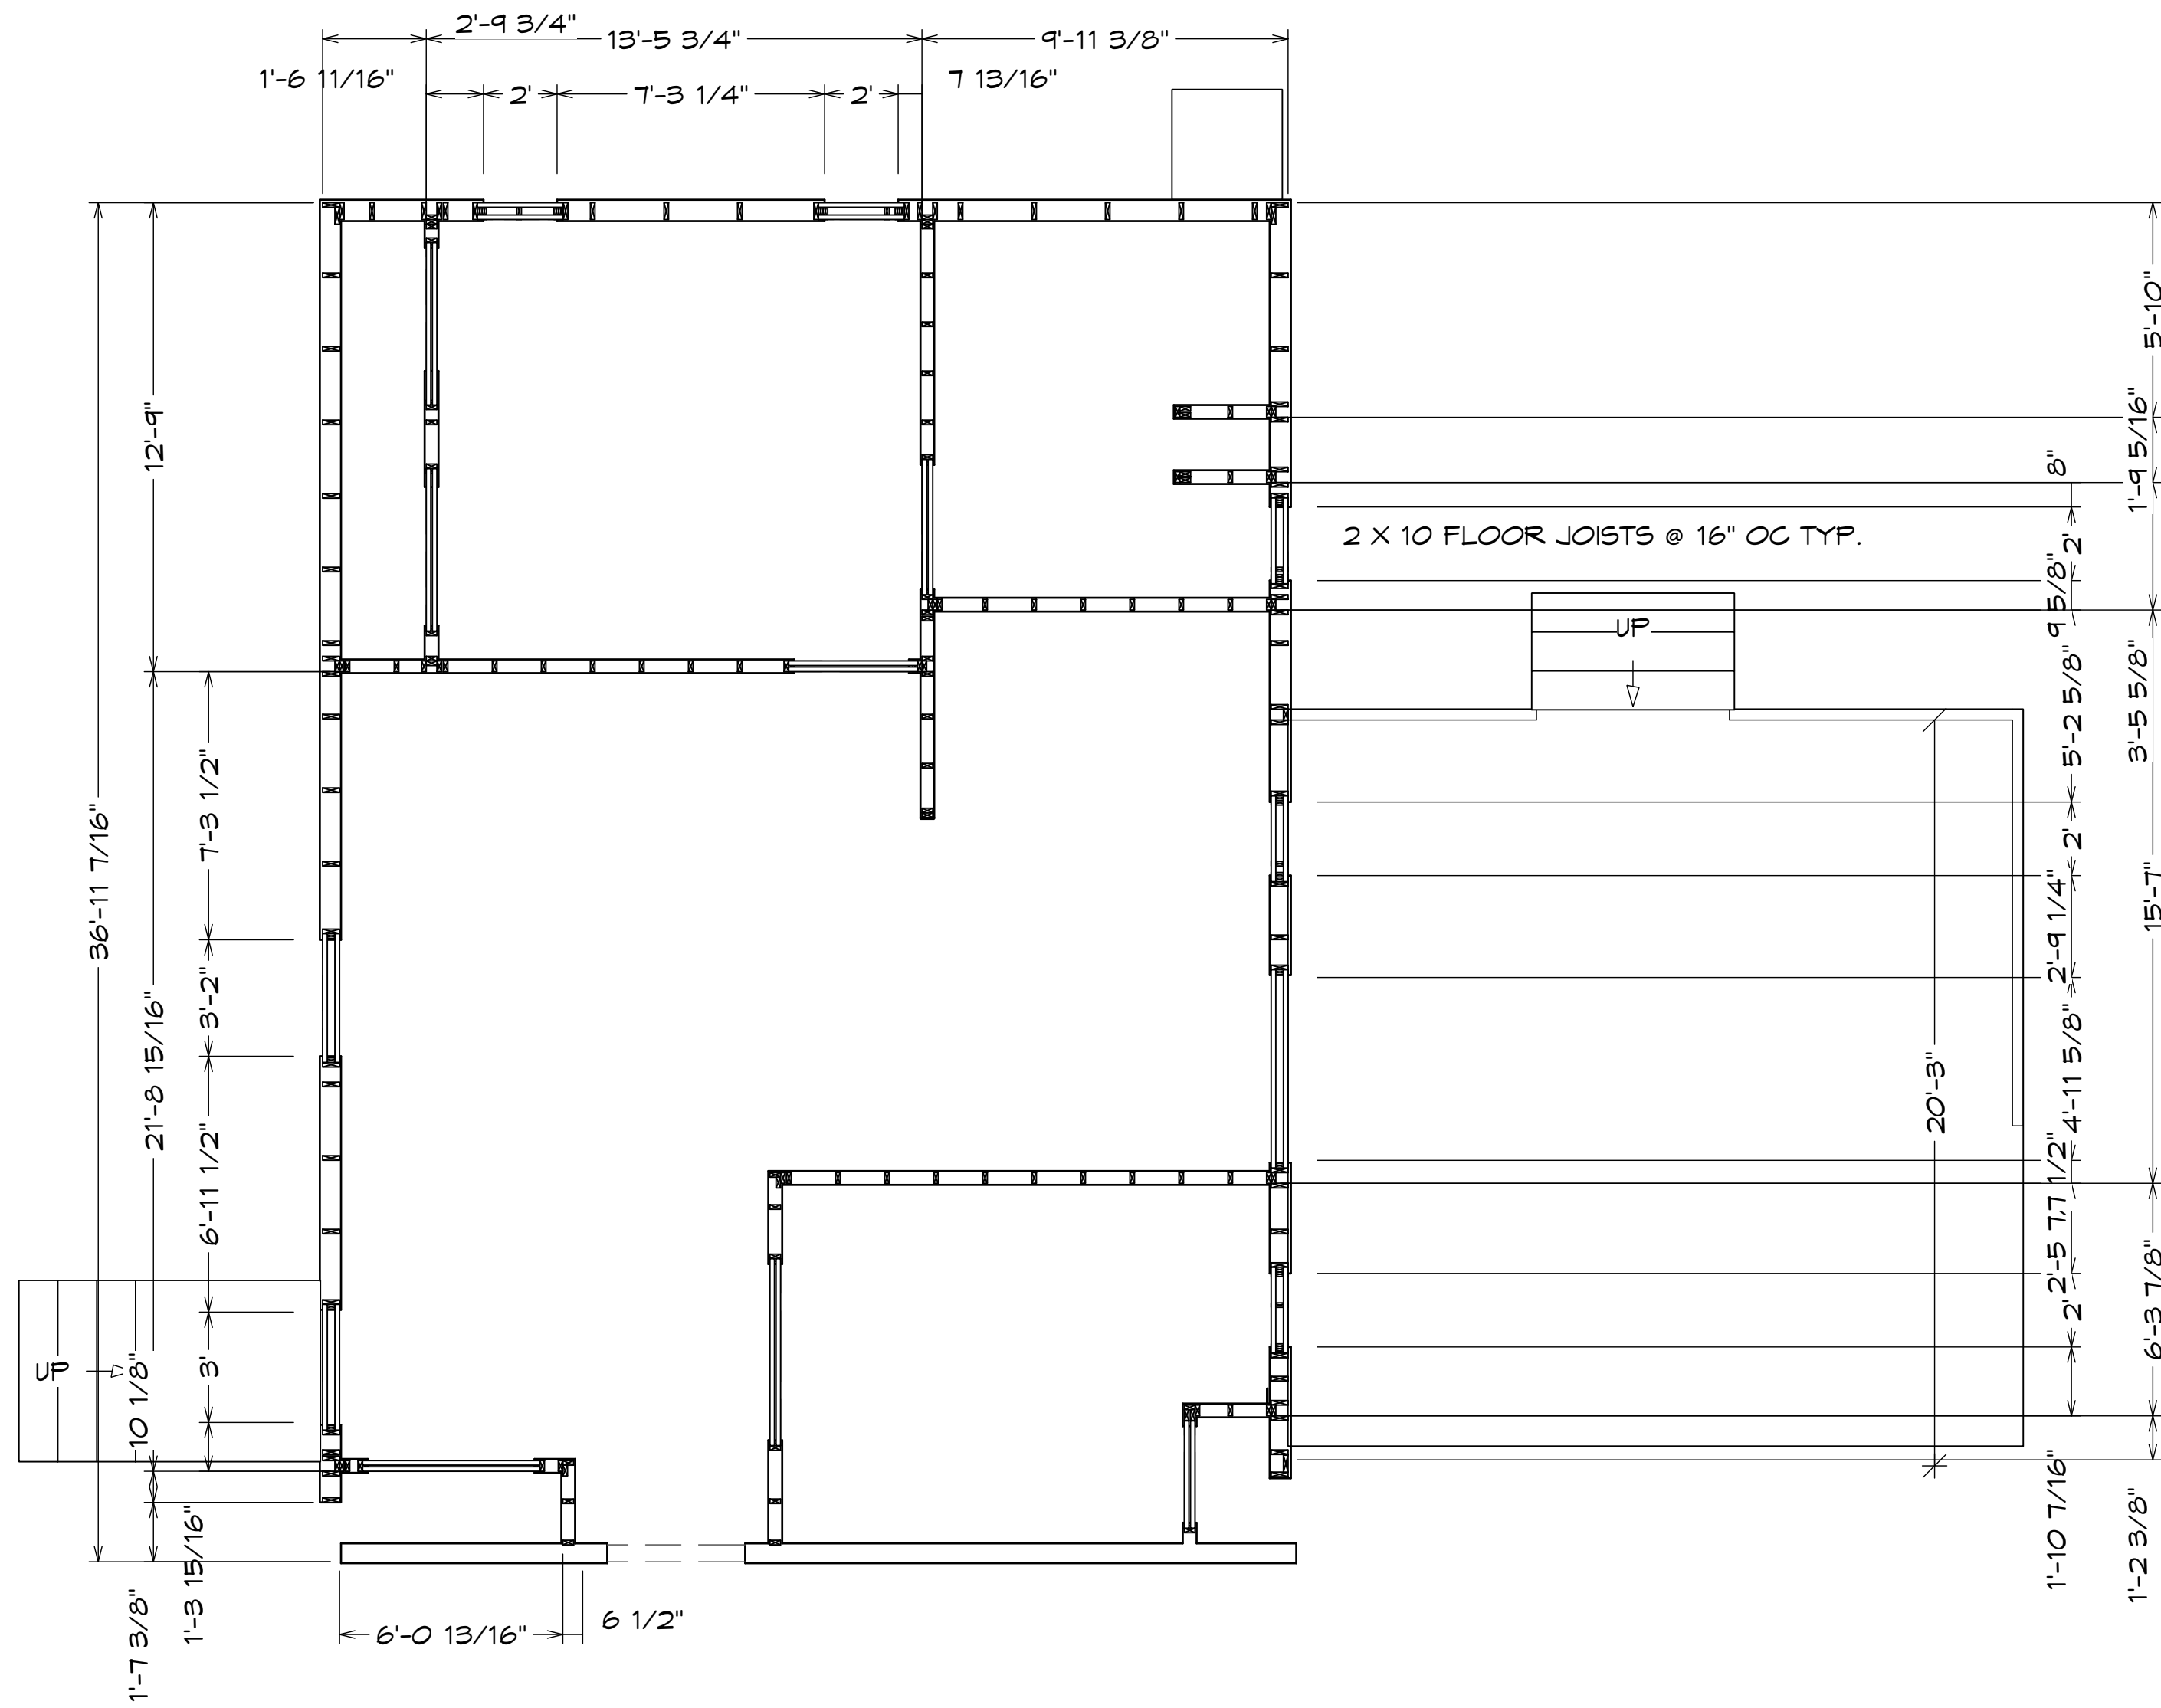

REVISION TABLE	
NUMBER	DATE

DRAWING:  
DESIGNED BY: D HAYDEN  
DRAWN BY: D HAYDEN  
CHECKED BY:  
FILE NAME

DATE:  
7/23/2018

SCALE:

SHEET:  
P-11




KITCHEN & CABINET NOTES

1. ALL CABINETS FRAMELESS, MAPLE OR ALDER
2. CONFIRM FINISH & STAIN/ PAINT WITH CLIENT PRIOR TO ORDERING
3. CONFIRM DOOR & DRAWER STYLES WITH CLIENT PRIOR TO ORDERING
4. INSTALL HARDWARE ON SITE
5. INSTALL CROWN MOLDING ON SITE; CONFIRM PROFILE AND DIMENSION WITH HOME OWNER
6. CABINET SUPPLIER RESPONSIBLE FOR FINAL MEASUREMENTS & CABINET OPENINGS FOR APPLIANCES SPECIFICATIONS
7. ALL APPLIANCES TO BE ON DEDICATED CIRCUITS, UNO. REFER TO APPLIANCE SPECIFICATIONS FOR AMP/ VOLTAGE REQUIREMENTS
8. USE MIN 6" DUCT FOR HOOD. CONFIRM HOOD IS 500 CFM MIN.
9. CONFIRM FINAL MATERIALS FOR BACKSPLASH AND COUNTERTOP WITH CLIENT PRIOR TO ORDERING
10. ALL DRAWERS TO BE TONGUE & GROOVE; GLIDES TO BE SOFT CLOSE
11. LED STRIP LIGHTS FOR WALL CABINETS AND UNDER ISLAND COUNTER FABRICATION: CONFIRM ALL FIXTURE MEASUREMENTS AND CENTERLINES




KITCHEN RENDERING

FOR ILLUSTRATION ONLY - NO SCALE

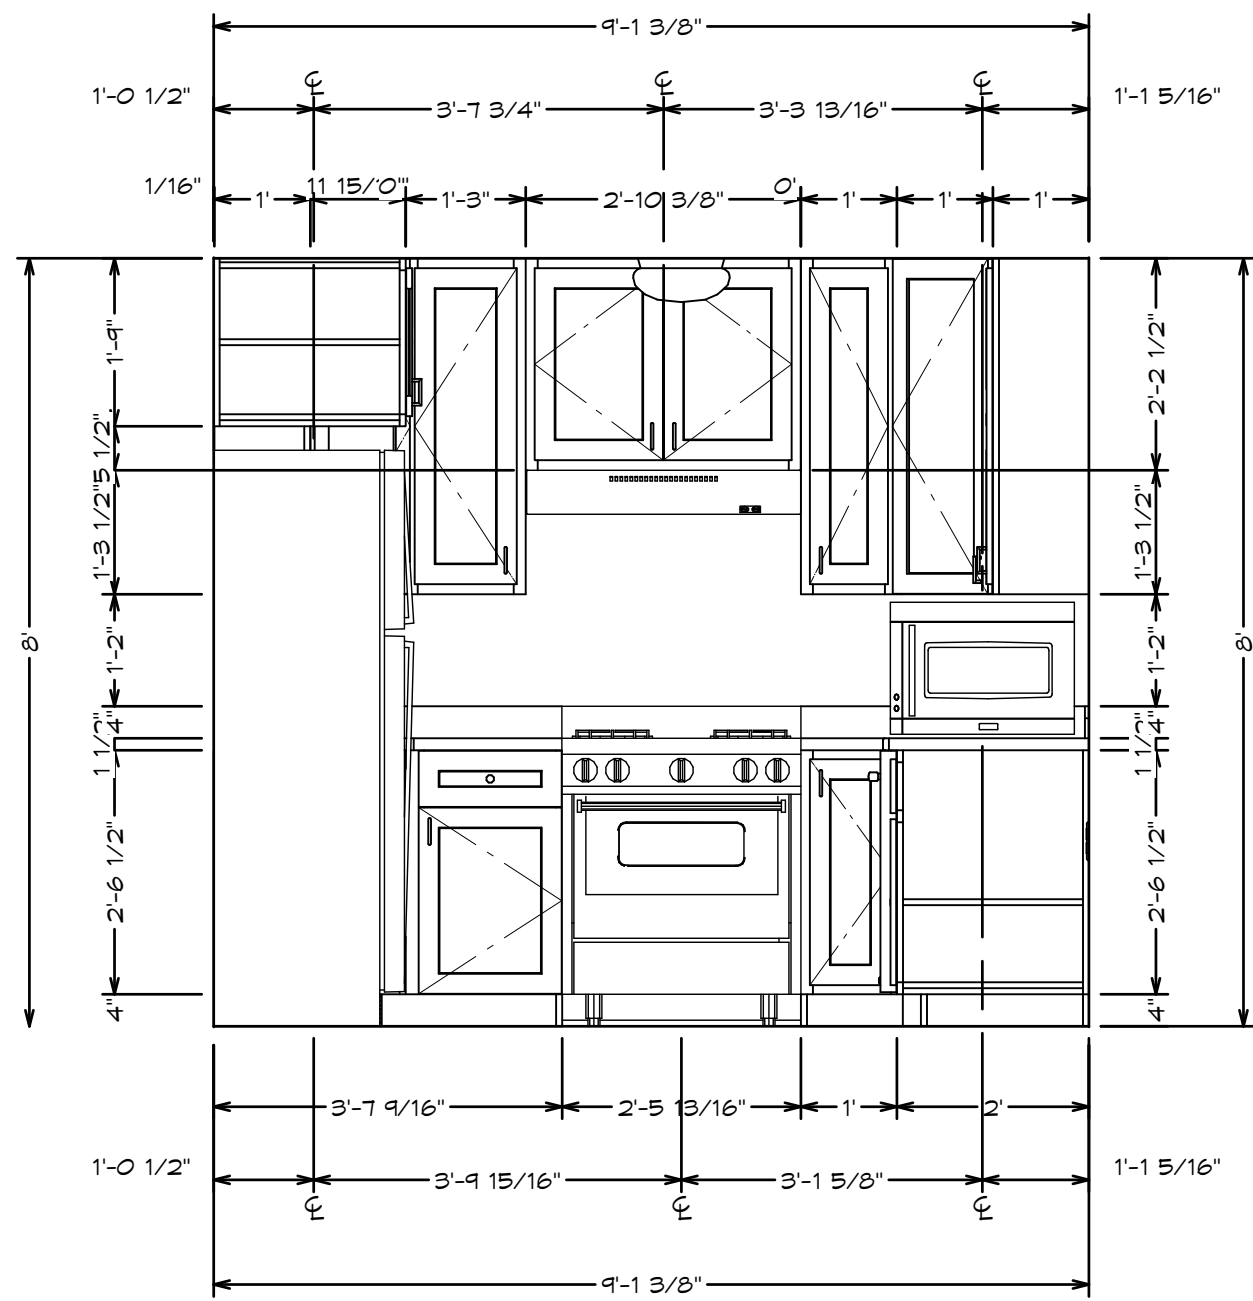


RANGE ELEVATION

1/2"=1'

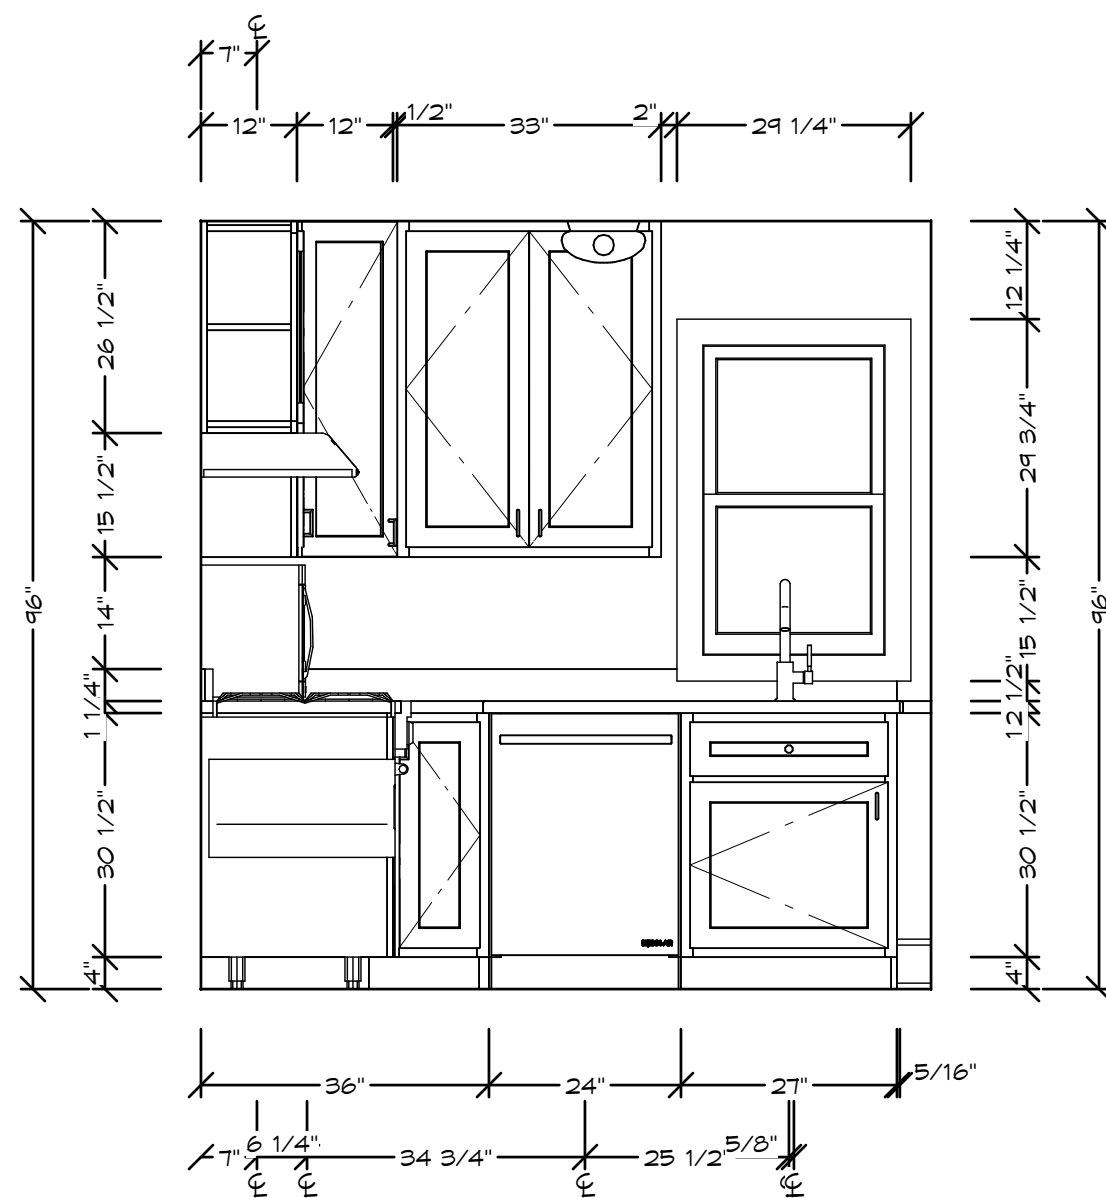


SINK ELEVATION

1/2"=1'

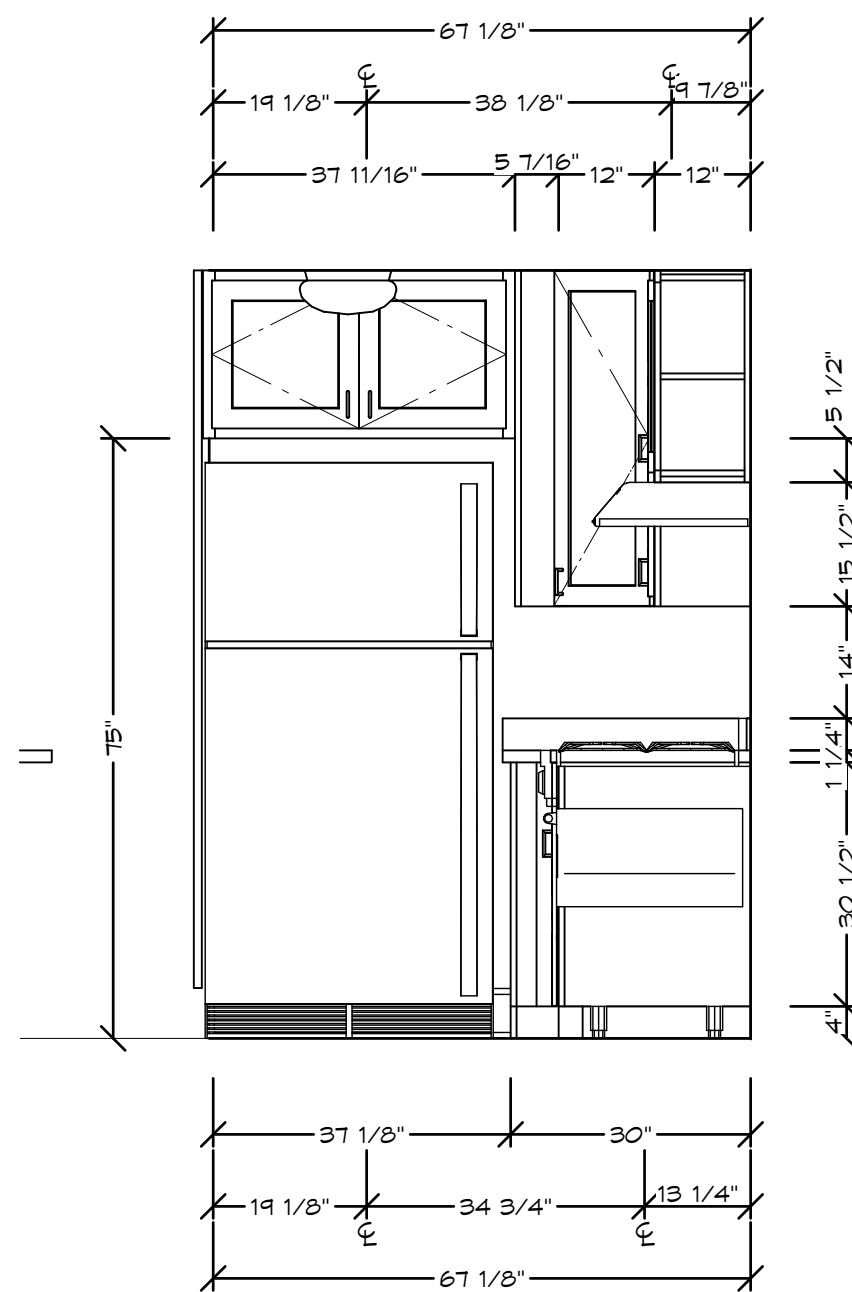

REFRIGERATOR ELEVATION

1/2"=1'

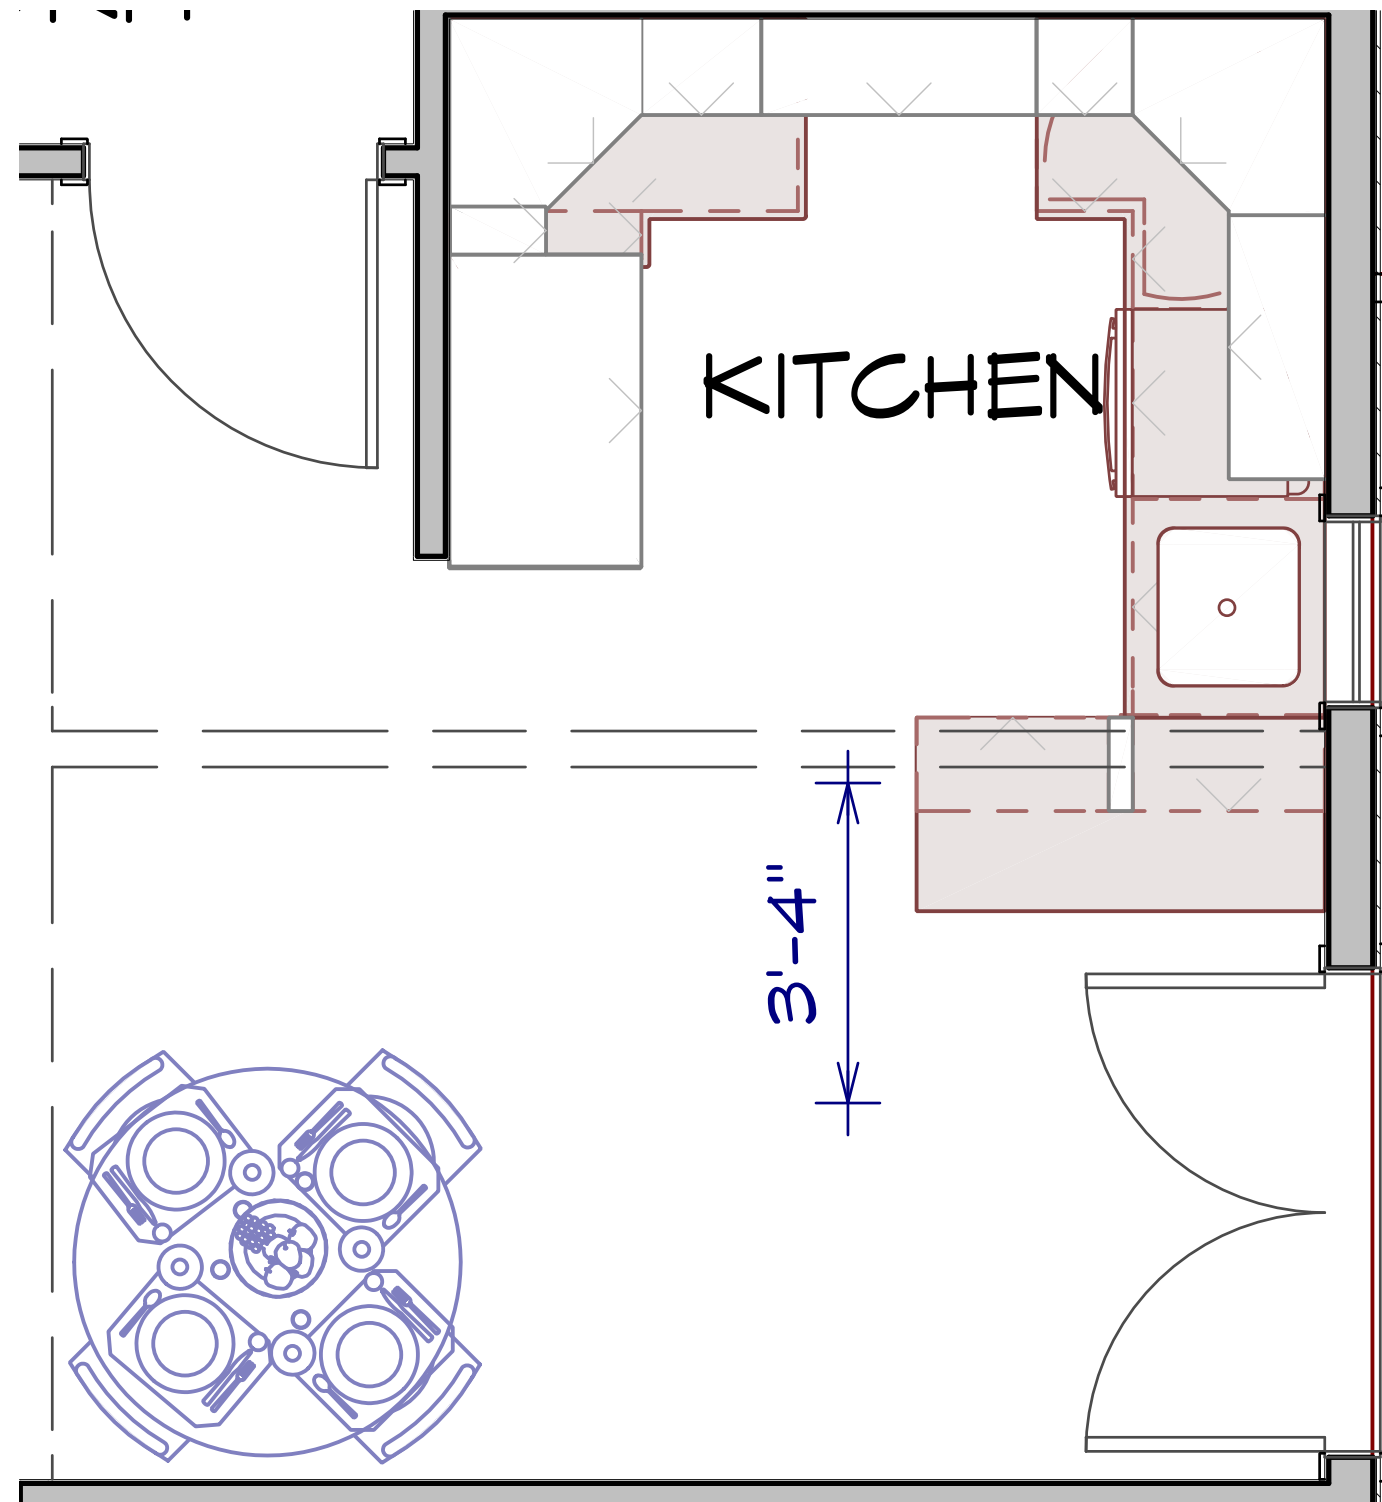

KITCHEN FLOOR PLAN

1/2"=1'

REVISION TABLE	
NUMBER	DATE

KITCHEN ELEVATIONS

DRAWING:	DESIGNED BY: D HAYDEN
	DRAWN BY: D HAYDEN
	CHECKED BY:
	FILE NAME

DATE:
7/23/2018

SCALE:
--------

1/2" = 1'
-----------

SHEET:
--------


P-12
------






MASTER BATH RENDERING

FOR ILLUSTRATION ONLY - NO SCALE

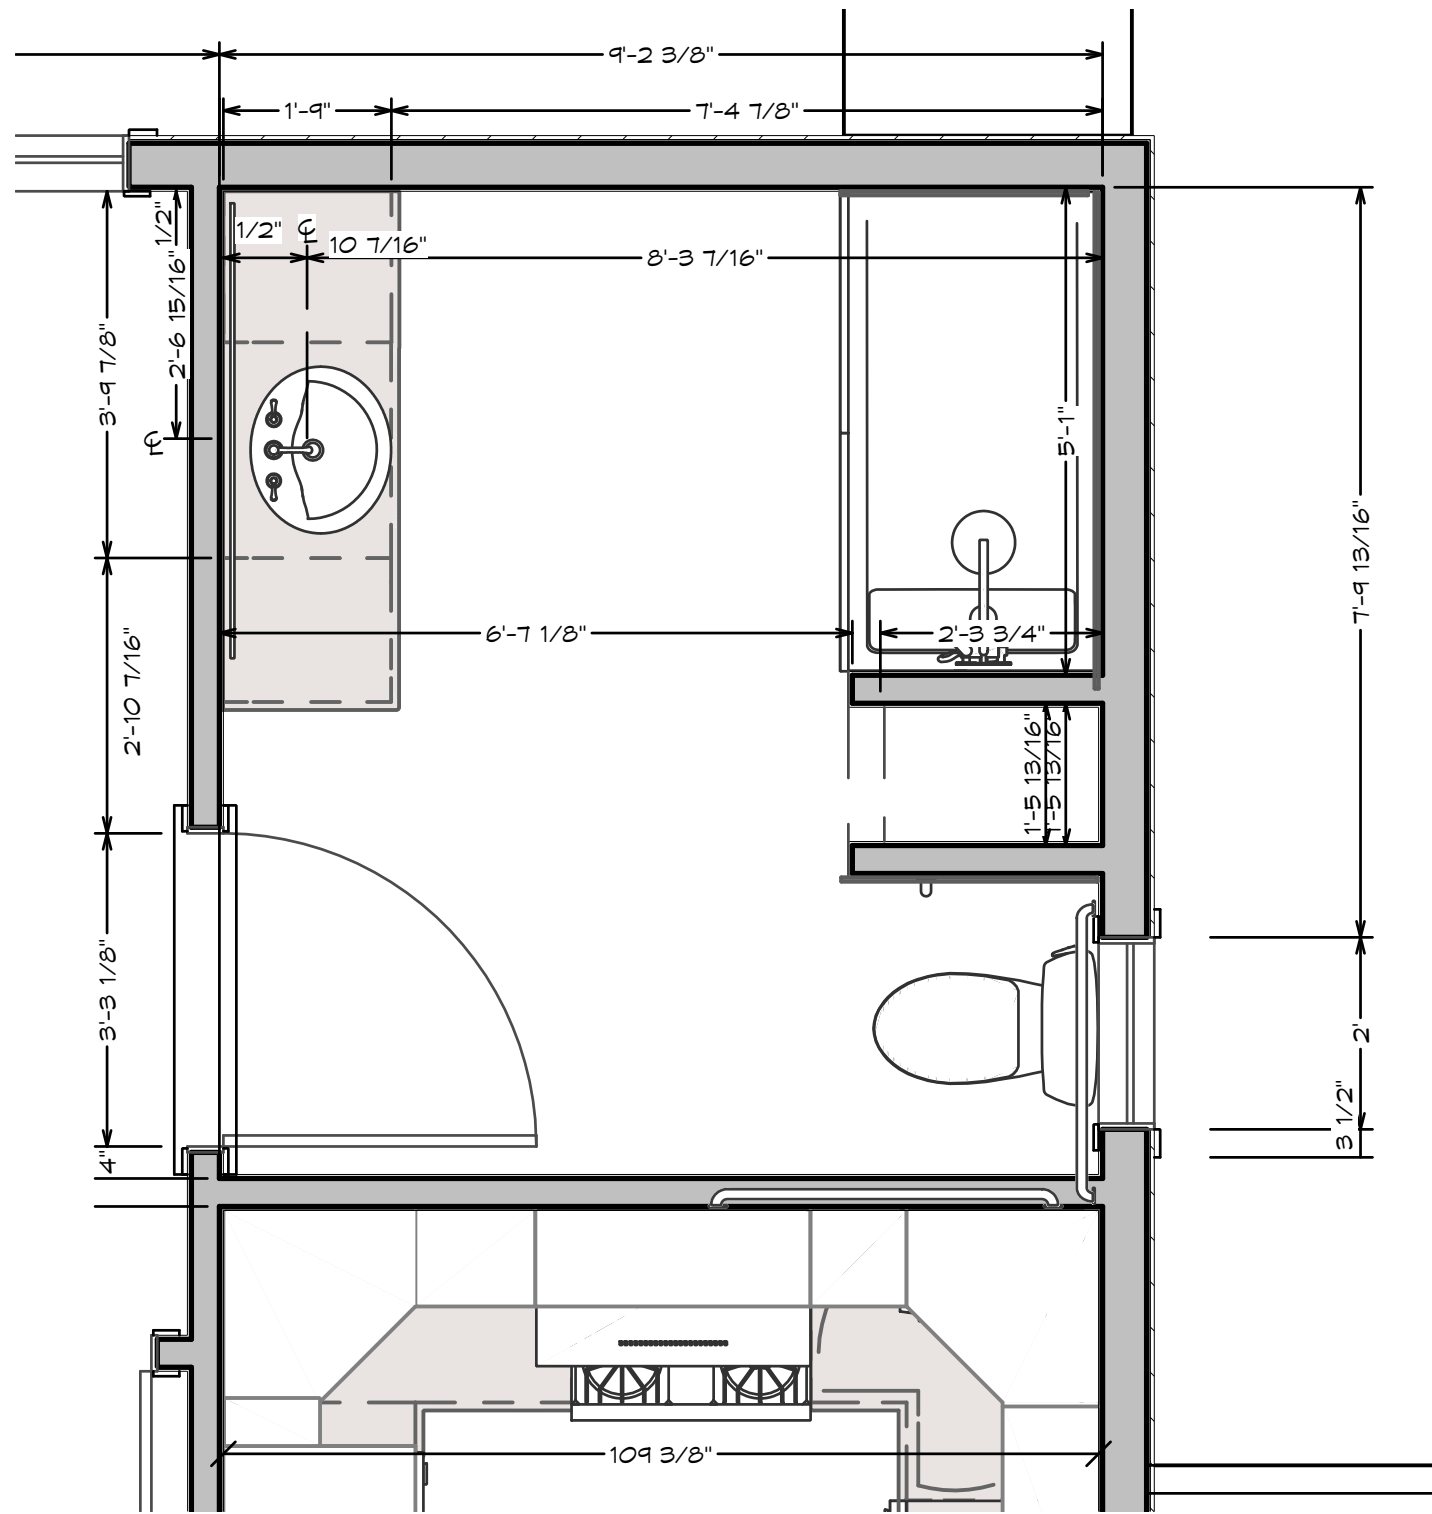


MASTER BATH FLOOR PLAN

1/2"=1'

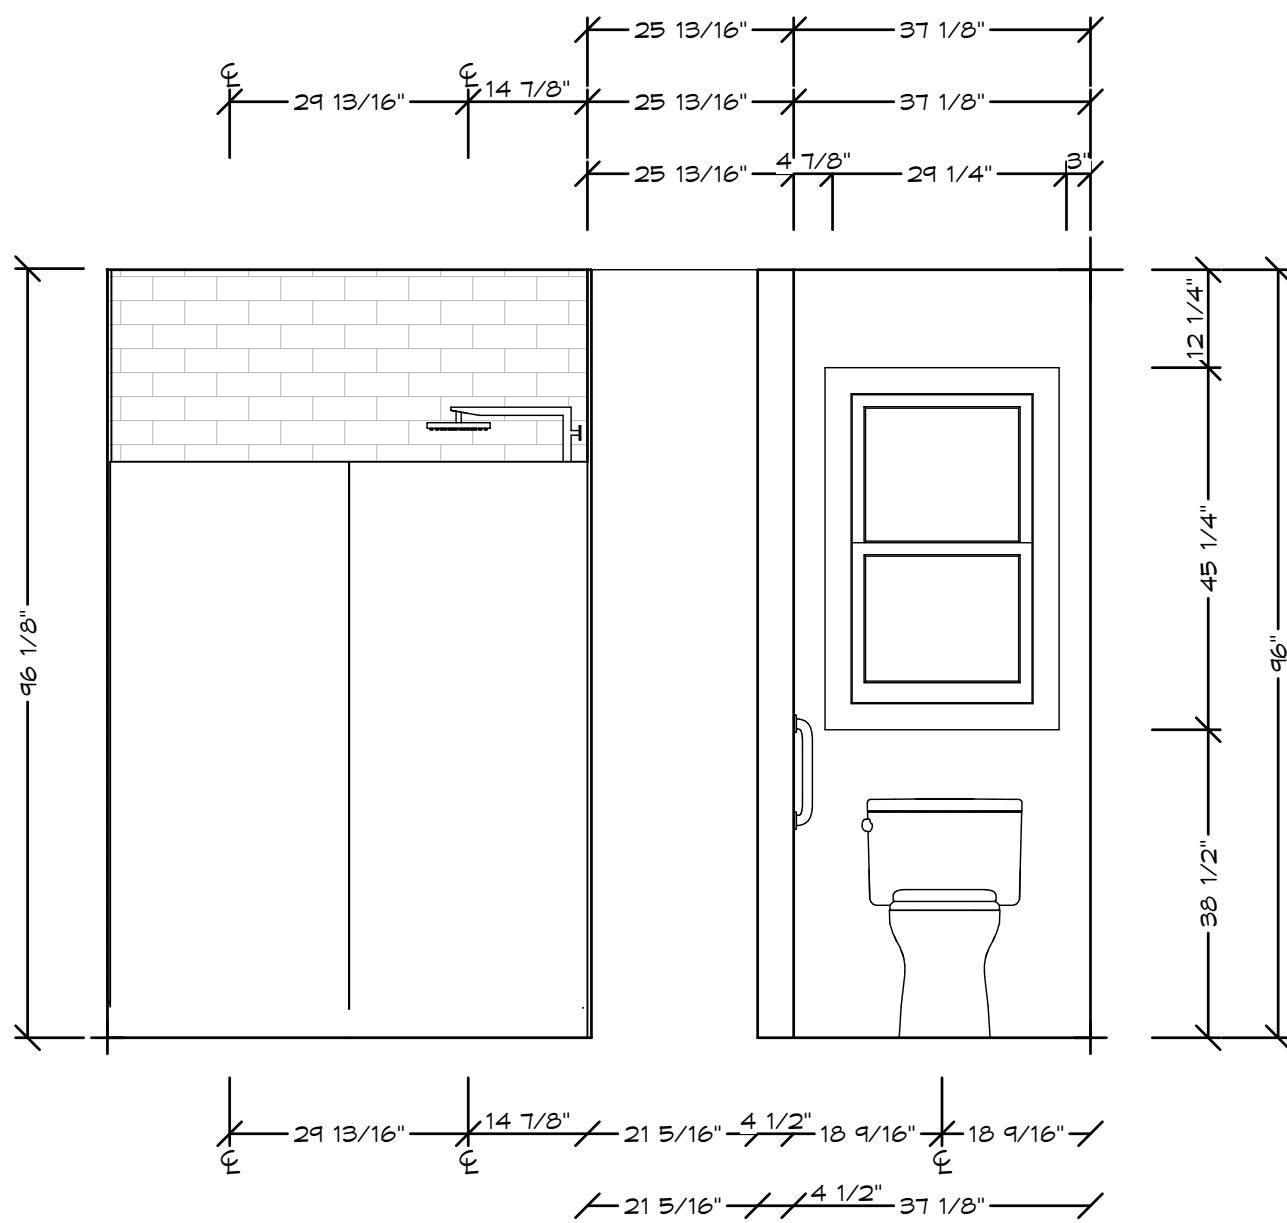

MASTER BATH SHOWER ELEVATION

1/2"=1'

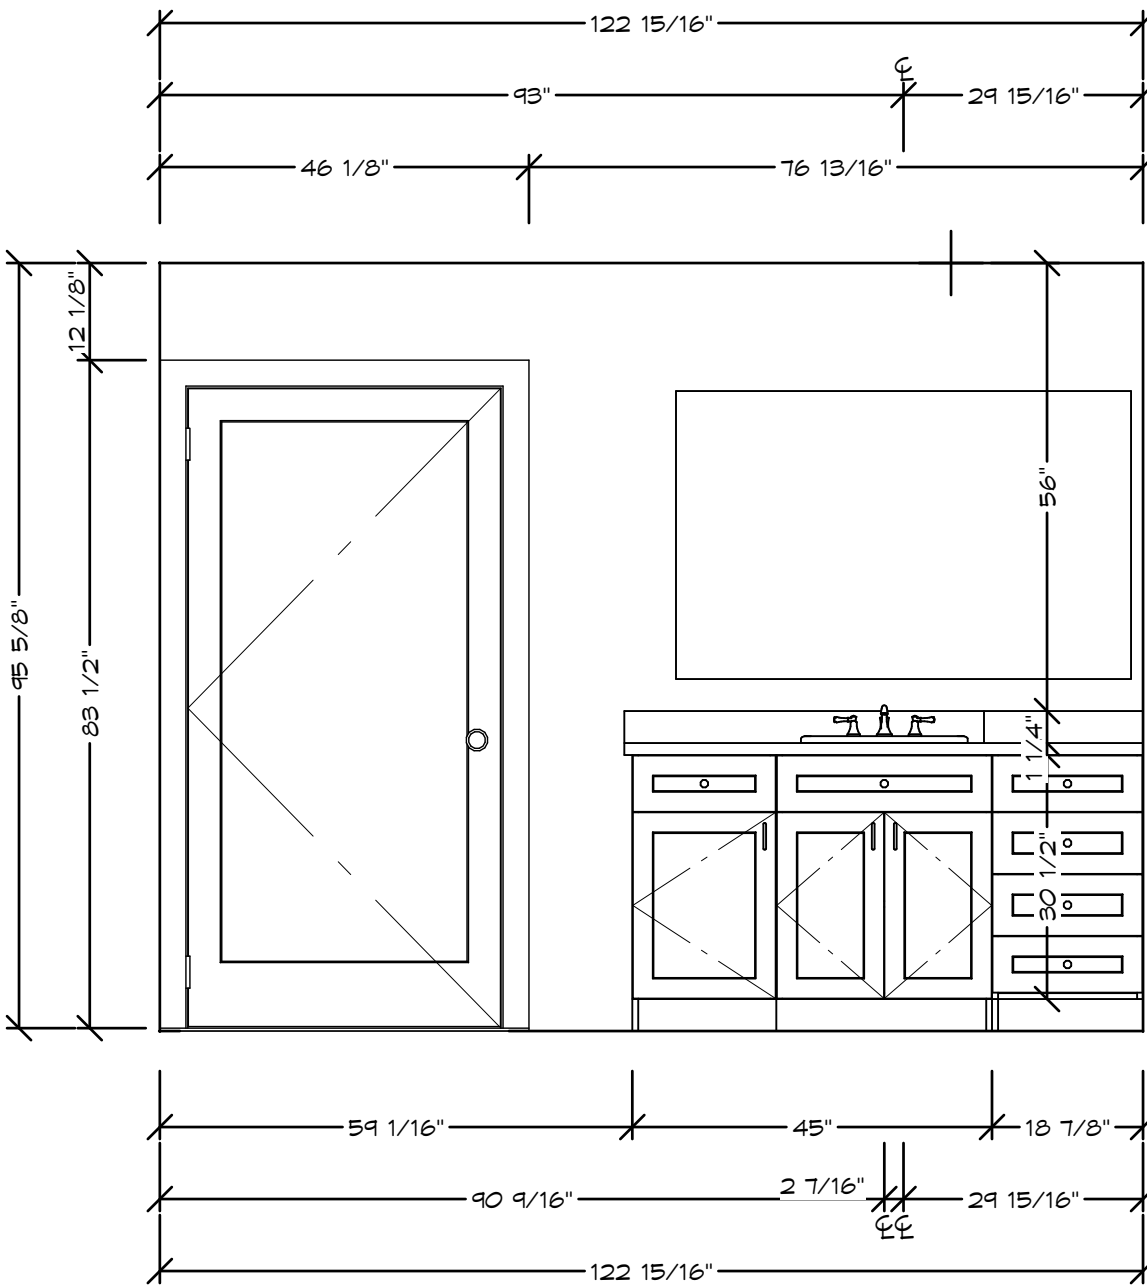

MASTER BATH SINK ELEVATION

1/2"=1'

REVISION TABLE	
NUMBER	DATE


BATH ELEVATIONS

DRAWING:	DESIGNED BY: D HAYDEN
	DRAWN BY: D HAYDEN
	CHECKED BY:
	FILE NAME

DATE: 7/23/2018

SCALE:

1/2" = 1'

SHEET:

P-13





FRONT ELEVATION

1/4"=1'

REAR ELEVATION

1/4"=1'

S. SIDE ELEVATION

1/4"=1'

N. SIDE ELEVATION

1/8"=1'

REVISION TABLE	
NUMBER	DATE



DRAWING:	DESIGNED BY: D HAYDEN
	DRAWN BY: D HAYDEN
	CHECKED BY:
	FILE NAME

DATE:

7/23/2018

SCALE:

--

SHEET:


P-14



ROOF FRAMING NOTES


COMBINATION HAND FRAME AND TRUSS FRAMING FOR ROOF

- 1. TRUSS DRAWING IS FOR ILLUSTRATION ONLY. ALL TRUSSES SHALL BE INSTALLED & BRACED TO MANUFACTURER'S DRAWINGS & SPECIFICATIONS
- 2. ALL TRUSSES SHALL CARRY MANUFACTURER'S STAMP
- 3. TRUSSES SHALL NOT BE FIELD ALTERED WITHOUT PRIOR ENGINEERING APPROVAL
- 4. ALL TRUSSES SHALL HAVE DESIGN DETAILS & DRAWINGS ON SITE FOR FRAMING INSPECTION.
- 5. ALL CONNECTIONS OF RAFTERS, JACK OR HIP TRUSSES TO MAIN GIRDER TO BE PROVIDED BY TRUSS MANUFACTURER
- 6. ALL ROOF OVERHANGS 18"; DORMER OVERHANGS 10", UNO
- 7. INSTALL ICE SHIELD AS REQUIRED
- 8. ATTIC VENTILATION: REQUIRED ABOVE HOUSE
- 9. ROOF VENTING HIGH/LOW

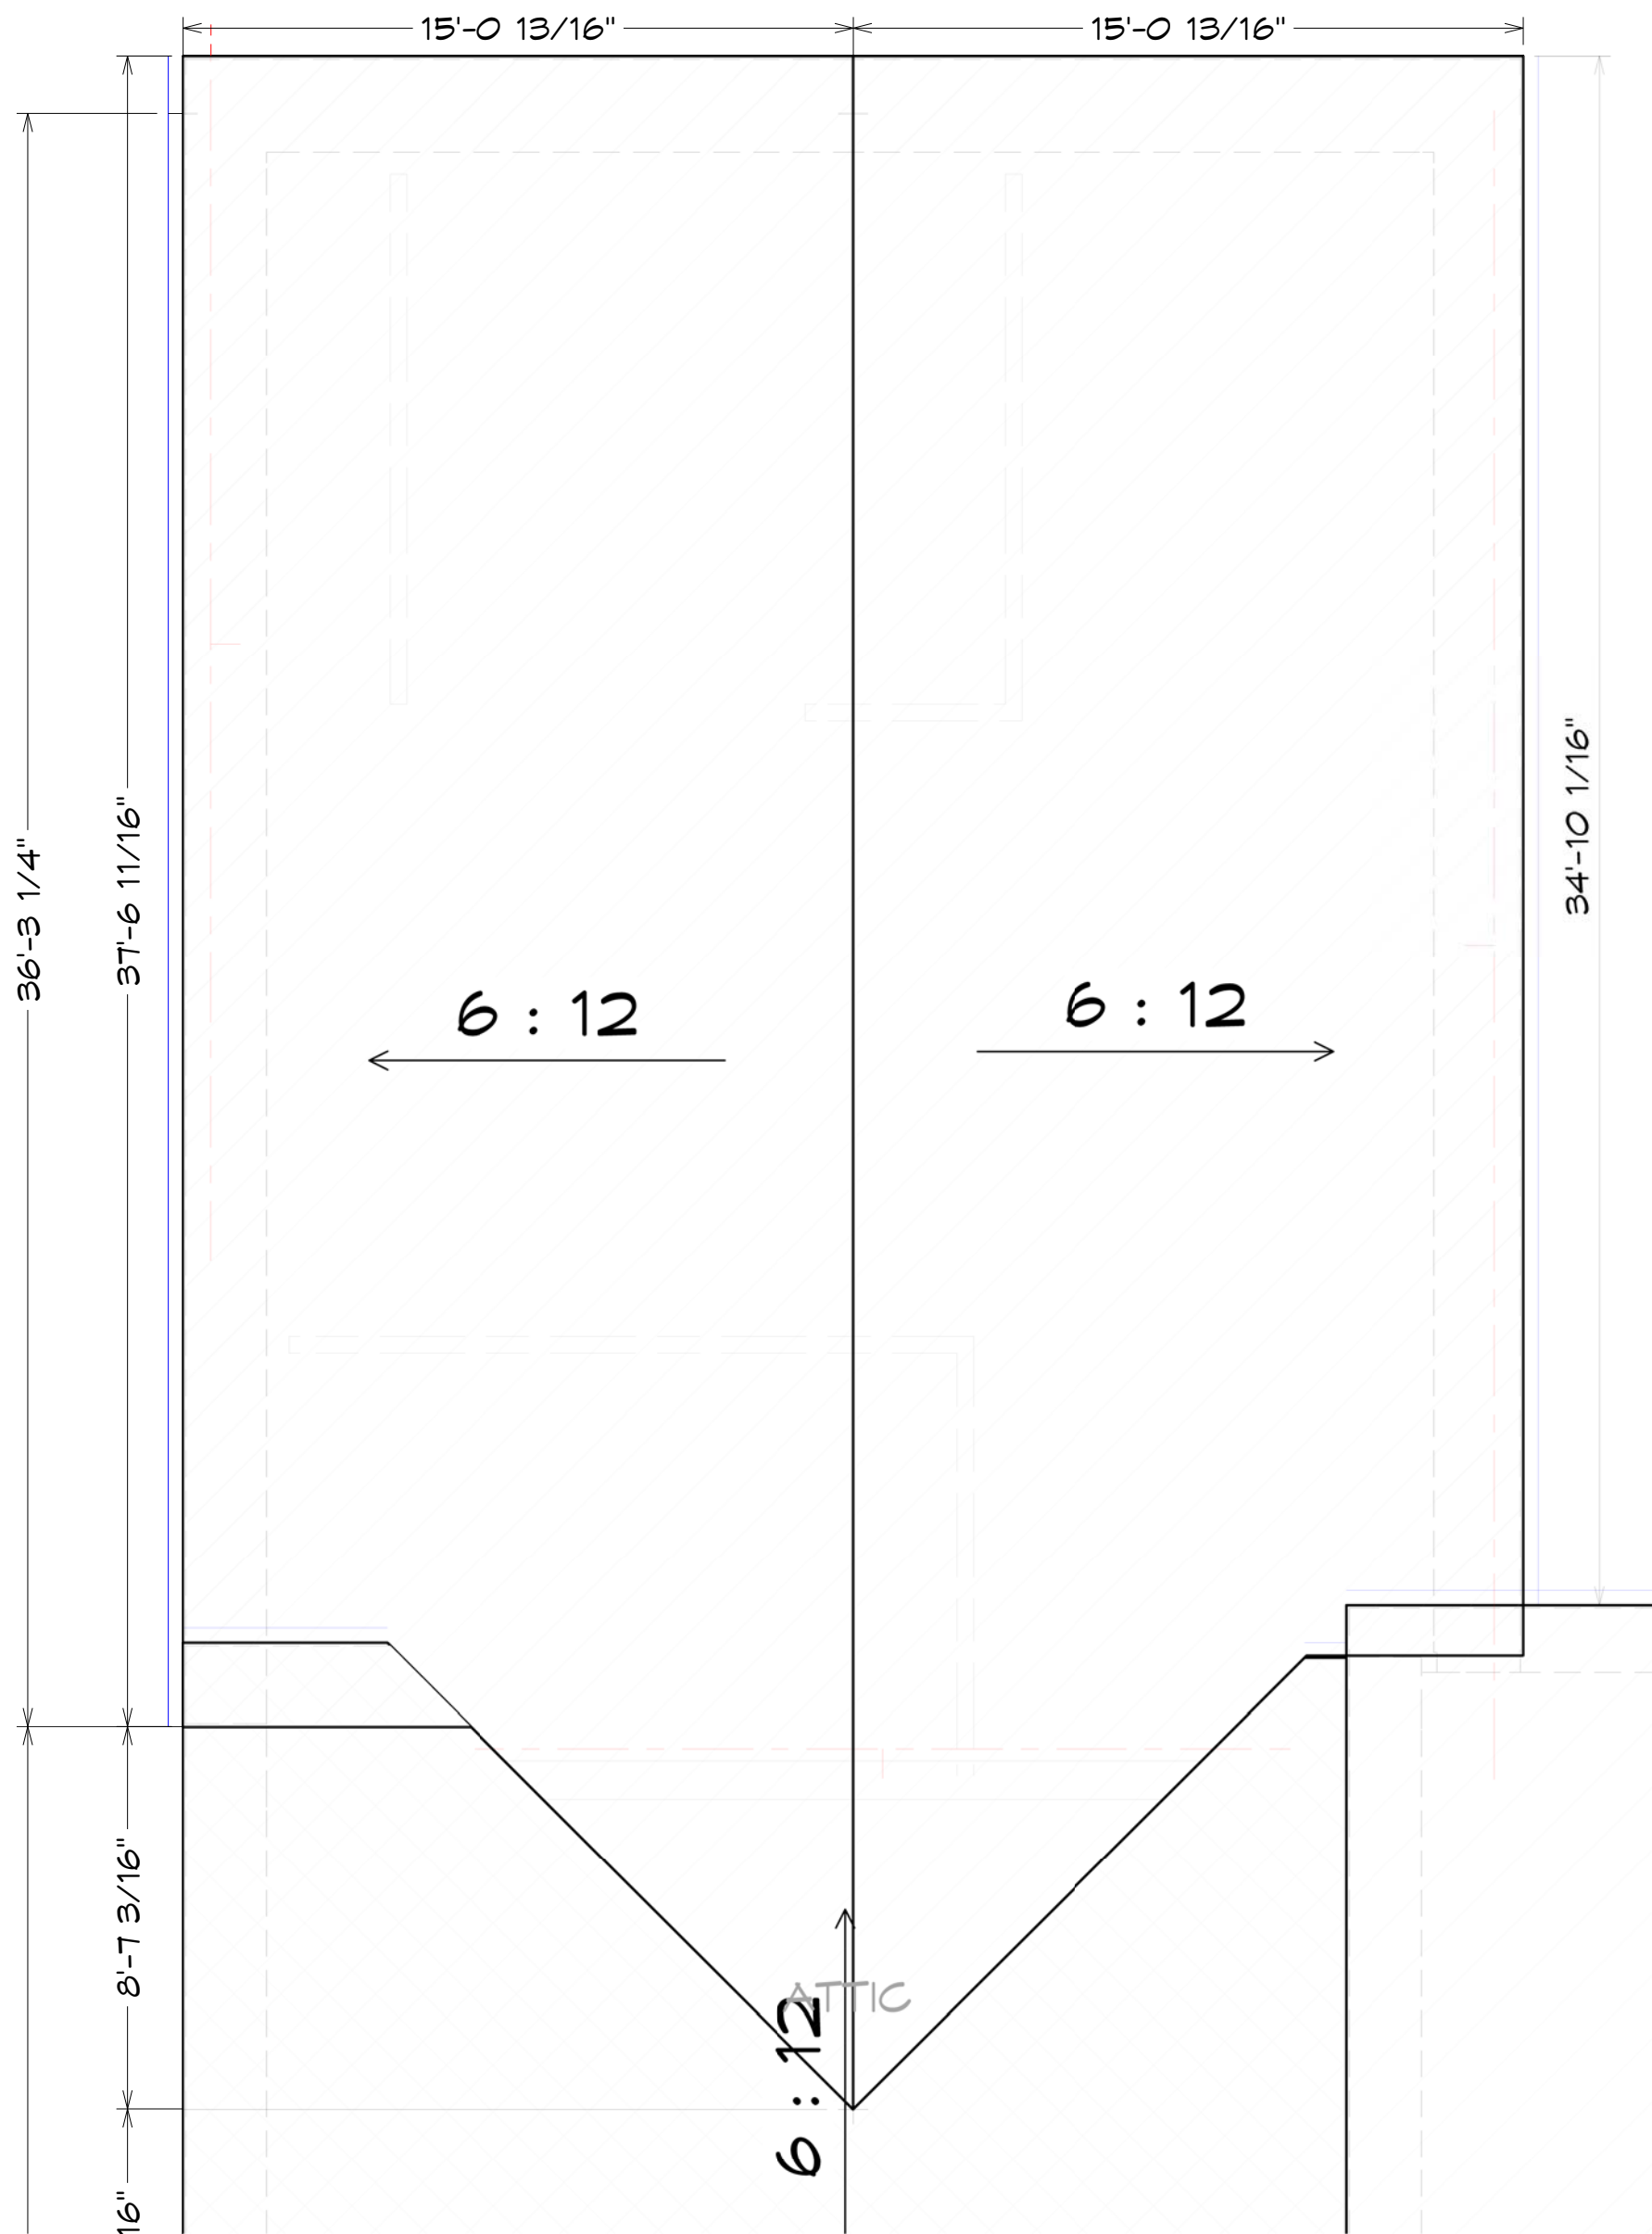

ROOF PLAN

3/16"=1'

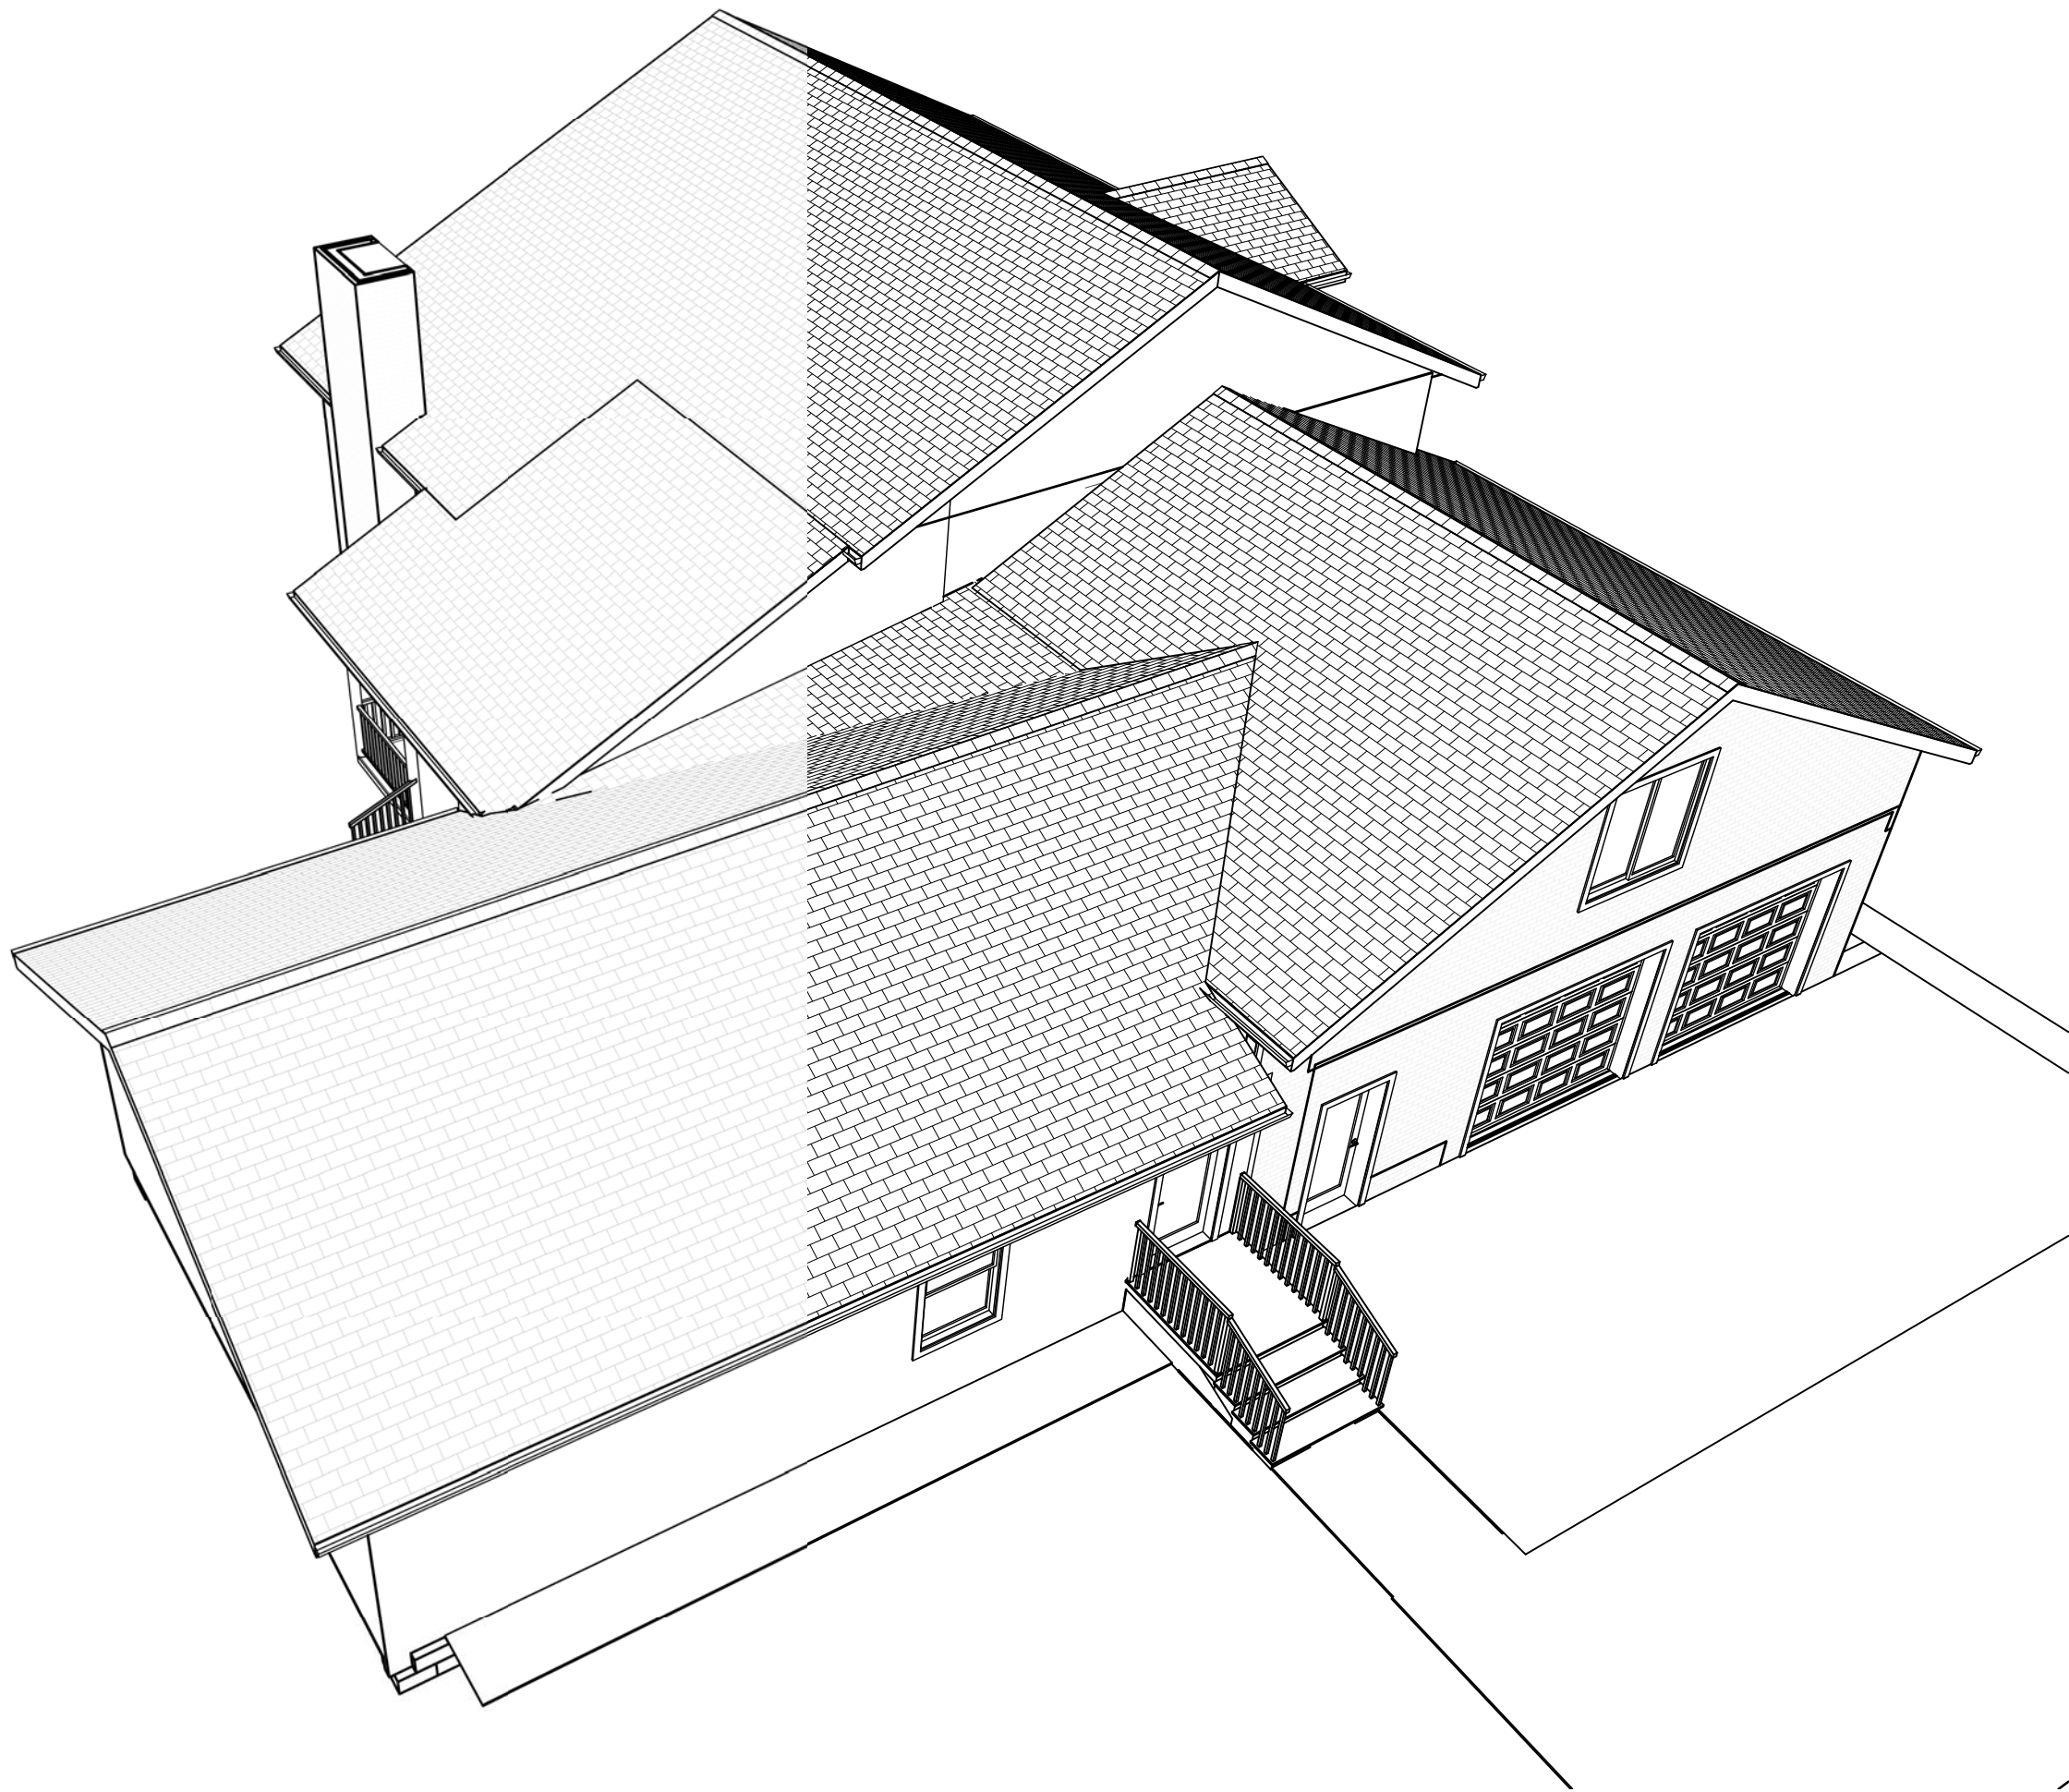

ROOF RENDERING

NO SCALE - FOR ILLUSTRATION ONLY

REVISION TABLE	
NUMBER	DATE


ROOF PLAN

DRAWING:	DESIGNED BY: D HAYDEN
	DRAWN BY: D HAYDEN
	CHECKED BY:
	FILE NAME

DATE:

7/23/2018






SCALE:

3/16" = 1'

SHEET:

P-15



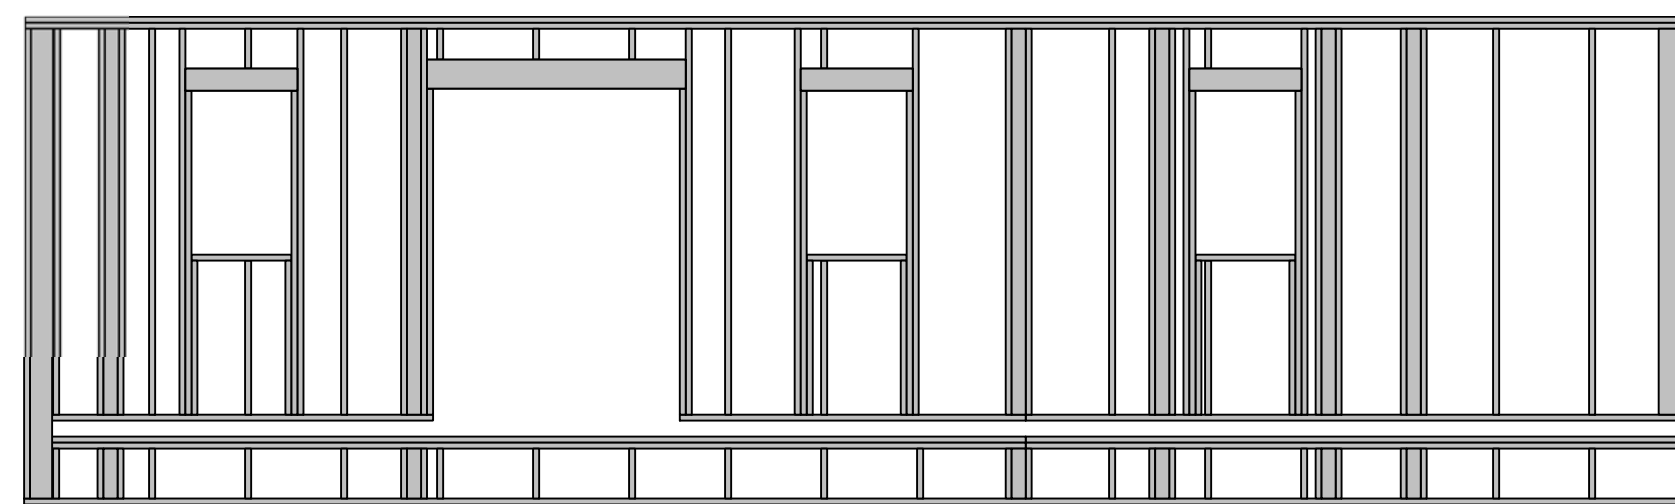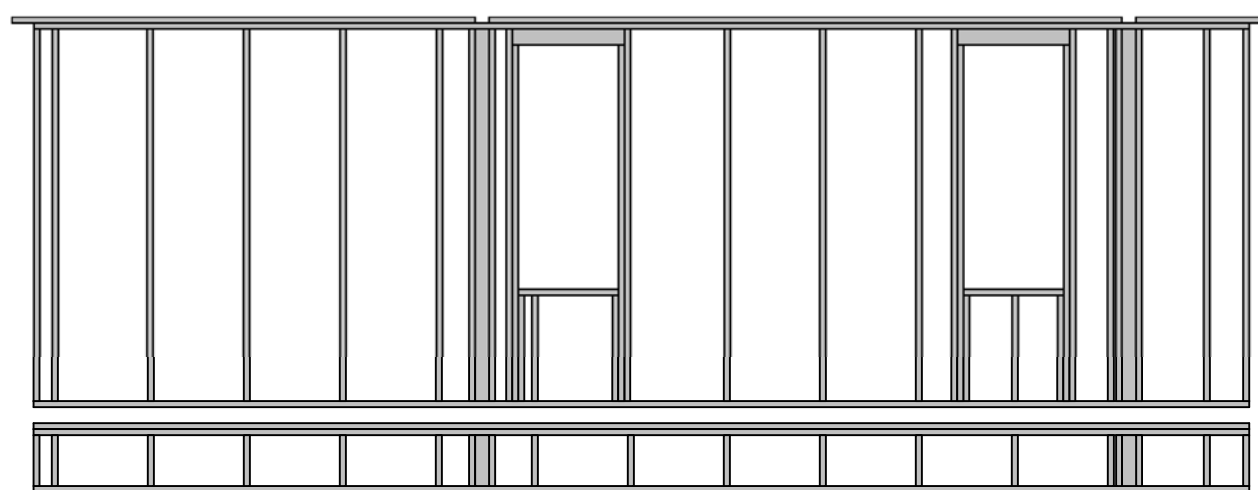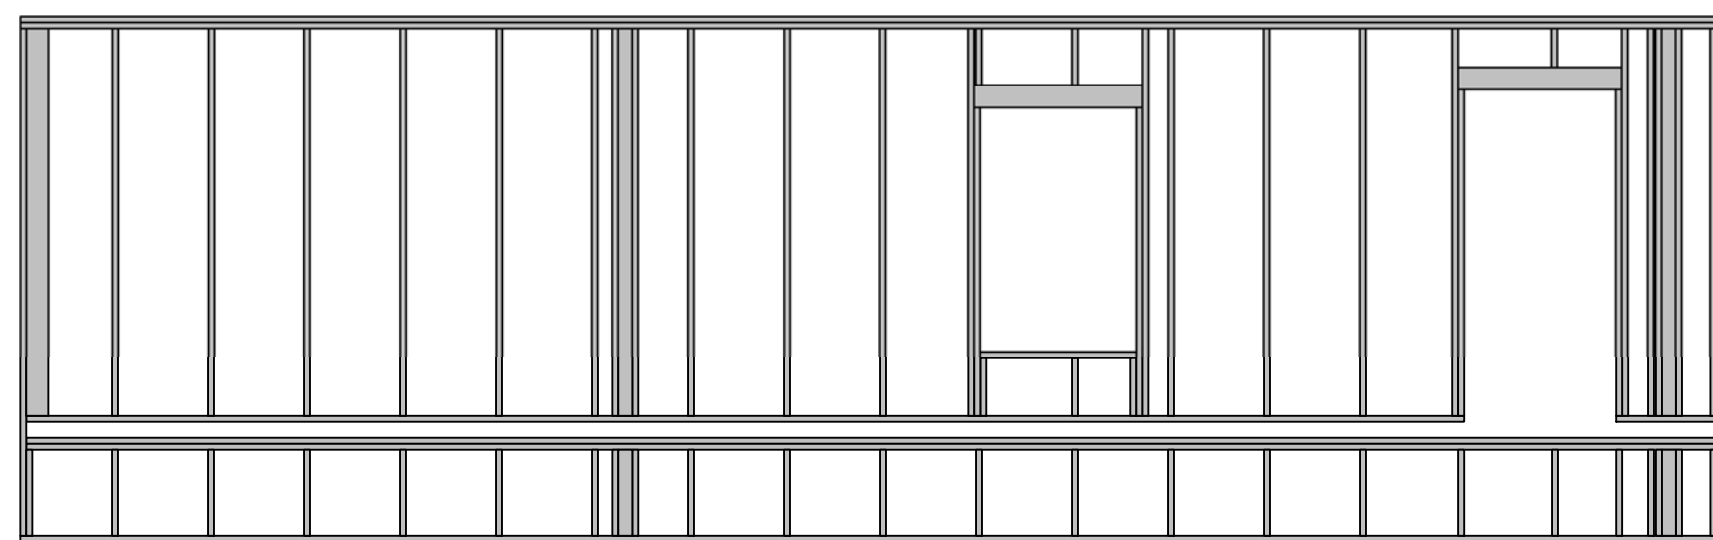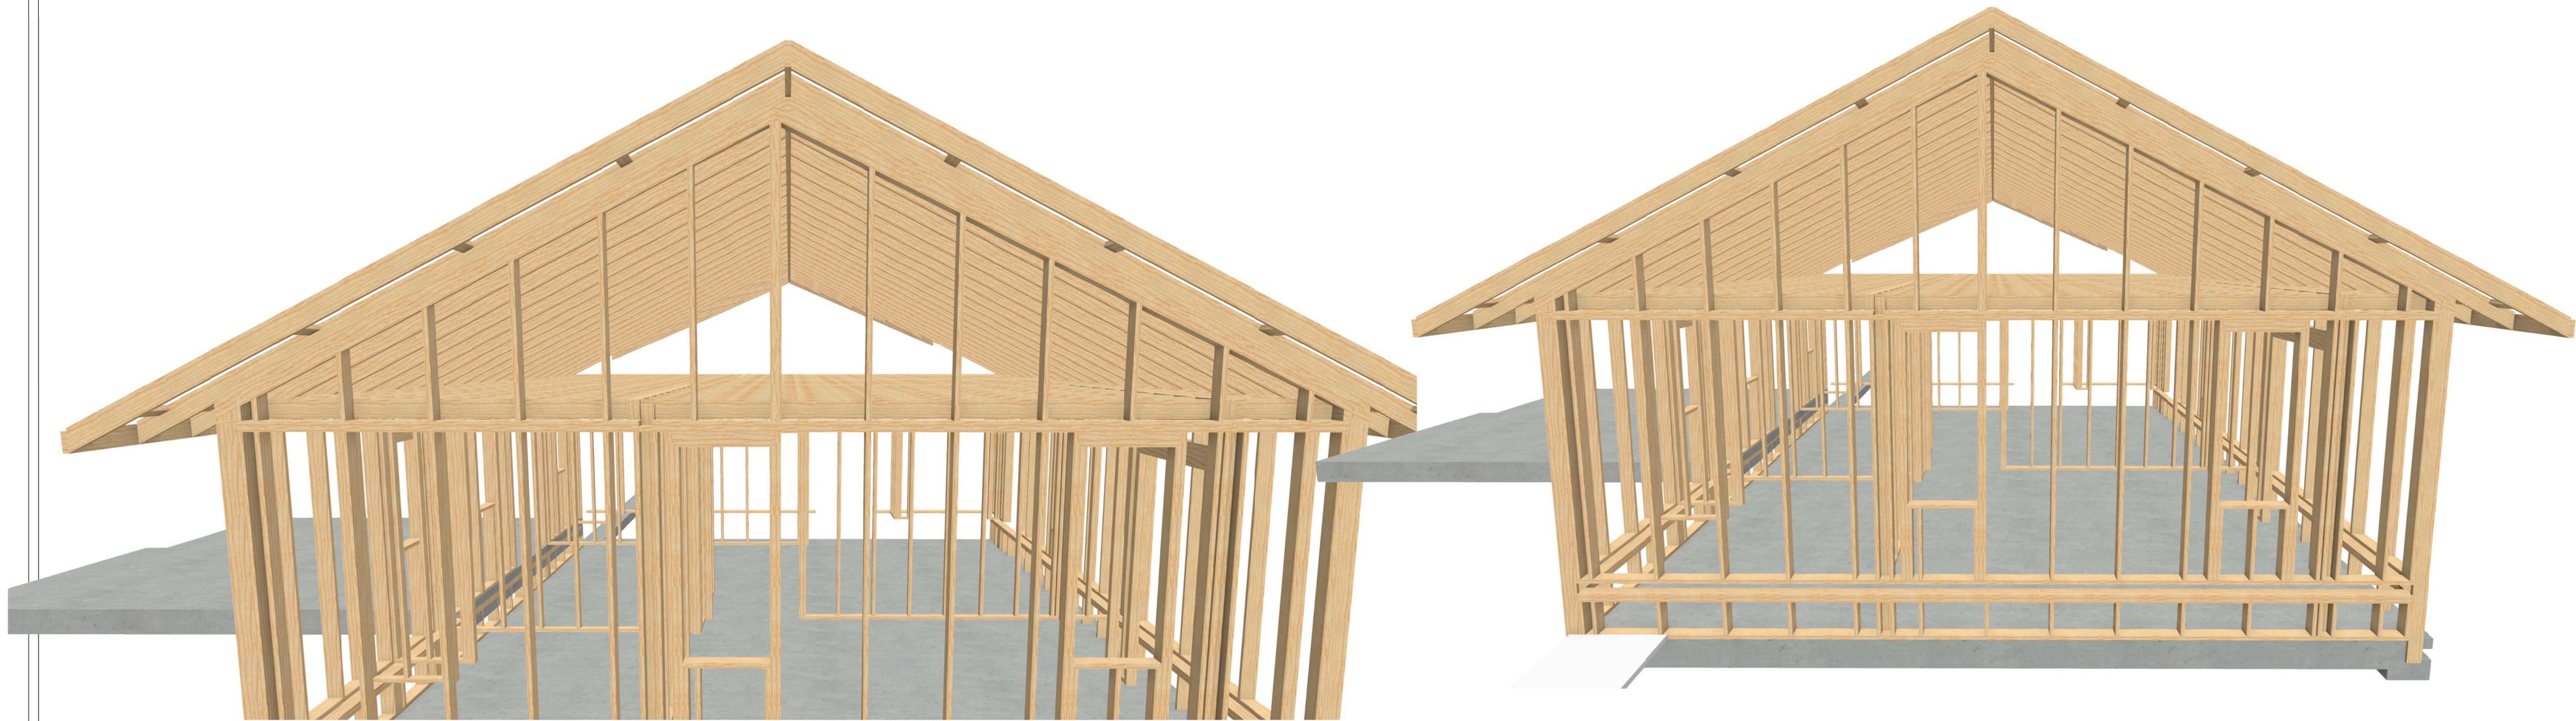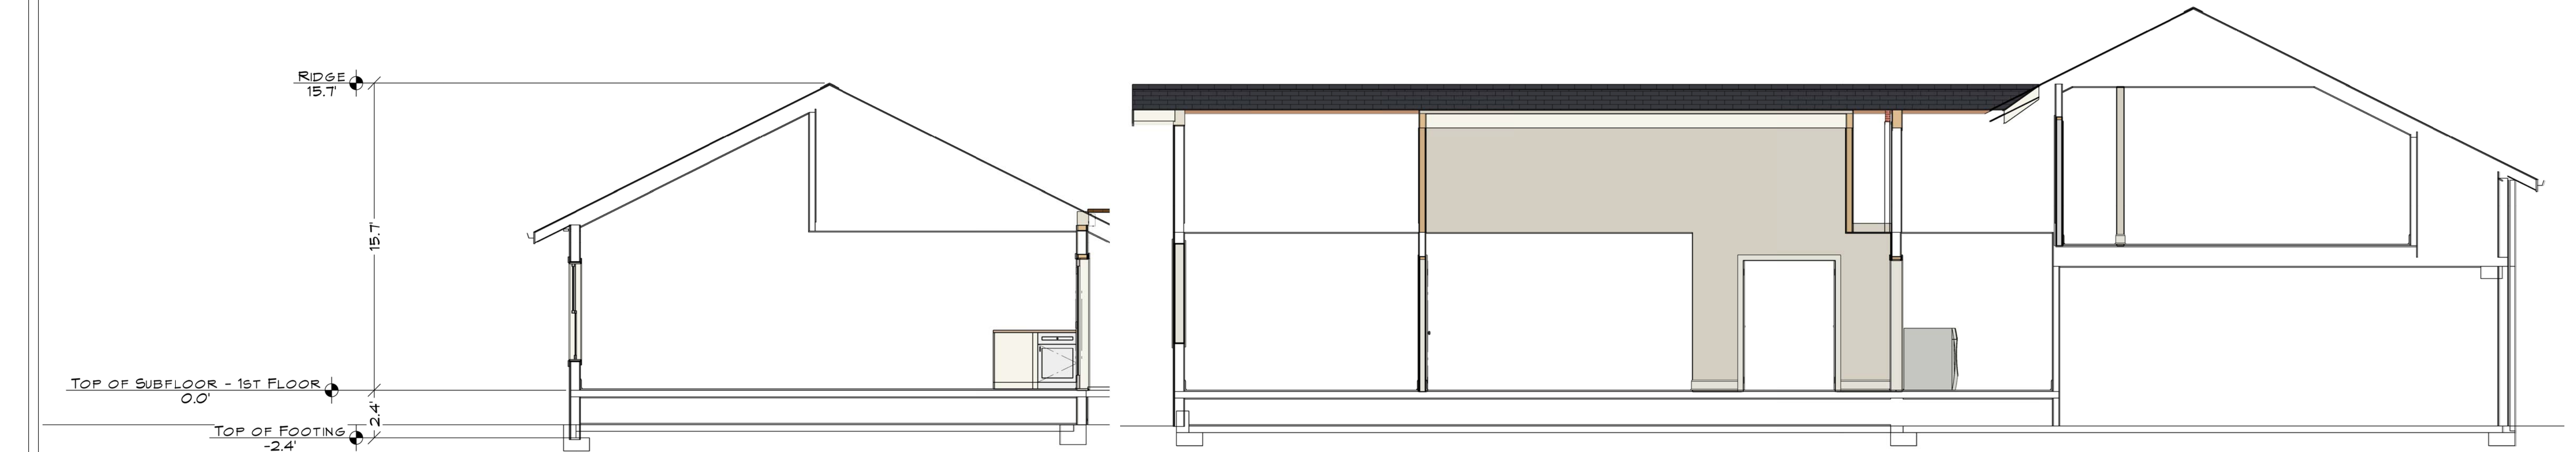

REVISION TABLE	
NUMBER	DATE


## SECTION VIEWS

DRAWING:	DESIGNED BY: D HAYDEN
	DRAWN BY: D HAYDEN
	CHECKED BY:
	FILE NAME

DATE:

7/23/2018

SCALE:

1/2" = 1'


SHEET:

P-16



FOUNDATION NOTES

- 8" CONC. STEM WALL W/ #4 VERTS  
@18" O/C W/ STD 90° HOOK INTO FTG. &  
#4 HORIZ. @ 12" O/C
- FOUNDATIONS TO BEAR A MINIMUM OF 24" BELOW FINISH GRADE
  - ALL ANCHOR BOLTS TO BE 5/8" DIA X 10 @ 32" O/C UNO.
  - ALL REINFORCING STEEL SHALL BE ASTM A-615, GRADE 60.
  - ALL REINFORCING STEEL TO OVERLAP A MINIMUM OF 24" FOR SPLICES.
  - PROVIDE CORNER BARS TO MATCH CONTINUOUS STEEL.
  - MINIMUM ALLOWABLE CONCRETE COMPRESSIVE STRENGTH SHALL BE 3000 PSI AT 26 DAYS. MAXIMUM AGGREGATE SIZE IS 1". MAXIMUM AIR ENTRAINMENT IS 3%. CEMENT SHOULD BE TYPE 1 OR 2.
  - SOIL BEARING CAPACITY ASSUMED TO BE 1500 PSF (UBC TYPE 4 SOIL). IF SOIL CONDITIONS VARY FROM THIS, THE PROJECT ENGINEER MUST BE NOTIFIED. ALL FOOTINGS MUST BEAR ON UNDISTURBED SOIL. ALL SLOPES MUST BE STABILIZED.
  - ADJACENT GROUND SURFACES SHALL BE SLOPED AWAY FROM STRUCTURE DRAINAGE OF SURROUNDING AREA SHALL ALSO BE PROVIDED TO PREVENT ACCUMULATION OF SOIL AND EROSION OF SOIL NEAR FOOTINGS.
  - UNIFORM SOIL CONDITIONS, MUST BE PROVIDED UNDER SLAB AND FOOTINGS. CUT/FILL OR NON-UNIFORM SOIL CONDITIONS SHOULD BE EXCAVATED AND REPLACED W/ UNIFORM ENGINEERED FILL MATERIAL TO MINIMIZE DIFFERENTIAL MOVEMENT.
  - THE TOPS OF FOUNDATION WALLS SHALL EXTEND 6" ABOVE THE ADJACENT FINISH GRADE  
MINIMUM 18" CLEARANCE FOR WOOD JOIST GIRDERS REQUIRED IN THE CRAWL SPACE UNLESS TREATED WOOD IS USED THROUGHOUT FLOOR SYSTEM

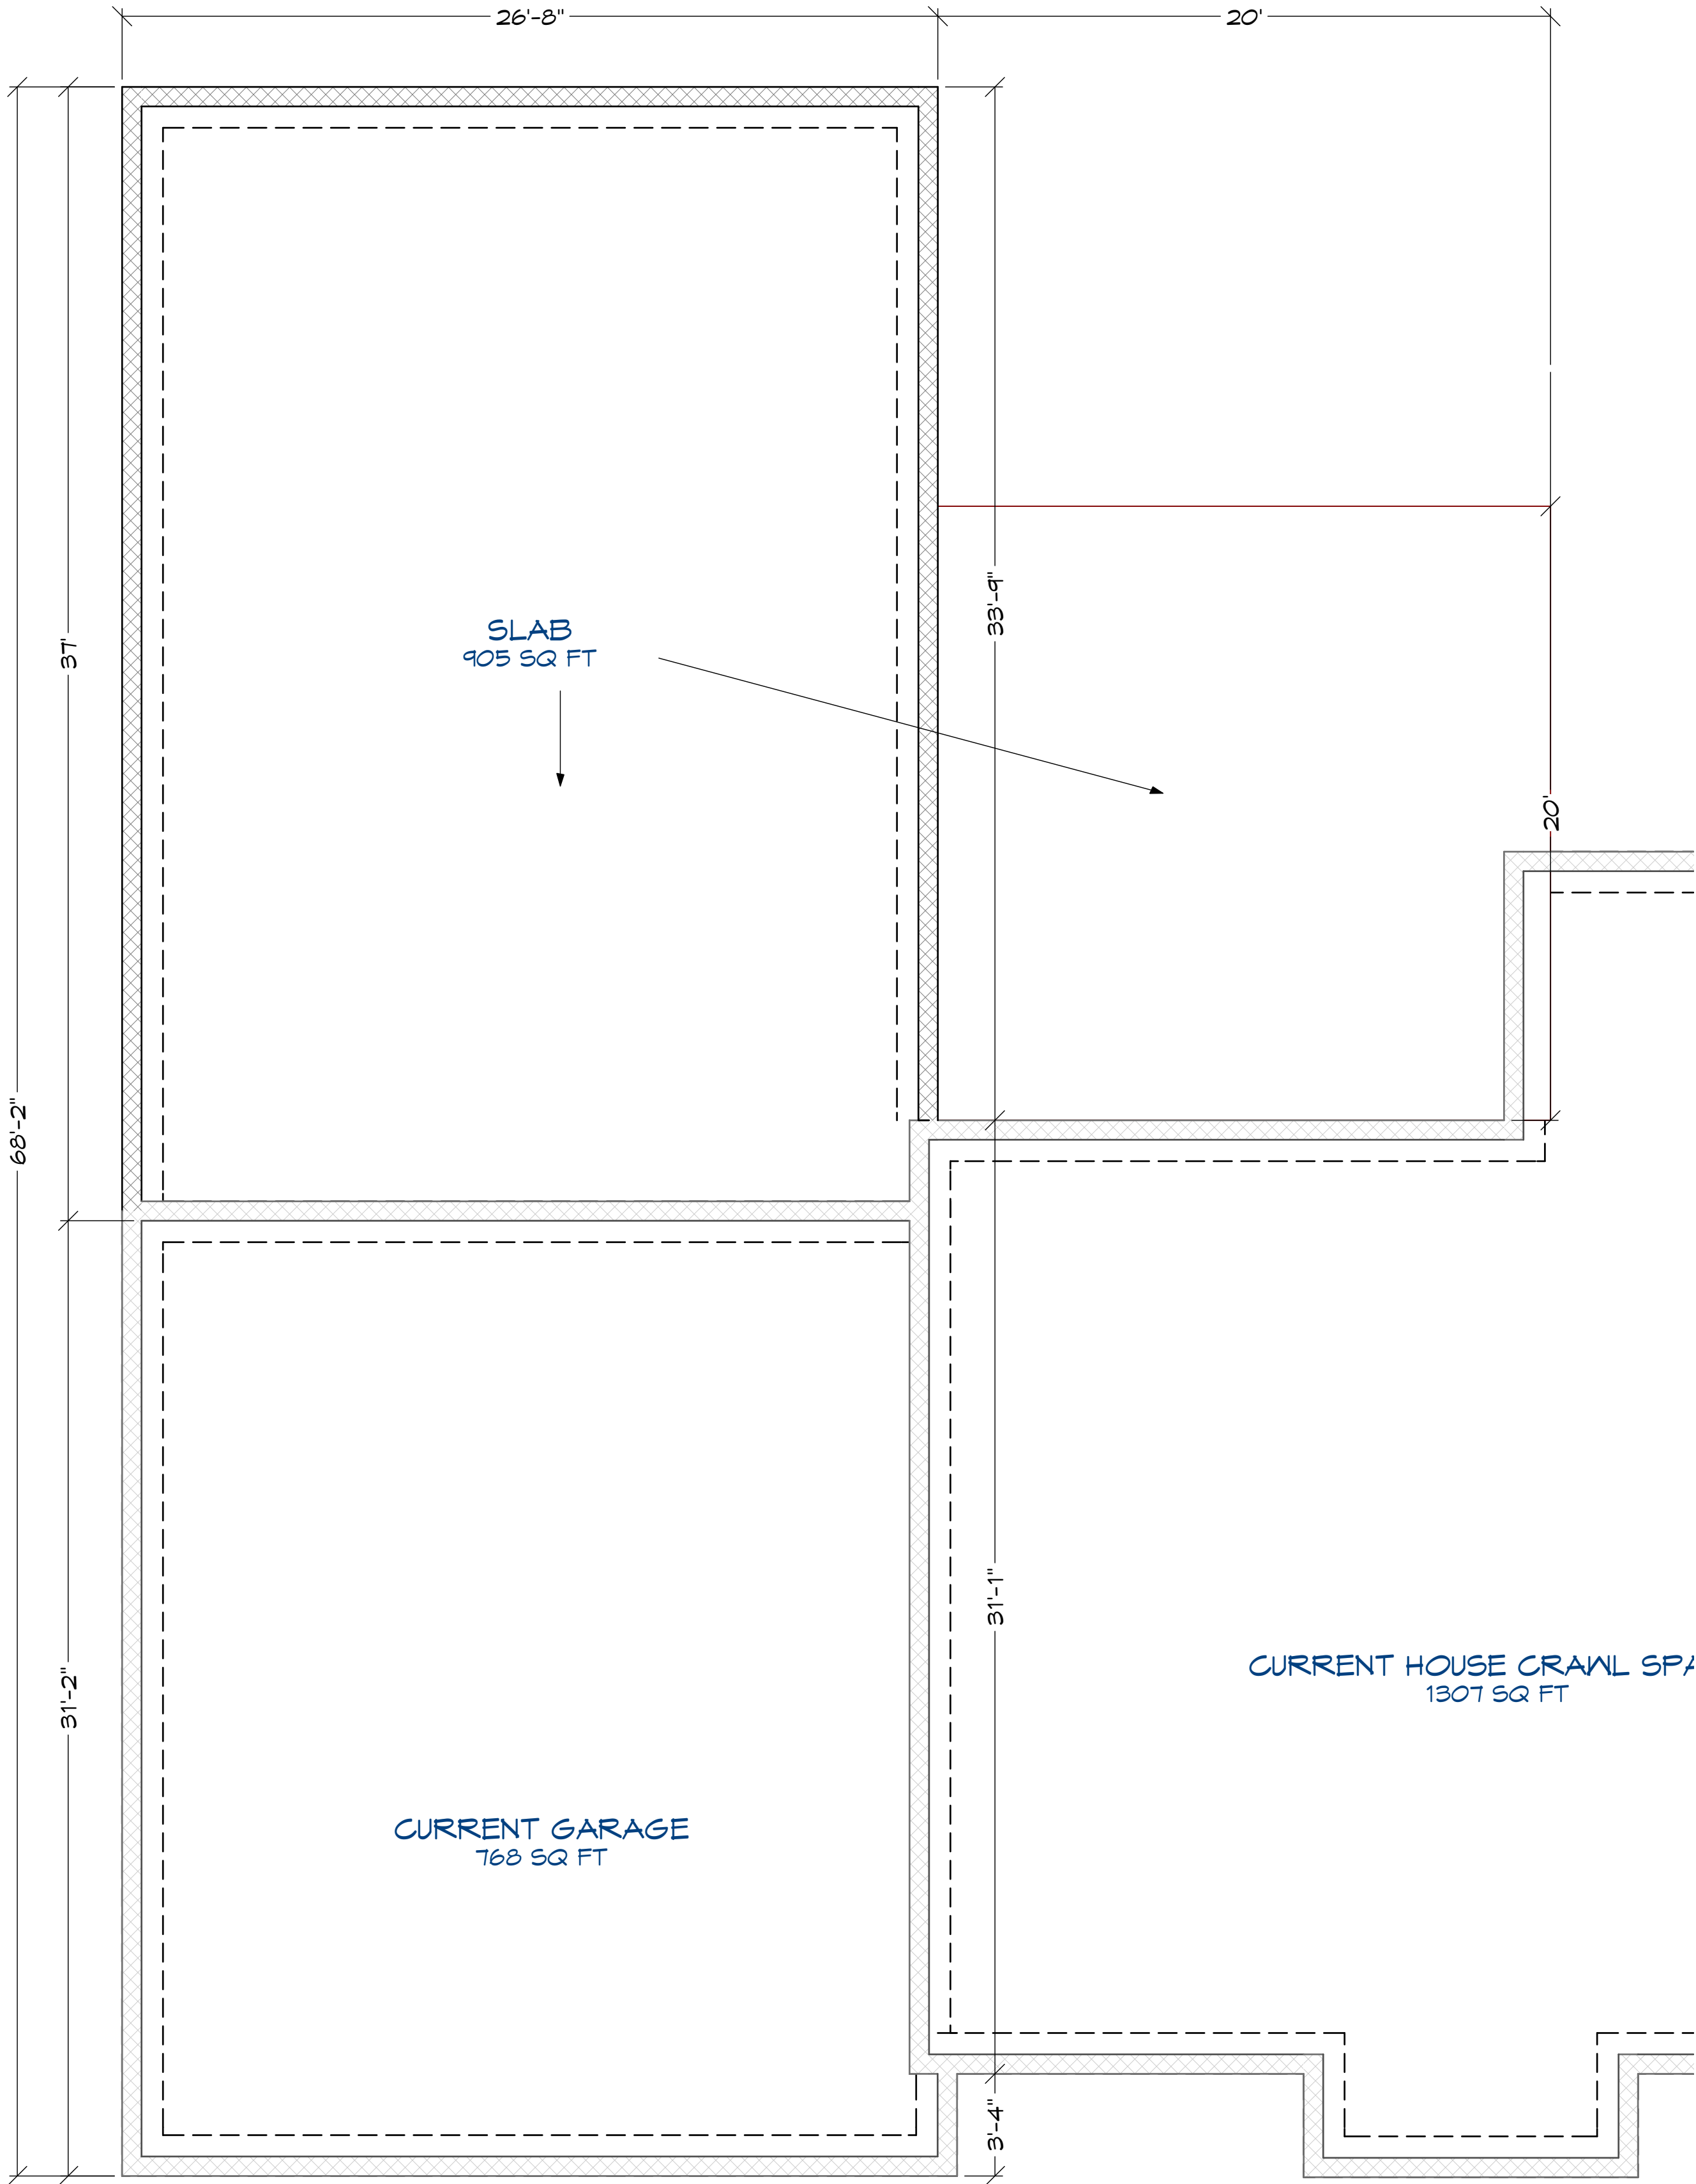

FOUNDATION PLAN - FLOOR 0

1/4"=1'

Disclaimer: Measurements are approximate and are for illustrative purposes only. While we do not doubt the plans accuracy, we make no guarantee, warranty or representation as to the accuracy and completeness of the floor plan. You or your advisors should conduct a careful, independent investigation of the property to determine to your satisfaction as to the suitability of the property for your space requirements.


REVISION TABLE		REVISION BY	DESCRIPTION
NUMBER	DATE		

FOUNDATION PLAN

DRAWING:	DESIGNED BY: D HAYDEN
	DRAWN BY: D HAYDEN
	CHECKED BY:
	FILE NAME

DATE:
7/23/2018
SCALE:
1/4" = 1'
SHEET:
P-17



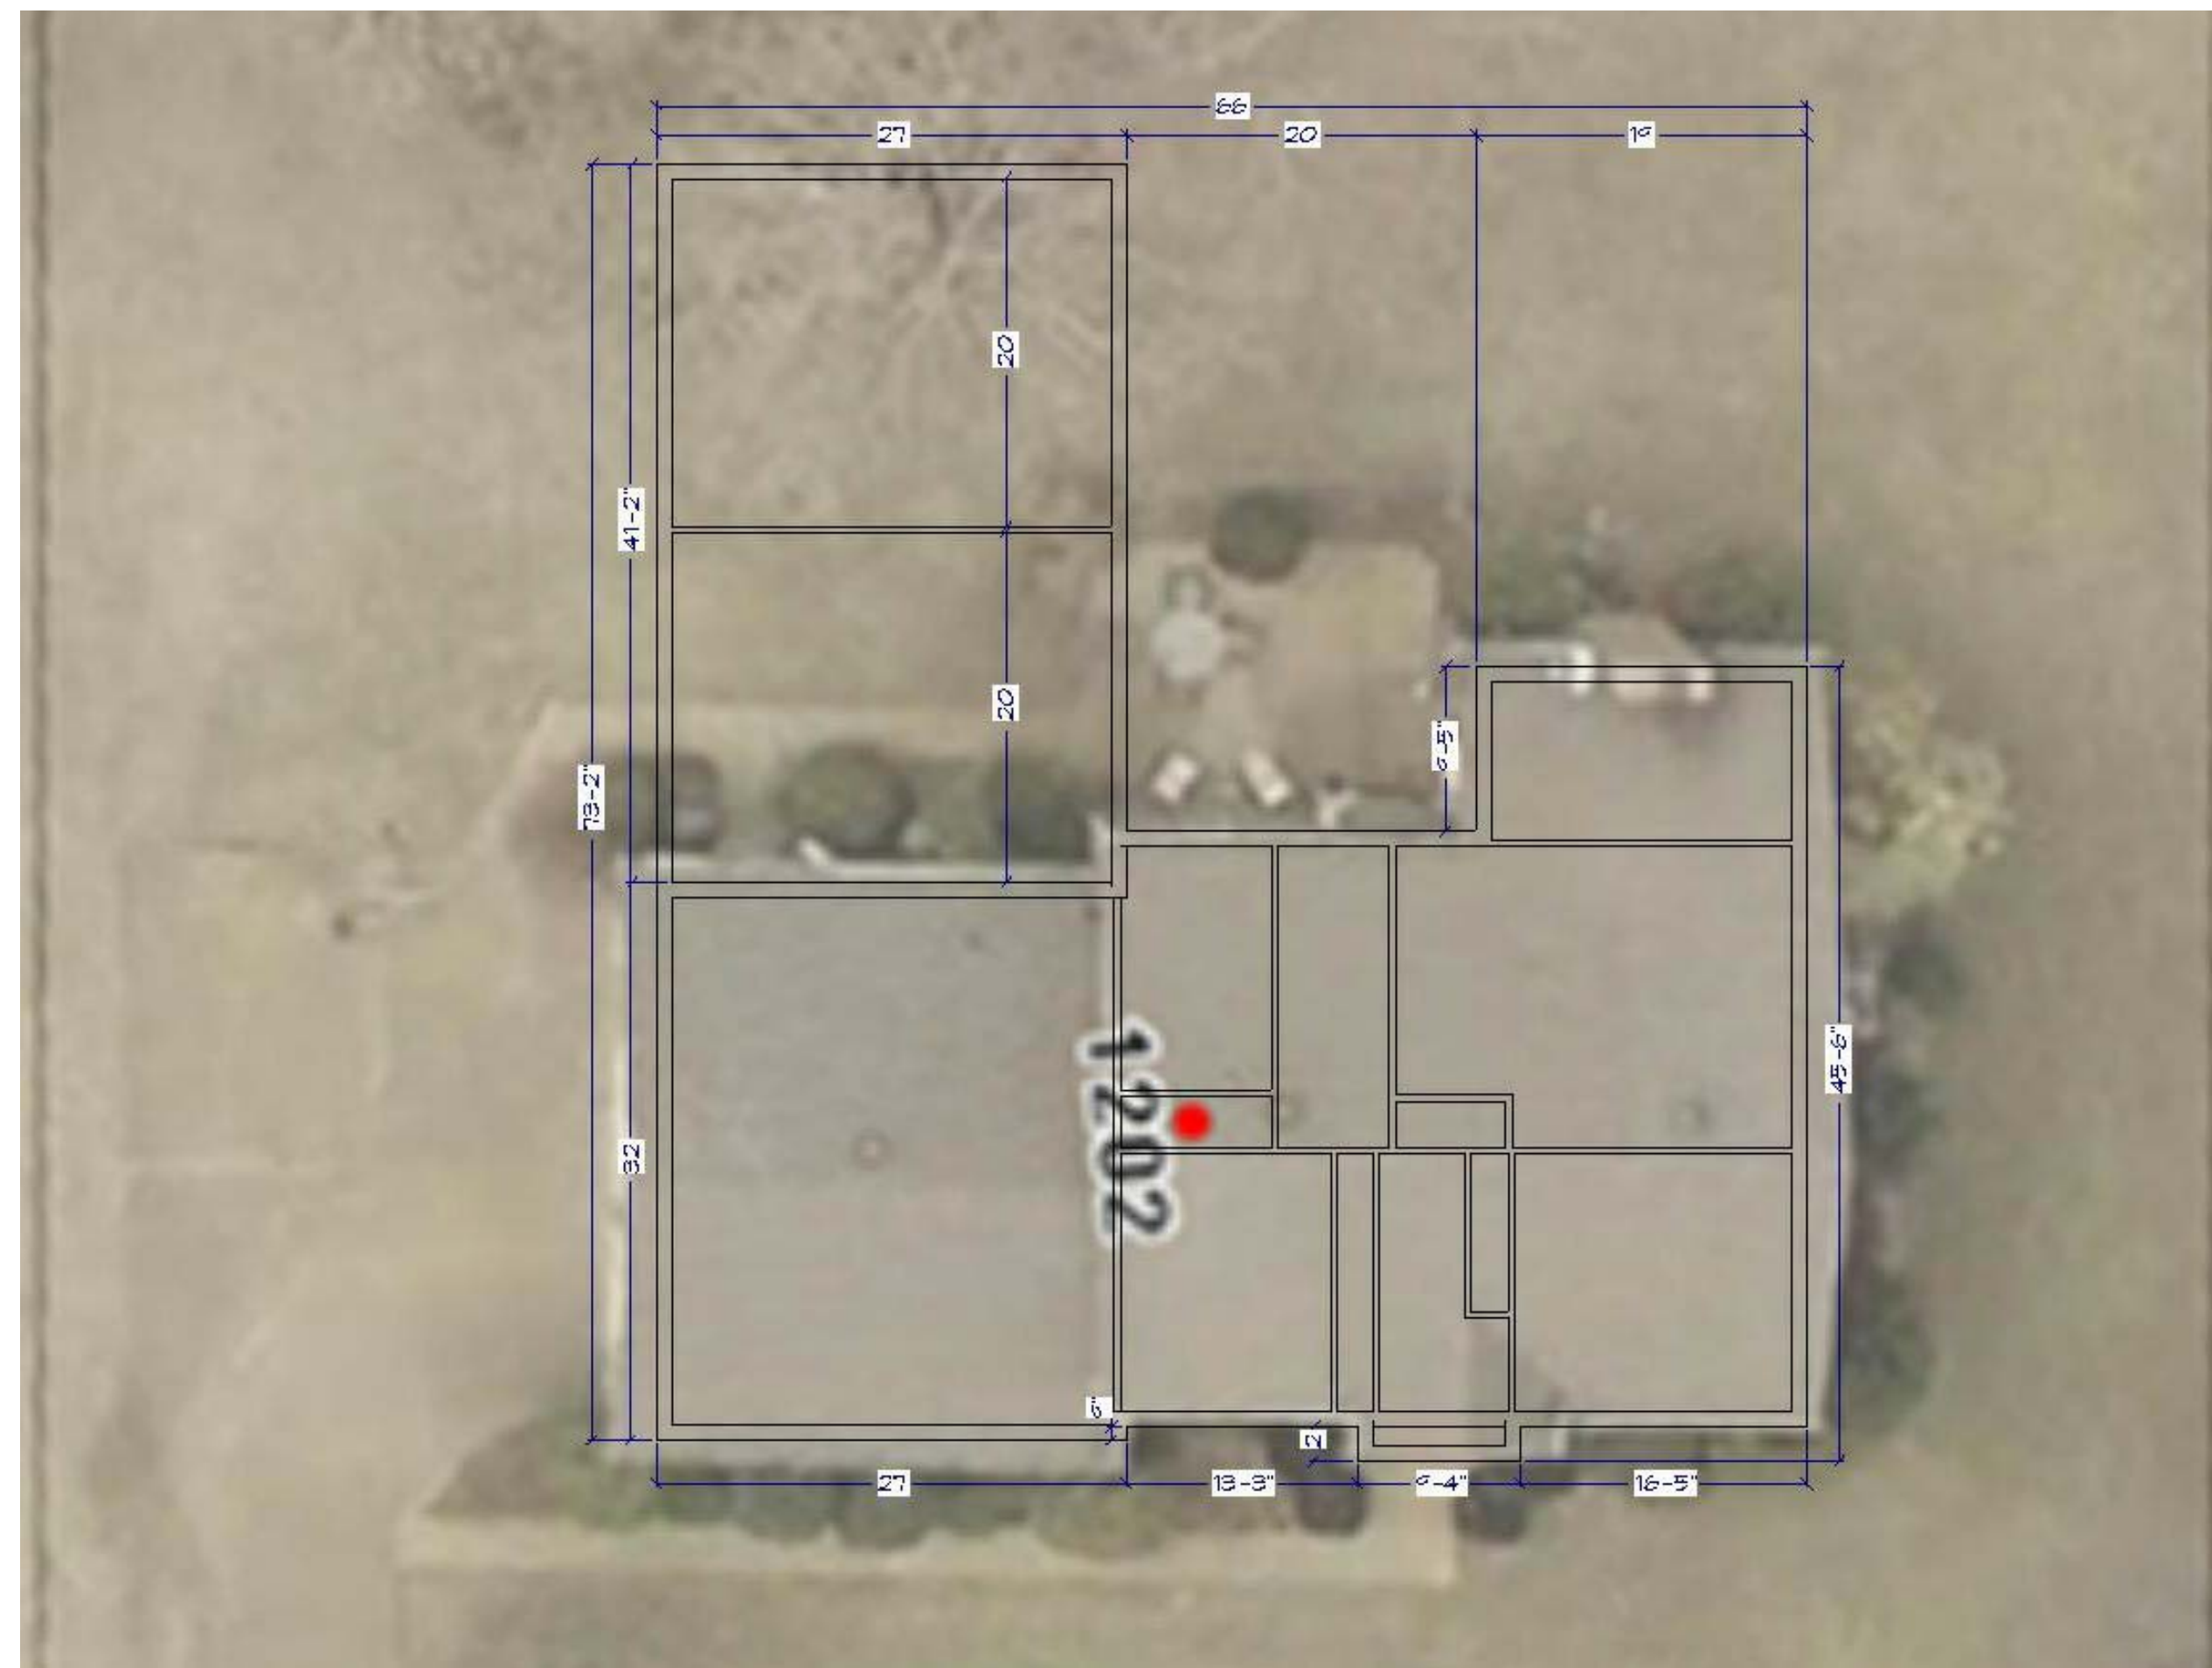

# SITE PLAN

DRAWING:	
DESIGNED BY:	D HAYDEN
DRAWN BY:	D HAYDEN
CHECKED BY:	
FILE NAME	

DATE:
7/23/2018

SCALE:

$$1/20'' = 1'$$

SHEET:  
P-18

[illegible]

Disclaimer: Measurements are approximate and are for illustrative purposes only. While we do not doubt the plans accuracy, we make no guarantee, warranty or representation as to the accuracy and completeness of the floor plan. You or your advisors should conduct a careful, independent investigation of the property to determine to your satisfaction as to the suitability of the property for your space requirements.

1461 BATTLEGROUND DRIVE  
MURFREESBORO, TN 37129  
(615) 269-3906



FRAMING SCHEDULE						
NUMBER	NAME	QTY	NOMINAL	LENGTH	MATERIAL	TYPE
T01	HEADER	2	2X10	77"	FIR STUD 16" OC	LUMBER
T02	HEADER	2	2X12	111 1/8"	FIR STUD 24" OC	LUMBER
T03	HEADER	2	2X12	114 3/4"	FIR STUD 24" OC	LUMBER
T04	HEADER	4	2X4	28"	FIR STUD 24" OC	LUMBER
T05	HEADER	8	2X6	28"	FIR STUD 24" OC	LUMBER
T06	HEADER	2	2X6	30 9/16"	FIR STUD 16" OC	LUMBER
T07	HEADER	4	2X6	30"	FIR STUD 24" OC	LUMBER
T08	HEADER	2	2X6	32 1/16"	FIR STUD 24" OC	LUMBER
T09	HEADER	18	2X6	32"	FIR STUD 24" OC	LUMBER
T10	HEADER	2	2X6	33"	FIR STUD 24" OC	LUMBER
T11	HEADER	4	2X6	35"	FIR STUD 16" OC	LUMBER
T12	HEADER	2	2X6	37"	FIR STUD 16" OC	LUMBER
T13	HEADER	4	2X6	37"	FIR STUD 24" OC	LUMBER
T14	HEADER	2	2X6	41"	FIR STUD 16" OC	LUMBER
T15	HEADER	6	2X6	41"	FIR STUD 24" OC	LUMBER
T16	HEADER	2	2X6	42"	FIR STUD 16" OC	LUMBER
T17	HEADER	2	2X6	42"	FIR STUD 24" OC	LUMBER
T18	HEADER	2	2X6	43"	FIR STUD 16" OC	LUMBER
T19	HEADER	2	2X6	44 1/8"	FIR STUD 16" OC	LUMBER
T20	HEADER	2	2X6	46 1/4"	FIR STUD 24" OC	LUMBER
T21	HEADER	2	2X6	48 1/2"	FIR STUD 24" OC	LUMBER
T22	HEADER	8	2X8	53"	FIR STUD 16" OC	LUMBER
T23	HEADER	2	2X8	57 13/16"	FIR STUD 16" OC	LUMBER
T24	HEADER	2	2X8	61"	FIR STUD 16" OC	LUMBER
T25	HEADER	2	2X8	64 11/16"	FIR STUD 24" OC	LUMBER
T26	HEADER	2	2X8	64 5/16"	FIR STUD 24" OC	LUMBER
T27	HEADER	2	2X8	64"	FIR STUD 24" OC	LUMBER
T28	HEADER	2	2X8	65"	FIR STUD 16" OC	LUMBER
T29	HEADER	2	2X8	73"	FIR STUD 24" OC	LUMBER

CABINET SCHEDULE										
NUMBER	LABEL	QTY	FLOOR	WIDTH	DEPTH	HEIGHT	DESCRIPTION	CODE	MANUFACTURER	COMMENTS
C04		1	1	27 "	24 "	36 "	BASE CABINET			
C07	4DB1921	1	1	18 7/8 "	21 "	36 "	BASE CABINET			
C13	DCW2442R	1	1	24 "	24 "	42 "	CORNER WALL CABINET			
C14	B1821L	1	1	18 "	21 "	36 "	BASE CABINET			
C15	9B3418	1	1	34 5/16 "	18 "	36 "	BASE CABINET			
C17	9B2721	1	1	27 "	21 "	36 "	BASE CABINET			
C22		1	1	12 "	12 "	42 "	WALL CABINET			
C23		1	1	34 3/8 "	12 "	26 1/2 "	WALL CABINET			
C24		1	1	33 "	12 "	42 "	WALL CABINET			
C25		1	1	39 "	24 "	21 "	WALL CABINET			
C26		1	1	36 "	36 "	36 "	CORNER BASE CABINET			
C27	B2412R	1	1	24 "	11 11/16 "	36 "	BASE CABINET			
C28	BCB6	1	1	6 "	24 "	36 "	BASE CABINET			
C30	BCB44R	1	1	43 9/16 "	24 "	36 "	BASE CABINET			
C31	DCW2442L	1	1	24 "	24 "	42 "	CORNER WALL CABINET			
C32	W642	1	1	6 "	12 "	42 "	WALL CABINET			
C33		1	1	15 "	12 "	42 "	WALL CABINET			
C34	B2412R	1	1	24 "	12 "	36 "	BASE CABINET			

DOOR SCHEDULE										
NUMBER	LABEL	QTY	FLOOR	WIDTH	HEIGHT	R/O	DESCRIPTION	TEMPERED	U-FACTOR	SHGC
D01	4568	1	1	52 13/16 "	80 "	54 13/16"X82 1/2"	4 DR. BIFOLD-LOUVERED		0.3	0.3
D02	3068	2	1	36 "	80 "	38"X82 1/2"	HINGED-PANEL		0.3	0.3
D03	2668	2	1	30 "	80 "	32"X82 1/2"	HINGED-PANEL		0.3	0.3
D04	3368	1	1	39 1/8 "	80 "	41 1/8"X82 1/2"	HINGED-PANEL		0.3	0.3
D05	3868	1	1	43 3/4 "	80 "	45 3/4"X82 1/2"	4 DR. BIFOLD-LOUVERED		0.3	0.3
D06	3068	3	1	36 "	80 "	38"X83"	EXT. HINGED-GLASS PANEL		0.3	0.3
D07	4068	1	2	48 "	80 "	50"X82 1/2"	4 DR. BIFOLD-LOUVERED		0.3	0.3
D08	41168	1	1	59 5/16 "	80 "	61 5/16"X83"	EXT. DOUBLE HINGED-GLASS PANEL		0.3	0.3
D09	3368	1	1	38 11/16 "	80 "	40 11/16"X82 1/2"	4 DR. BIFOLD-LOUVERED		0.3	0.3
D10	4068	1	1	48 "	80 "	50"X82 1/2"	4 DR. BIFOLD-LOUVERED		0.3	0.3
D11	4868	1	1	56 "	80 "	58"X82 1/2"	DOUBLE HINGED-PANEL		0.3	0.3
D12	81170	1	1	106 3/4 "	84 "	108 3/4"X87"	GARAGE-GARAGE DOOR P02		0.3	0.3
D13	8770	1	1	103 1/8 "	84 "	105 1/8"X87"	GARAGE-GARAGE DOOR P02		0.3	0.3
D14	5068	1	1	59 11/16 "	80 "	61 11/16"X83"	EXT. DOUBLE HINGED-GLASS PANEL		0.3	0.3

ELECTRICAL SCHEDULE								
NUMBER	QTY	FLOOR	WIDTH	DEPTH	HEIGHT	ATTACHED TO	DESCRIPTION	NUMBER
E01	8	1	3 "	5/16 "	5 "	WALL	GFCI	E01
E02	1	1	12 "	18 "	1 1/4 "	CEILING	EXHAUST (LIGHT, HEAT LAMP)	E02
E03	4	1	13 1/16 "	13 1/8 "	33 1/4 "	FLOOR	LONG-NECK LAMP	E03
E05	1	1	17 9/16 "	17 9/16 "	34 7/8 "	CEILING	DOVER PENDANT	E05
E06	1	1	24 "	5 1/8 "	6 1/2 "	WALL	BRYANT SCONCE 3	E06
E07	11	1	3 "	3/4 "	5 "	WALL	SINGLE POLE	E07
E08	17	1	3 "	5/16 "	5 "	WALL	DUPLEX	E08
E11	1	1	5 "	3/4 "	5 "	WALL	2 GANG SWITCH	E11
E12	3	1	52 "	52 "	15 "	CEILING	BASIC CEILING FAN	E12
E13	2	1	12 1/16 "	12 1/16 "	5 1/2 "	CEILING	COMMON FLUSH MOUNT	E13
E15	1	2	45 13/16 "	18 3/4 "	72 "	FLOOR	ARC LAMP	E15

REVISION TABLE					
NUMBER	DATE	REVISED BY	DESCRIPTION		

--

--

DRAWING:	DESIGNED BY: D HAYDEN
	DRAWN BY: D HAYDEN
	CHECKED BY:
	FILE NAME

DATE:

7/23/2018

SCALE:

SHEET:

P-19



WINDOW SCHEDULE											
NUMBER	LABEL	QTY	FLOOR	WIDTH	HEIGHT	EGRESS	DESCRIPTION	SHAPE	TEMPERED	SHGC	U-FACTOR
W01	2034DH	4	1	24 "	40 "		DOUBLE HUNG			0.3	0.3
W02	2050DH	2	1	24 "	60 "		DOUBLE HUNG			0.3	0.3
W03	2250DH	2	1	26 "	60 "		DOUBLE HUNG			0.3	0.3
W04	3648DH	1	1	42 1/4 "	55 3/4 "		DOUBLE HUNG			0.3	0.3
W05	2429DH	1	2	28 1/16 "	32 9/16 "		DOUBLE HUNG			0.3	0.3
W06	24310DH	5	2	28 "	46 "		DOUBLE HUNG			0.3	0.3
W07	50411RS	1	2	60 "	59 7/16 "		RIGHT SLIDING			0.3	0.3
W08	2467DH	4	1	28 "	79 "		DOUBLE HUNG			0.3	0.3
W09	2529DH	1	2	29 "	32 9/16 "		DOUBLE HUNG			0.3	0.3
W10	2967DH	4	1	33 "	79 "		DOUBLE HUNG			0.3	0.3
W11	3250DH	1	1	38 "	60 "		DOUBLE HUNG			0.3	0.3

ROOM FINISH SCHEDULE							
ROOM NAME	AREA, INTERIOR (SQ FT)	CEILING HEIGHT	WALL MATERIAL	FLOOR FINISH	CEILING FINISH	BASE MOLDING	WINDOW CASING
BATH	3	97 1/2"	DRYWALL	LIMESTONE TILES, THINSET MORTAR	DRYWALL, COLOR - BONE		
HALL	102	97 1/2"	DRYWALL	LIGHT - MP PLANK, THINSET MORTAR	DRYWALL, COLOR - BONE	CA-66	STOCK
BEDROOM	120	97 1/2"	DRYWALL	LIGHT - MP PLANK, THINSET MORTAR	DRYWALL, COLOR - BONE	CA-66	STOCK
CLOSET	5	118 1/2"	DRYWALL	LIGHT - MP PLANK, FOAM UNDERLAYMENT	DRYWALL, COLOR - BONE	CA-66	STOCK
DINING	142	109 1/2"	DRYWALL	LIGHT - MP PLANK, FOAM UNDERLAYMENT	DRYWALL, COLOR - BONE	CA-66	STOCK
ENTRY	10	118 1/2"	DRYWALL	LIGHT - MP PLANK, FOAM UNDERLAYMENT	DRYWALL, COLOR - BONE	CA-66	STOCK
ENTRY	34	152 1/8"	DRYWALL, FIRE RATED DRYWALL	LIMESTONE TILES, FOAM UNDERLAYMENT	DRYWALL, COLOR - BONE	CA-66	STOCK
ENTRY	155	118 1/2", 131 1/8"	DRYWALL	LIGHT - MP PLANK, FOAM UNDERLAYMENT	DRYWALL, COLOR - BONE	CA-66	STOCK
FAMILY	143	109 1/2", 118 1/2"	DRYWALL	LIGHT - MP PLANK, FOAM UNDERLAYMENT	DRYWALL, COLOR - BONE	CA-66	STOCK
LIVING	11	97 1/2"	DRYWALL	LIGHT - MP PLANK, THINSET MORTAR	DRYWALL, COLOR - BONE	CA-66	STOCK
CLOSET	7	97 1/2"	DRYWALL	LIGHT - MP PLANK, THINSET MORTAR	DRYWALL, COLOR - BONE	CA-66	STOCK
KITCHEN	93	97 1/2"	DRYWALL	LIGHT - MP PLANK, THINSET MORTAR	DRYWALL, COLOR - BONE	CA-66	STOCK
KITCHEN	169	109 1/2", 139 1/2"	DRYWALL	LIMESTONE TILES, THINSET MORTAR	DRYWALL, COLOR - BONE	CA-66	STOCK
CL.	10	97 1/2"	DRYWALL	CARPET-B4, THINSET MORTAR	DRYWALL, COLOR - BONE	CA-66	STOCK
KITCHEN	93	109 1/2", 118 1/2", 139 1/2"	DRYWALL	LIMESTONE TILES, THINSET MORTAR	DRYWALL, COLOR - BONE	CA-66	STOCK
CLOSET	11	97 1/2"	DRYWALL	LIGHT - MP PLANK, FOAM UNDERLAYMENT	DRYWALL, COLOR - BONE	CA-66	STOCK
LIVING	252	N/A	DRYWALL	LIGHT - MP PLANK, THINSET MORTAR	DRYWALL, COLOR - BONE	CA-66	STOCK
LIVING	219	118 1/2"	DRYWALL	LIGHT - MP PLANK, FOAM UNDERLAYMENT	DRYWALL, COLOR - BONE	CA-66	STOCK
MASTER BDRM	156	97 1/2"	DRYWALL	CARPET-B4, THINSET MORTAR	DRYWALL, COLOR - BONE	CA-66	STOCK
NOOK	1	118 1/2", 152 1/8"	DRYWALL	LIGHT - MP PLANK, FOAM UNDERLAYMENT	DRYWALL, COLOR - BONE	CA-66	
NOOK	186	152 1/8"	DRYWALL, RED5 BRICK	LIGHT - MP PLANK, FOAM UNDERLAYMENT	DRYWALL, COLOR - BONE	CA-66	STOCK
OPEN PORCH	386	N/A	CC-50 WHITE DOWN, RED5 BRICK		DRYWALL, COLOR - BONE		STOCK
PANTRY	5	152 1/8"	DRYWALL	LIGHT - MP PLANK, FOAM UNDERLAYMENT	DRYWALL, COLOR - BONE	CA-66	
ENTRY	82	152 1/8"	DRYWALL, FIRE RATED DRYWALL	LIMESTONE TILES, FOAM UNDERLAYMENT	DRYWALL, COLOR - BONE	CA-66	STOCK
UTILITY	30	89 1/8"	DRYWALL, FIRE RATED DRYWALL	LIMESTONE TILES, THINSET MORTAR	DRYWALL, COLOR - BONE	CA-66	STOCK
L	88	97 1/2"	DRYWALL	LIMESTONE TILES, FOAM UNDERLAYMENT	DRYWALL, COLOR - BONE		STOCK
CL.	16	97 1/2"	DRYWALL	CARPET-B4, THINSET MORTAR	DRYWALL, COLOR - BONE	CA-66	STOCK
ENTRY	22	152 1/8"	DRYWALL	LIMESTONE TILES, FOAM UNDERLAYMENT	DRYWALL, COLOR - BONE	CA-66	
TOTALS:	2651						

FIXTURE SCHEDULE							
NUMBER	LABEL	QTY	FLOOR	WIDTH	DEPTH	HEIGHT	DESCRIPTION
A01	ADA TOILET	2	1	30 "	36 "	29 7/8 "	ADA TOILET
A02	DECK MOUNTED SINGLE HANDLE KITCHEN FAUCET	1	1	4 5/8 "	10 15/16 "	15 3/16 "	DECK MOUNTED SINGLE HANDLE KITCHEN FAUCET
A03	DRYER (CURVED)	1	1	27 "	33 3/16 "	38 "	DRYER (CURVED)
A04	FREEZER ON TOP	1	1	36 "	25 "	72 "	FREEZER ON TOP
A05	GAS (W/ LEGS)	1	1	29 7/8 "	26 1/2 "	40 "	GAS (W/ LEGS)
A06	JDB9600CWS	1	1	23 3/8 "	22 "	30 7/16 "	JDB9600CWS
A07	K-11076-4	1	1	13 3/16 "	5 3/8 "	8 9/16 "	K-11076-4 ARCHER WIDESPREAD BATHROOM SINK FAUCET
A08	K-2355 ARCHER UNDER-MOUNT BATHROOM SINK	1	1	19 "	15 "	7 1/2 "	K-2355 ARCHER UNDER-MOUNT BATHROOM SINK
A09	K-9166	1	1	60 "	31 15/16 "	4 1/2 "	K-9166 BELLWETHER SHOWER BASE
A10	OVAL SINK	1	1	20 13/16 "	17 9/16 "	10 1/4 "	OVAL SINK
A11	PINCH PLEAT CURTAIN	1	1	156 13/16 "	1 "	44 "	PINCH PLEAT CURTAIN
A12	PINCH PLEAT CURTAIN	1	1	70 15/16 "	5 1/16 "	93 "	PINCH PLEAT CURTAIN
A13	VINTAGE SHOWERHEAD	1	1	9 5/8 "	19 3/16 "	54 13/16 "	VINTAGE SHOWERHEAD
A14	VENT HOOD (SMALL)	1	1	34 7/16 "	19 3/4 "	5 1/2 "	VENT HOOD (SMALL)
A15	SINK (19 3/4W)	1	1	19 3/4 "	17 5/8 "	11 "	SINK (19 3/4W)
A16	UNDER CABINET	1	1	23 "	14 "	16 1/2 "	UNDER CABINET
A17	MEDIUM ELEC WH	1	1	23 "	21 "	58 "	MEDIUM ELEC WH
A18	WASHER (CURVED FRONT LOADING)	1	1	27 "	33 3/16 "	38 "	WASHER (CURVED FRONT LOADING)
A19	VERTICAL GRAB BAR	1	1	2 1/4 "	2 1/4 "	14 3/8 "	VERTICAL GRAB BAR

REVISION TABLE		NUMBER	DATE	REVISED BY	DESCRIPTION

DRAWING:  
DESIGNED BY: D HAYDEN  
DRAWN BY: D HAYDEN  
CHECKED BY:  
FILE NAME

DATE:

7/23/2018

SCALE:

SHEET:

P-20