



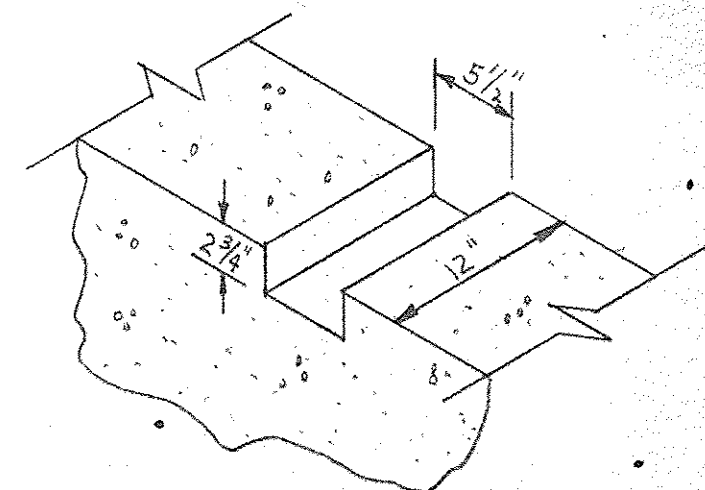

BEAM POCKET DETAIL
SCALE = 1"=1'-0"

Sher

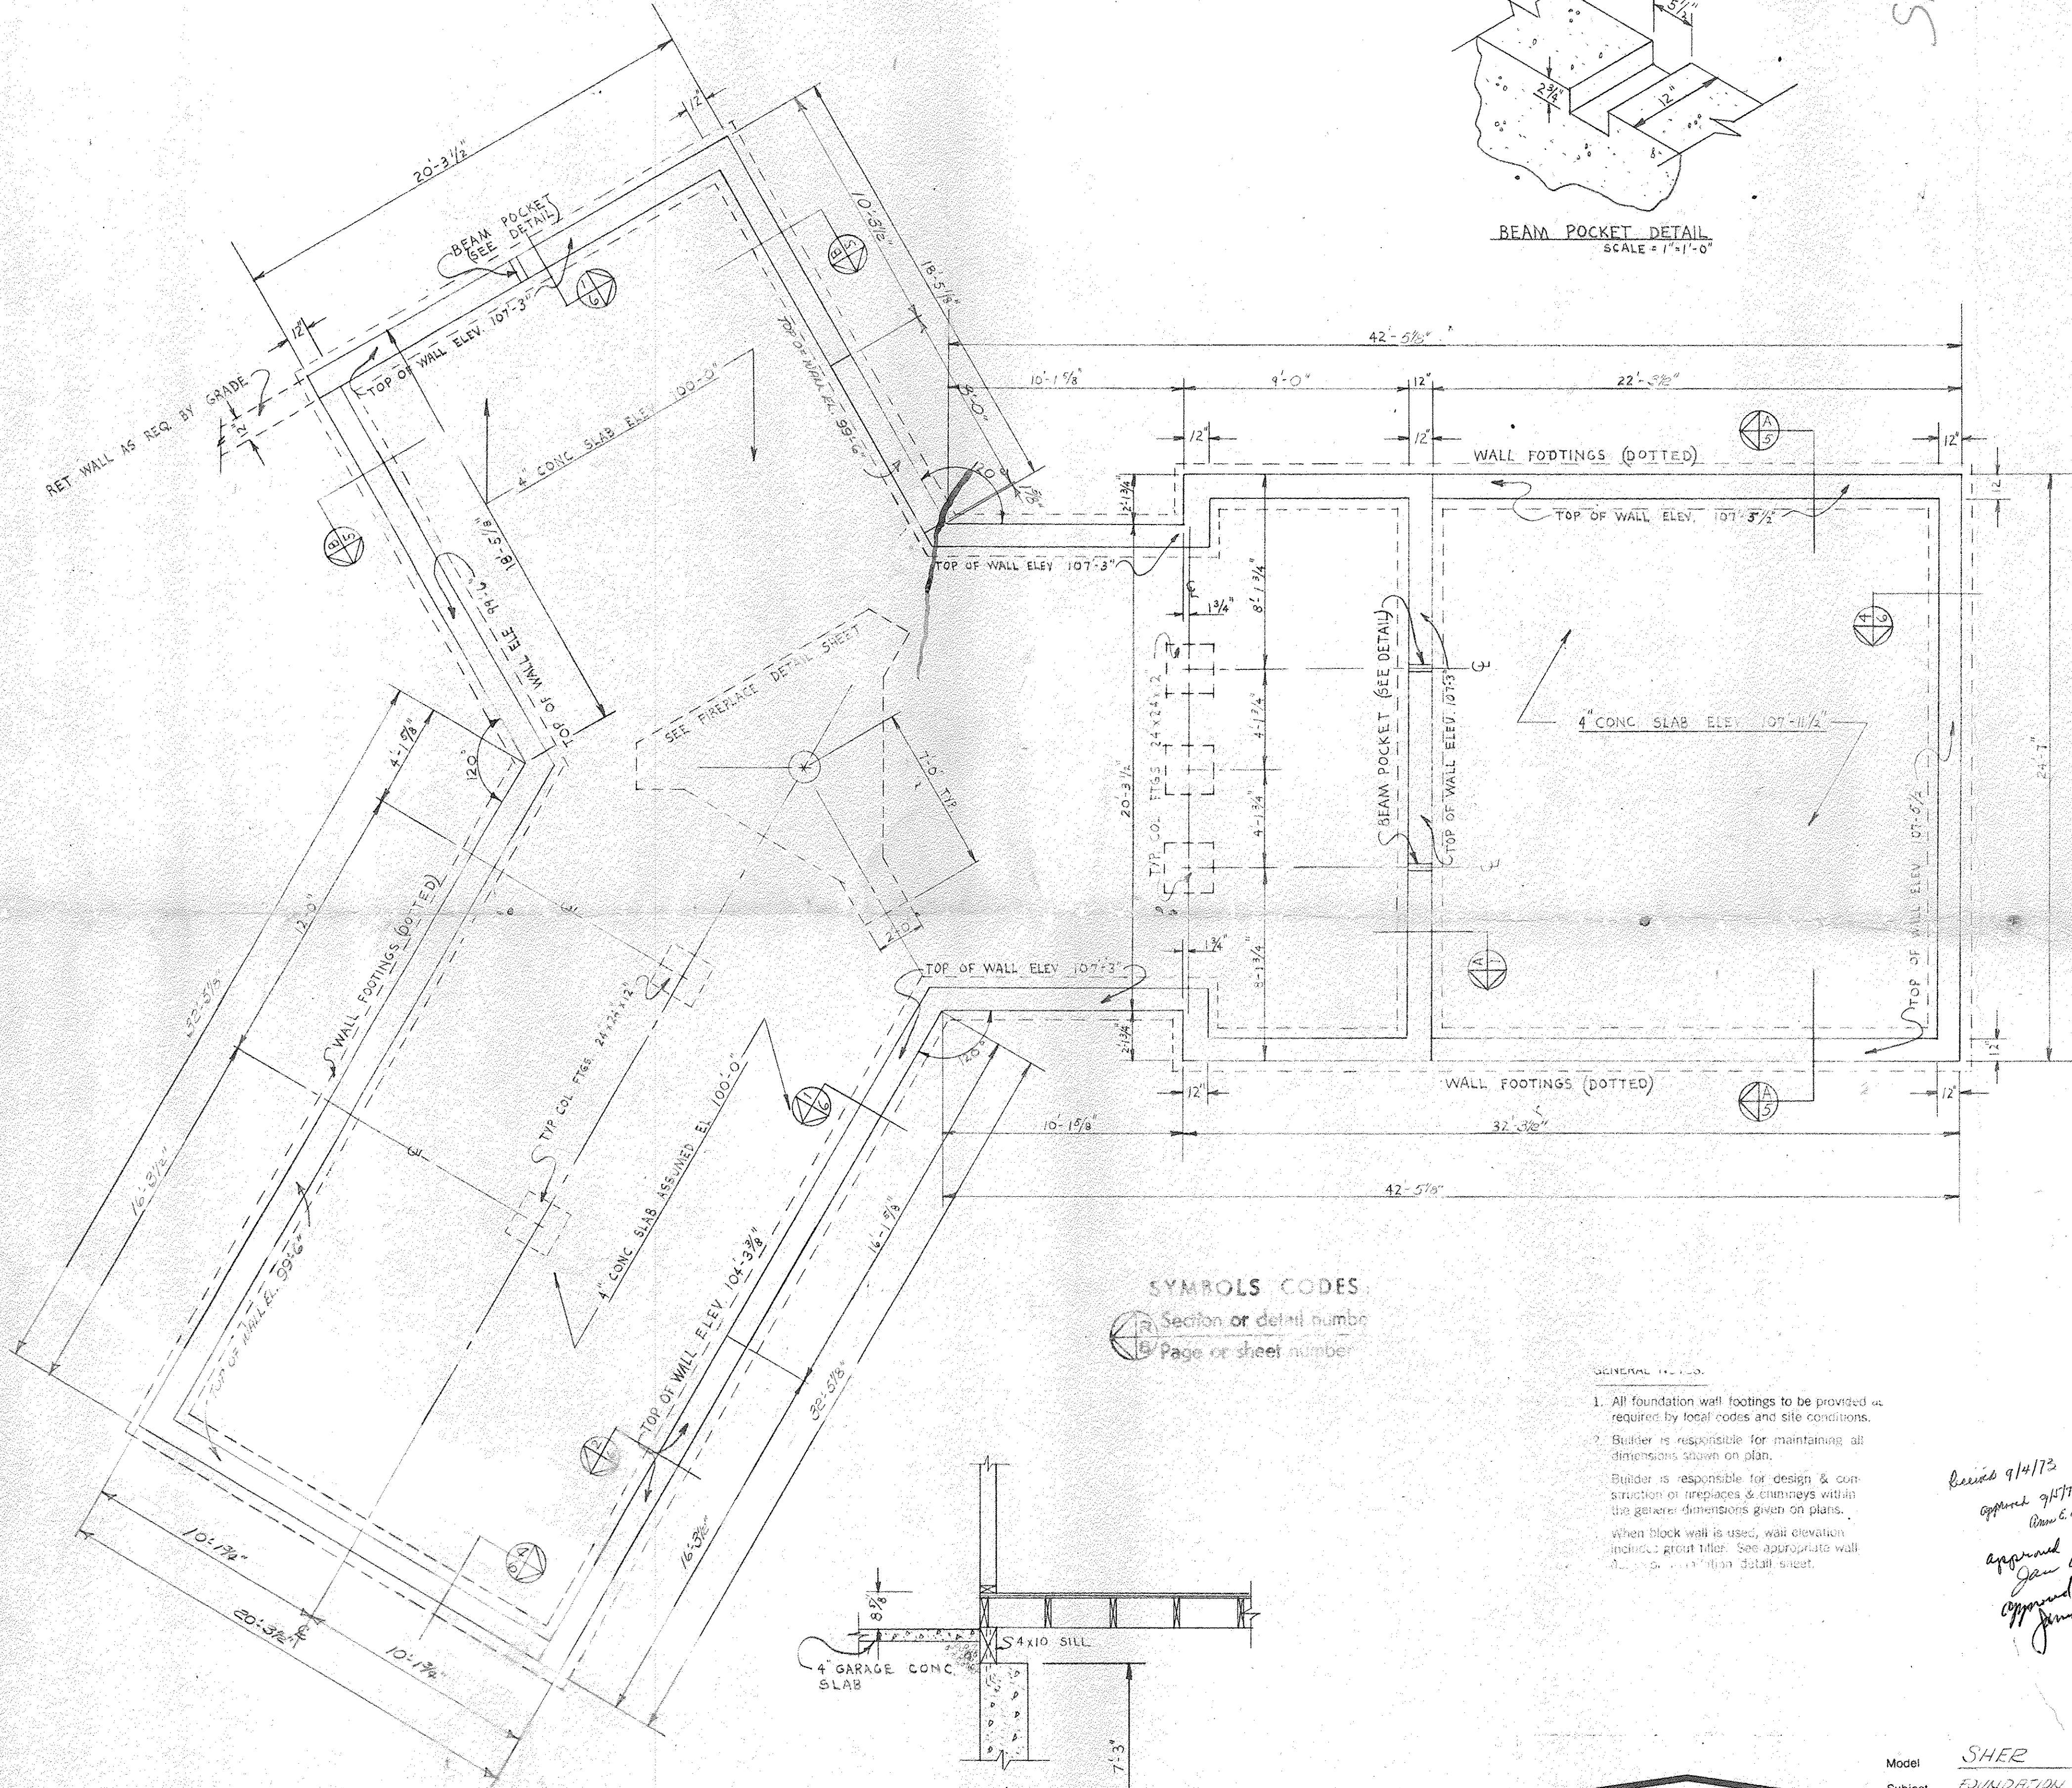


SYMBOLS CODES

- (A) Section or detail number
- (B) Page or sheet number

GENERAL NOTES

1. All foundation wall footings to be provided as required by local codes and site conditions.
2. Builder is responsible for maintaining all dimensions shown on plan.
3. Builder is responsible for design & construction of fireplaces & chimneys within the general dimensions given on plans.
4. When block wall is used, wall elevation includes: gross tiler. See appropriate wall detail & foundation detail sheet.


Revised 9/14/73
 approved 9/17/73
 Ron C. Shuck
 approved 9/18/73
 Jan W. Noble
 approved 9/11/73
 9/11/73

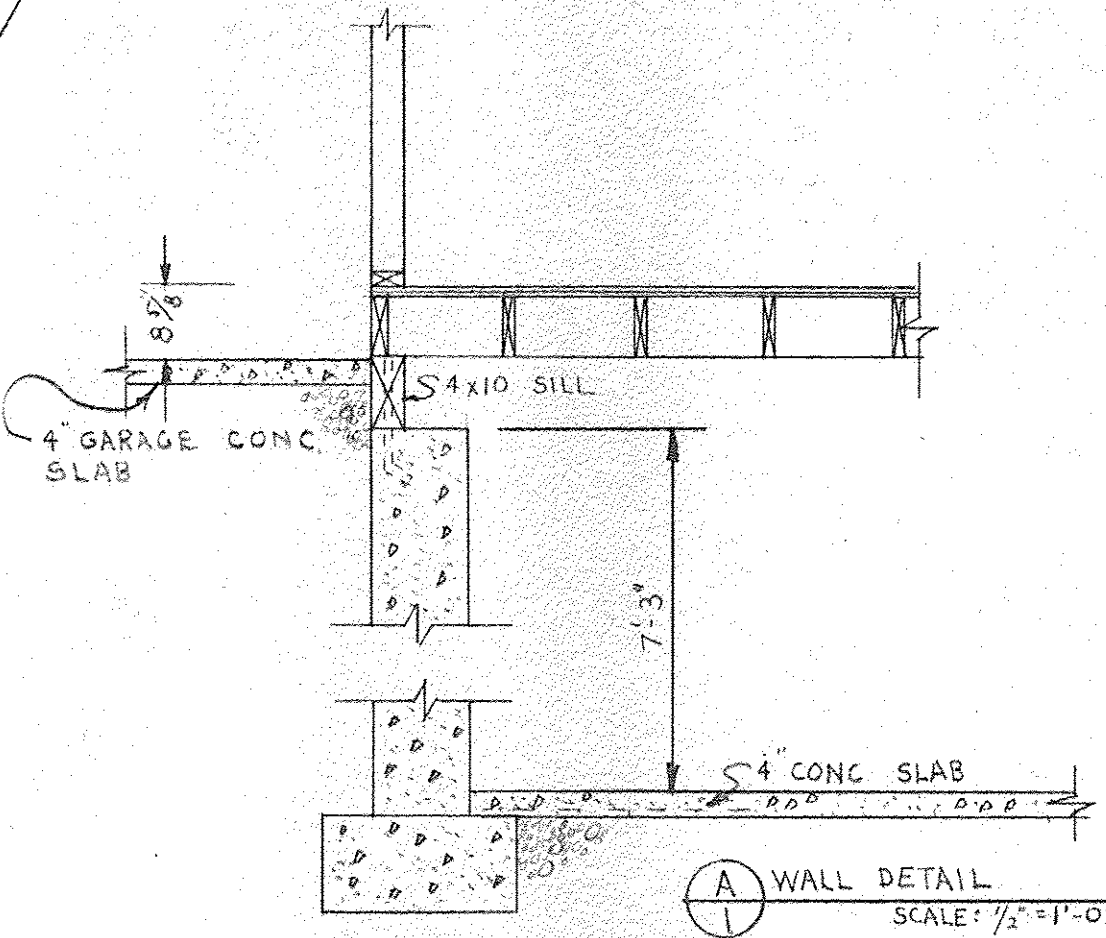

TECHBUILT

585 State Road
 North Dartmouth
 Massachusetts 02747
 617 996 6777

Model	SHER RES.		
Subject	FOUNDATION PLAN		
Drawn by	J.B.	Date	7/25/73
Revision No.		Date	
		Date	
Scale	1/2"=1'-0"	Sheet	1 of 5
Drawing No.			

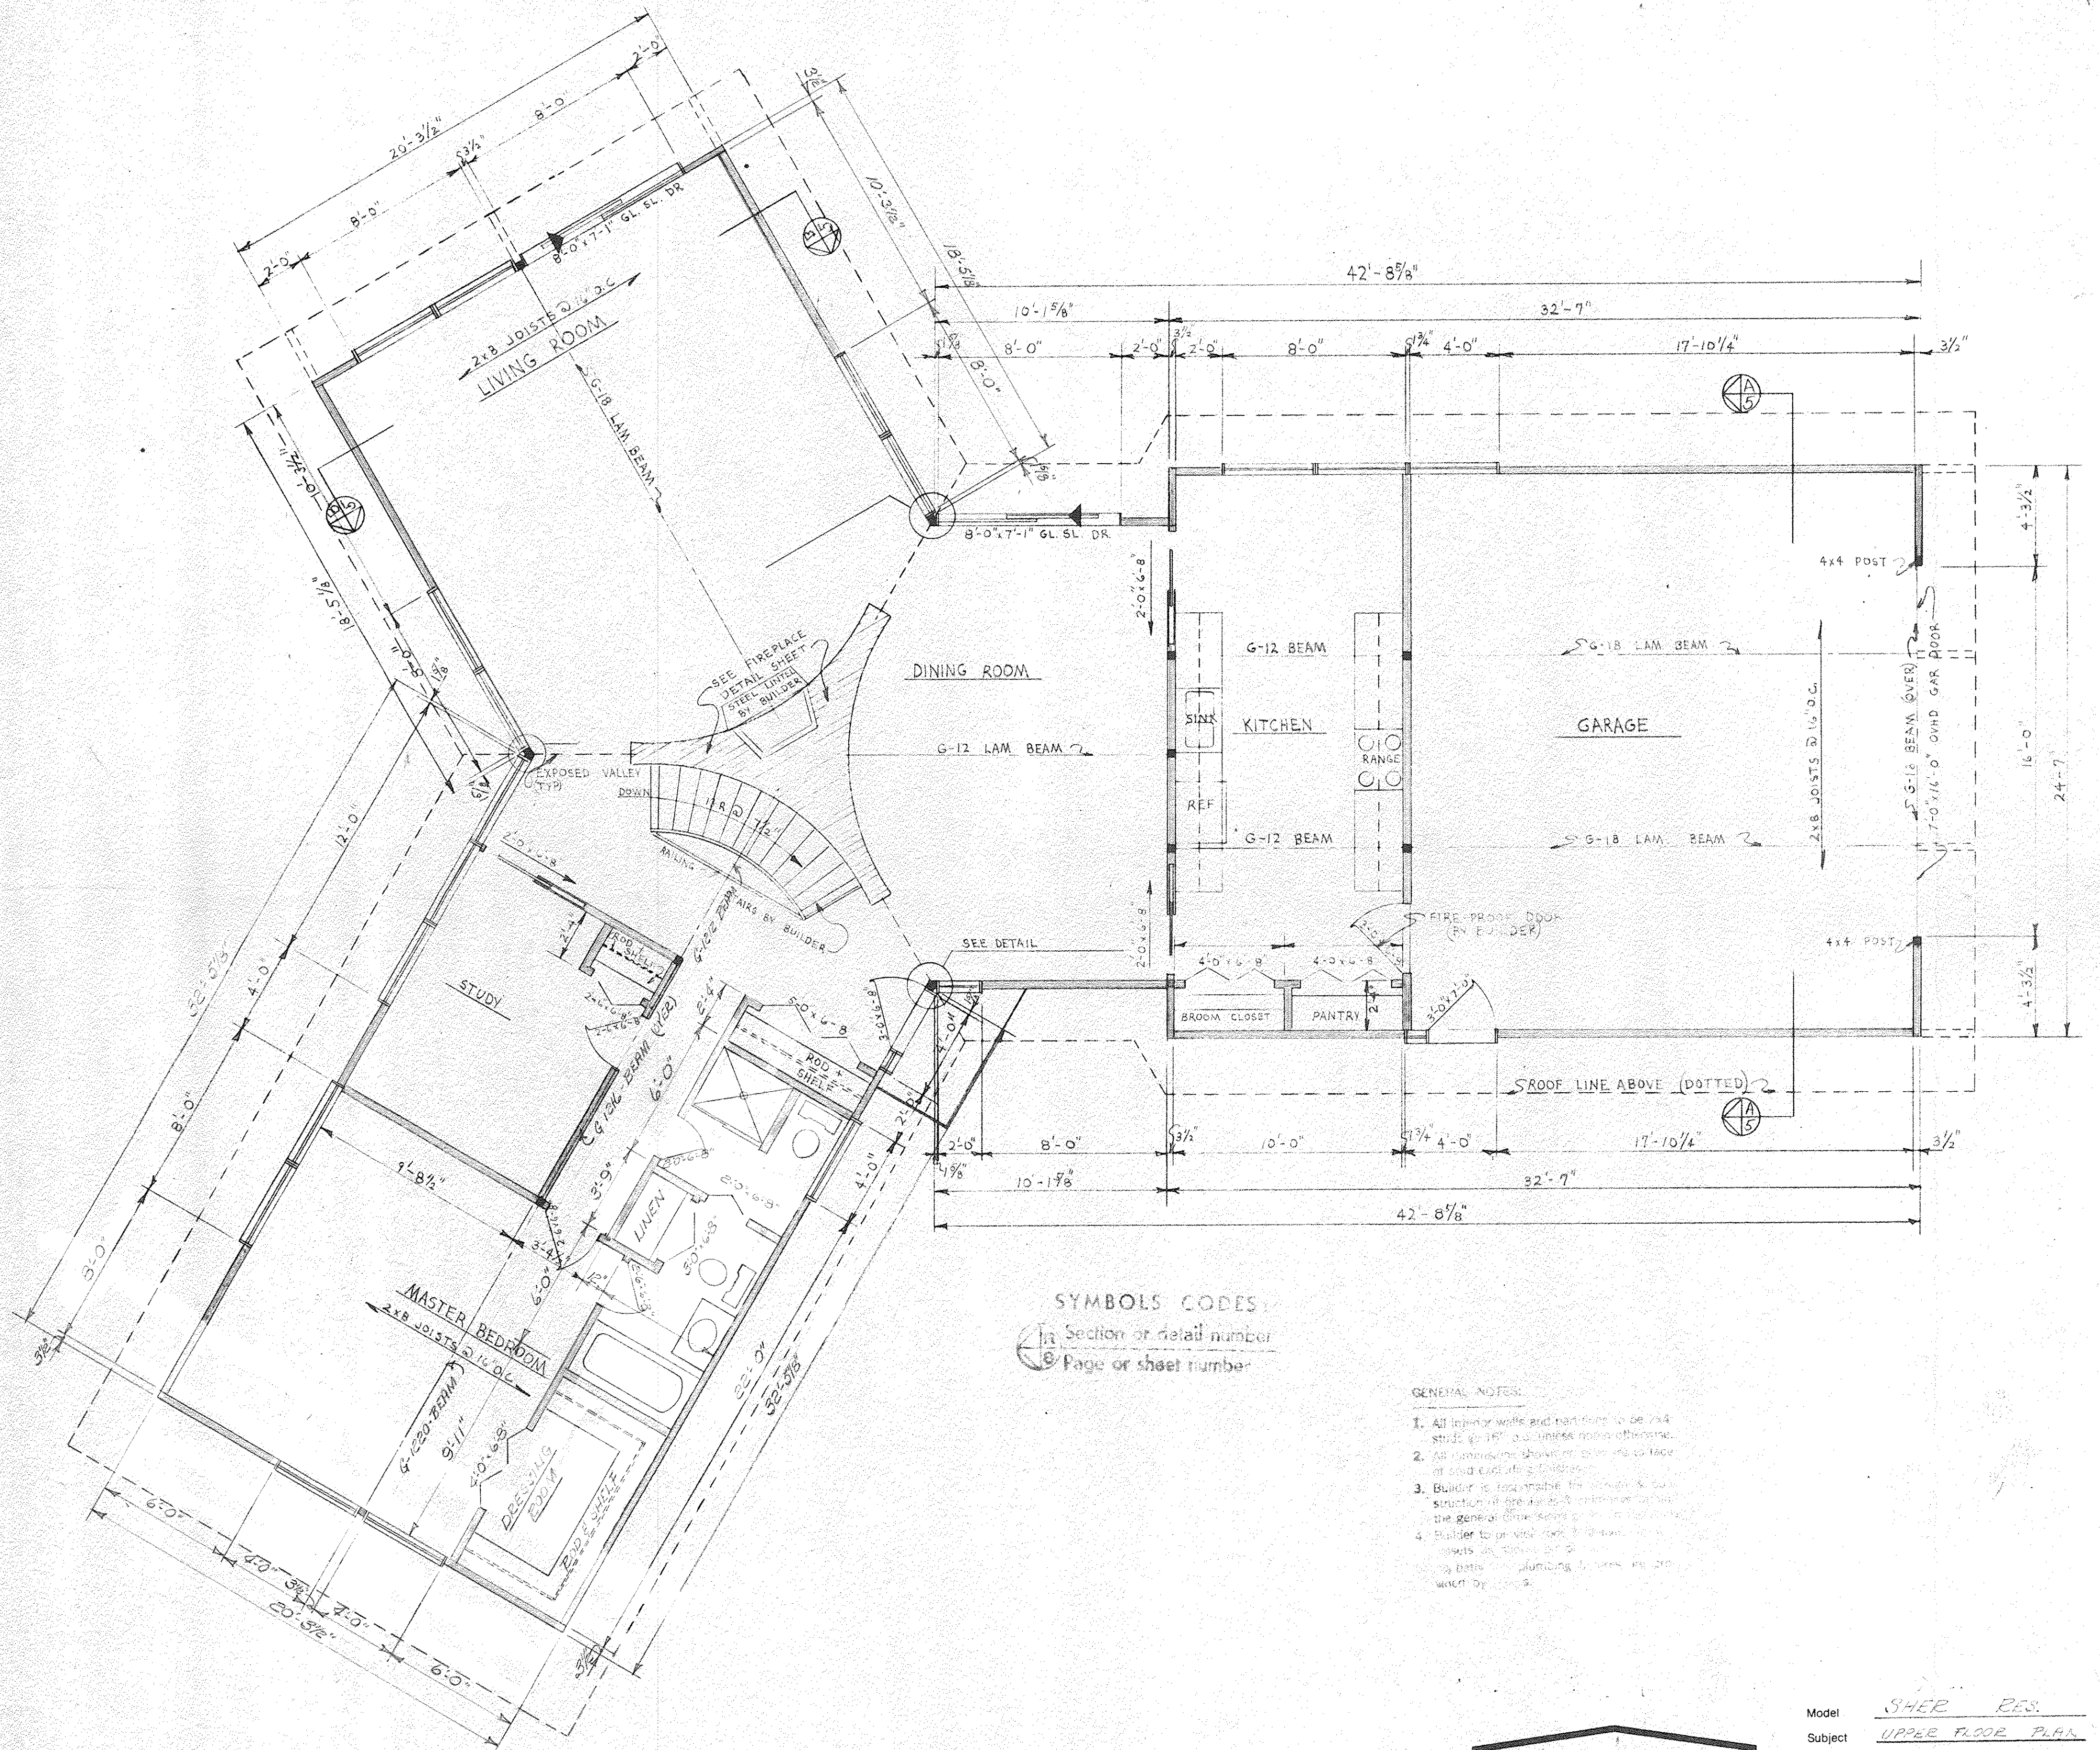

SYMBOLS CODES

- 12 Section or detail number
- 8 Page or sheet number

GENERAL NOTES:

1. All interior walls and partitions to be 2x4 studs @ 16" o.c. unless noted otherwise.
2. All dimensions shown on plans are to face of wall or edge of partition.
3. Builder is responsible for obtaining all necessary permits and for obtaining all necessary approvals from the local building department.
4. Builder to provide code required fire protection for all exits and for all fire alarm systems.




TECHBUILT

585 State Road
North Dartmouth
Massachusetts 02747
617 996 6777

Model	SHER RES.		
Subject	UPPER FLOOR PLAN		
Drawn by	J.B.	Date	7/20/73
Revision No.		Date	
Scale	1/4" = 1'-0"	Sheet	9 of 5
Drawing No.			

COPYRIGHT THESE PLANS MAY NOT BE USED IN ANY WAY WITHOUT WRITTEN PERMISSION FROM THE COPYRIGHT OWNER

657.001 (2/27/75)
P.T.O.

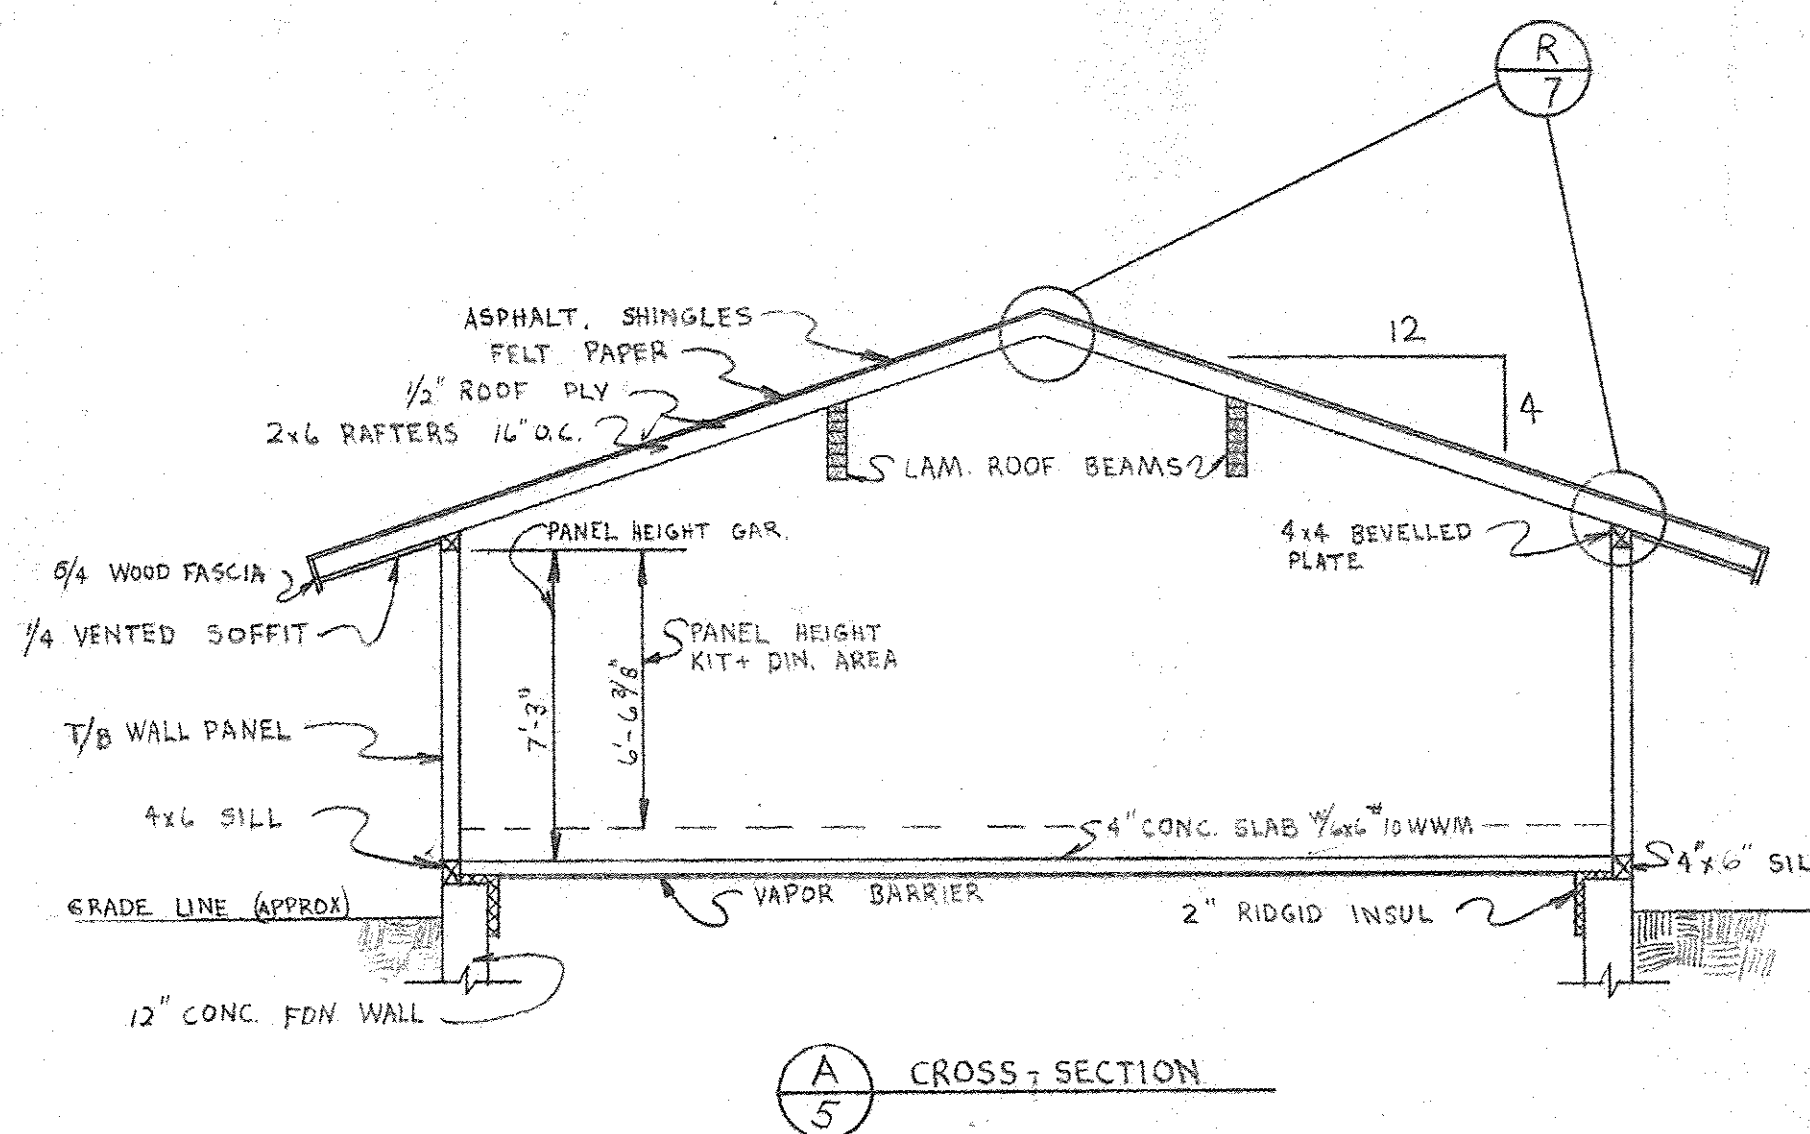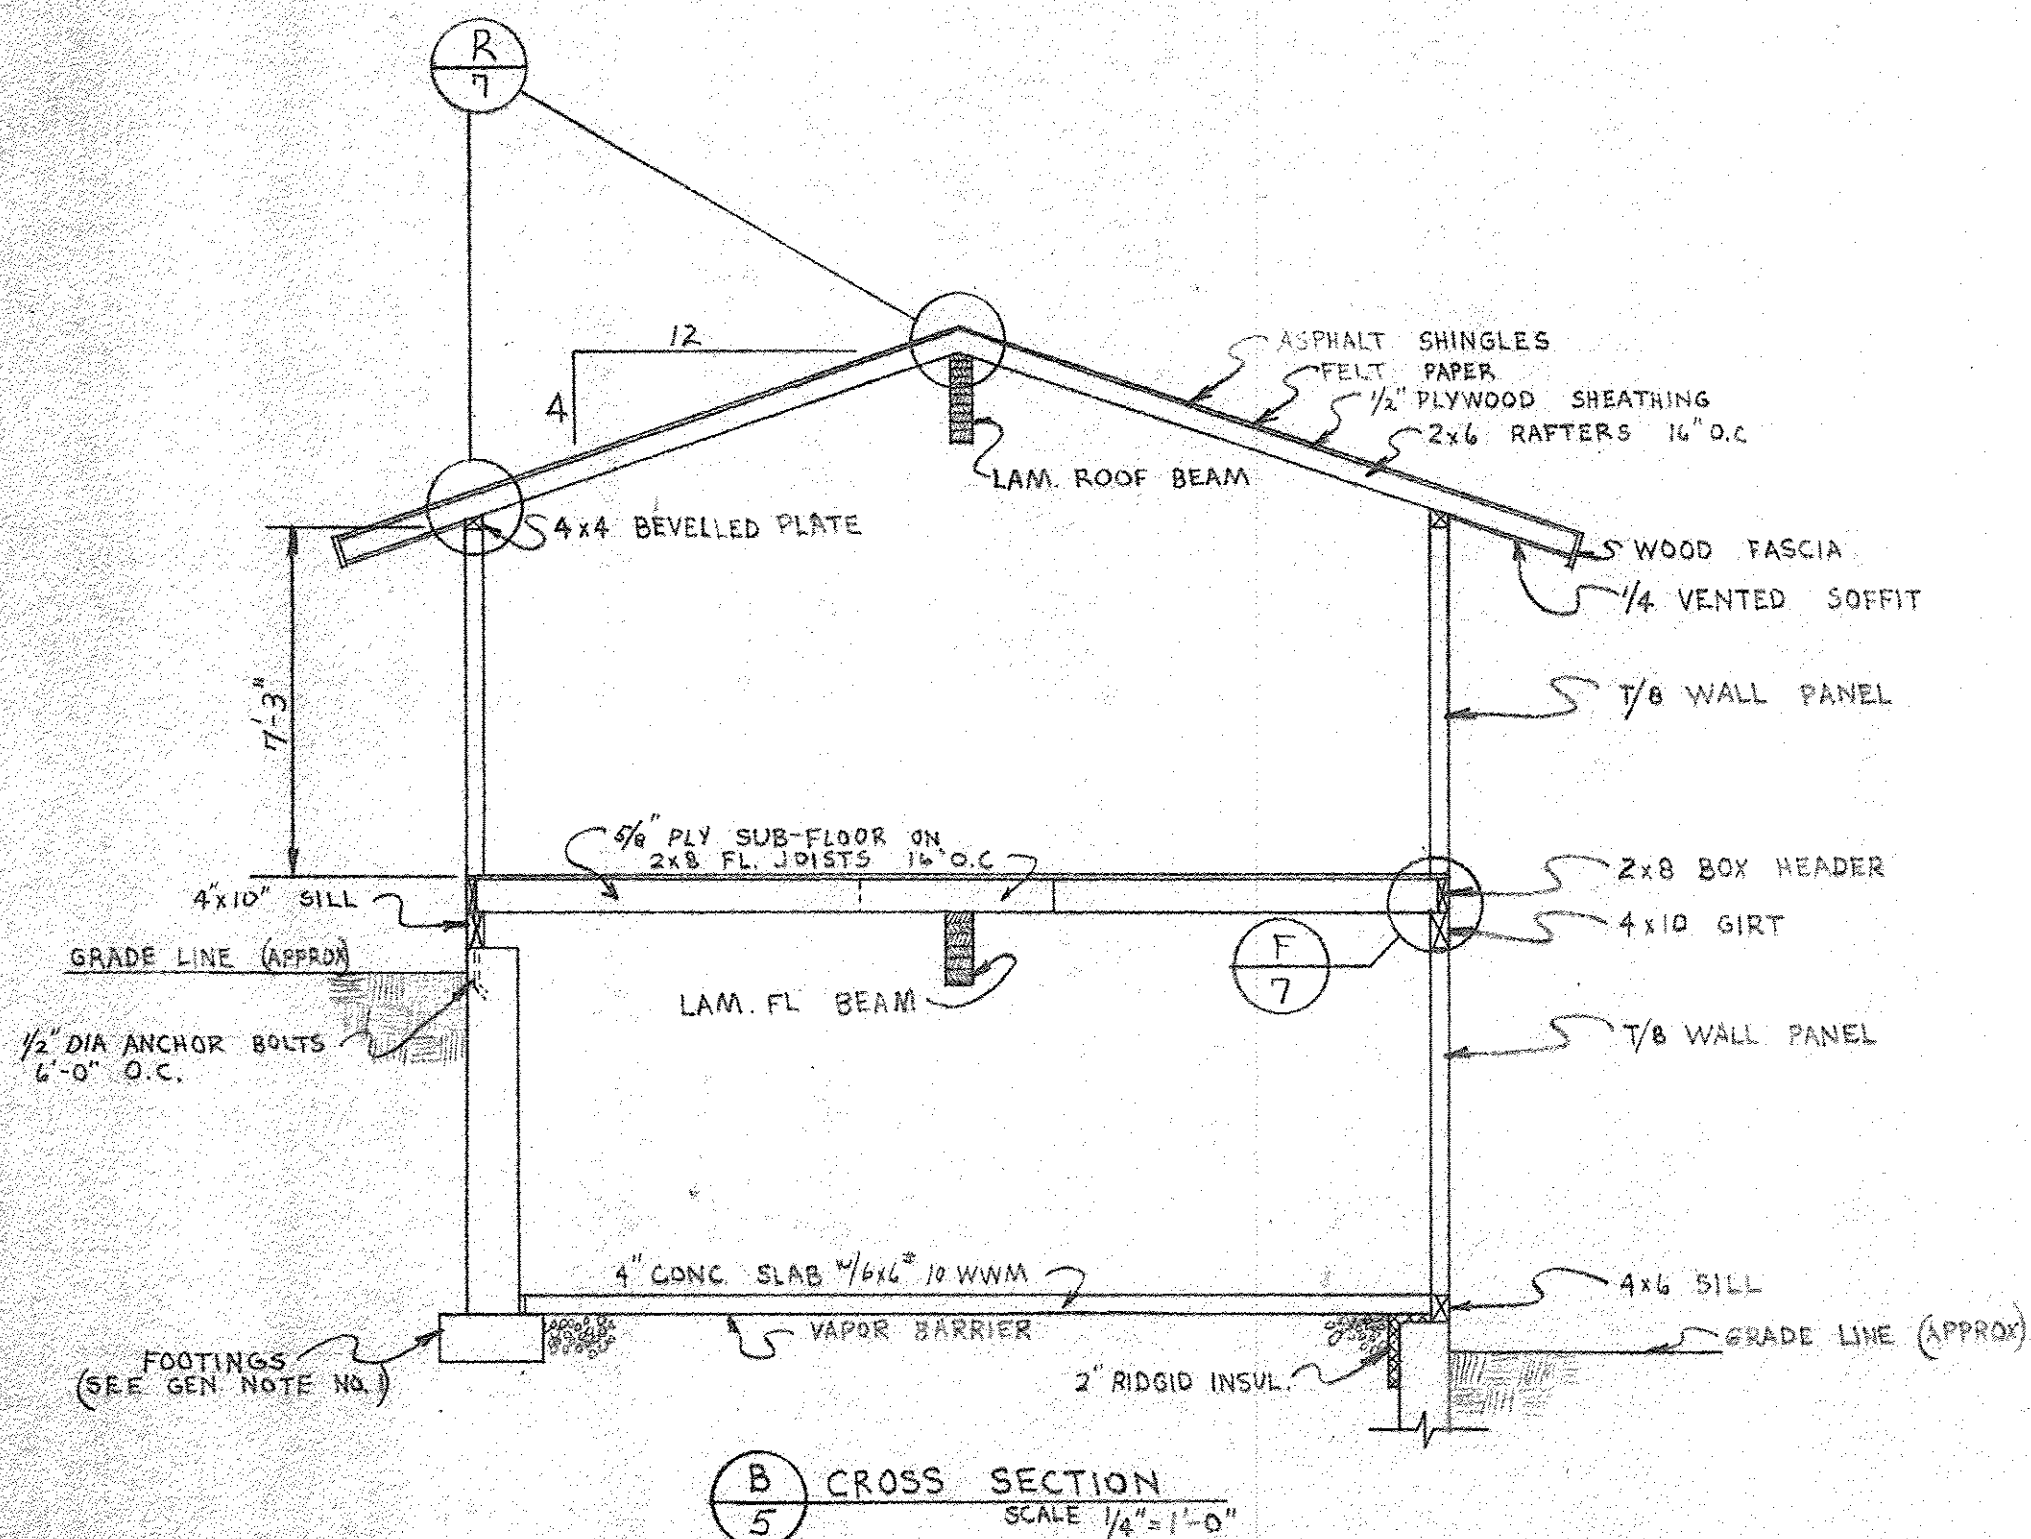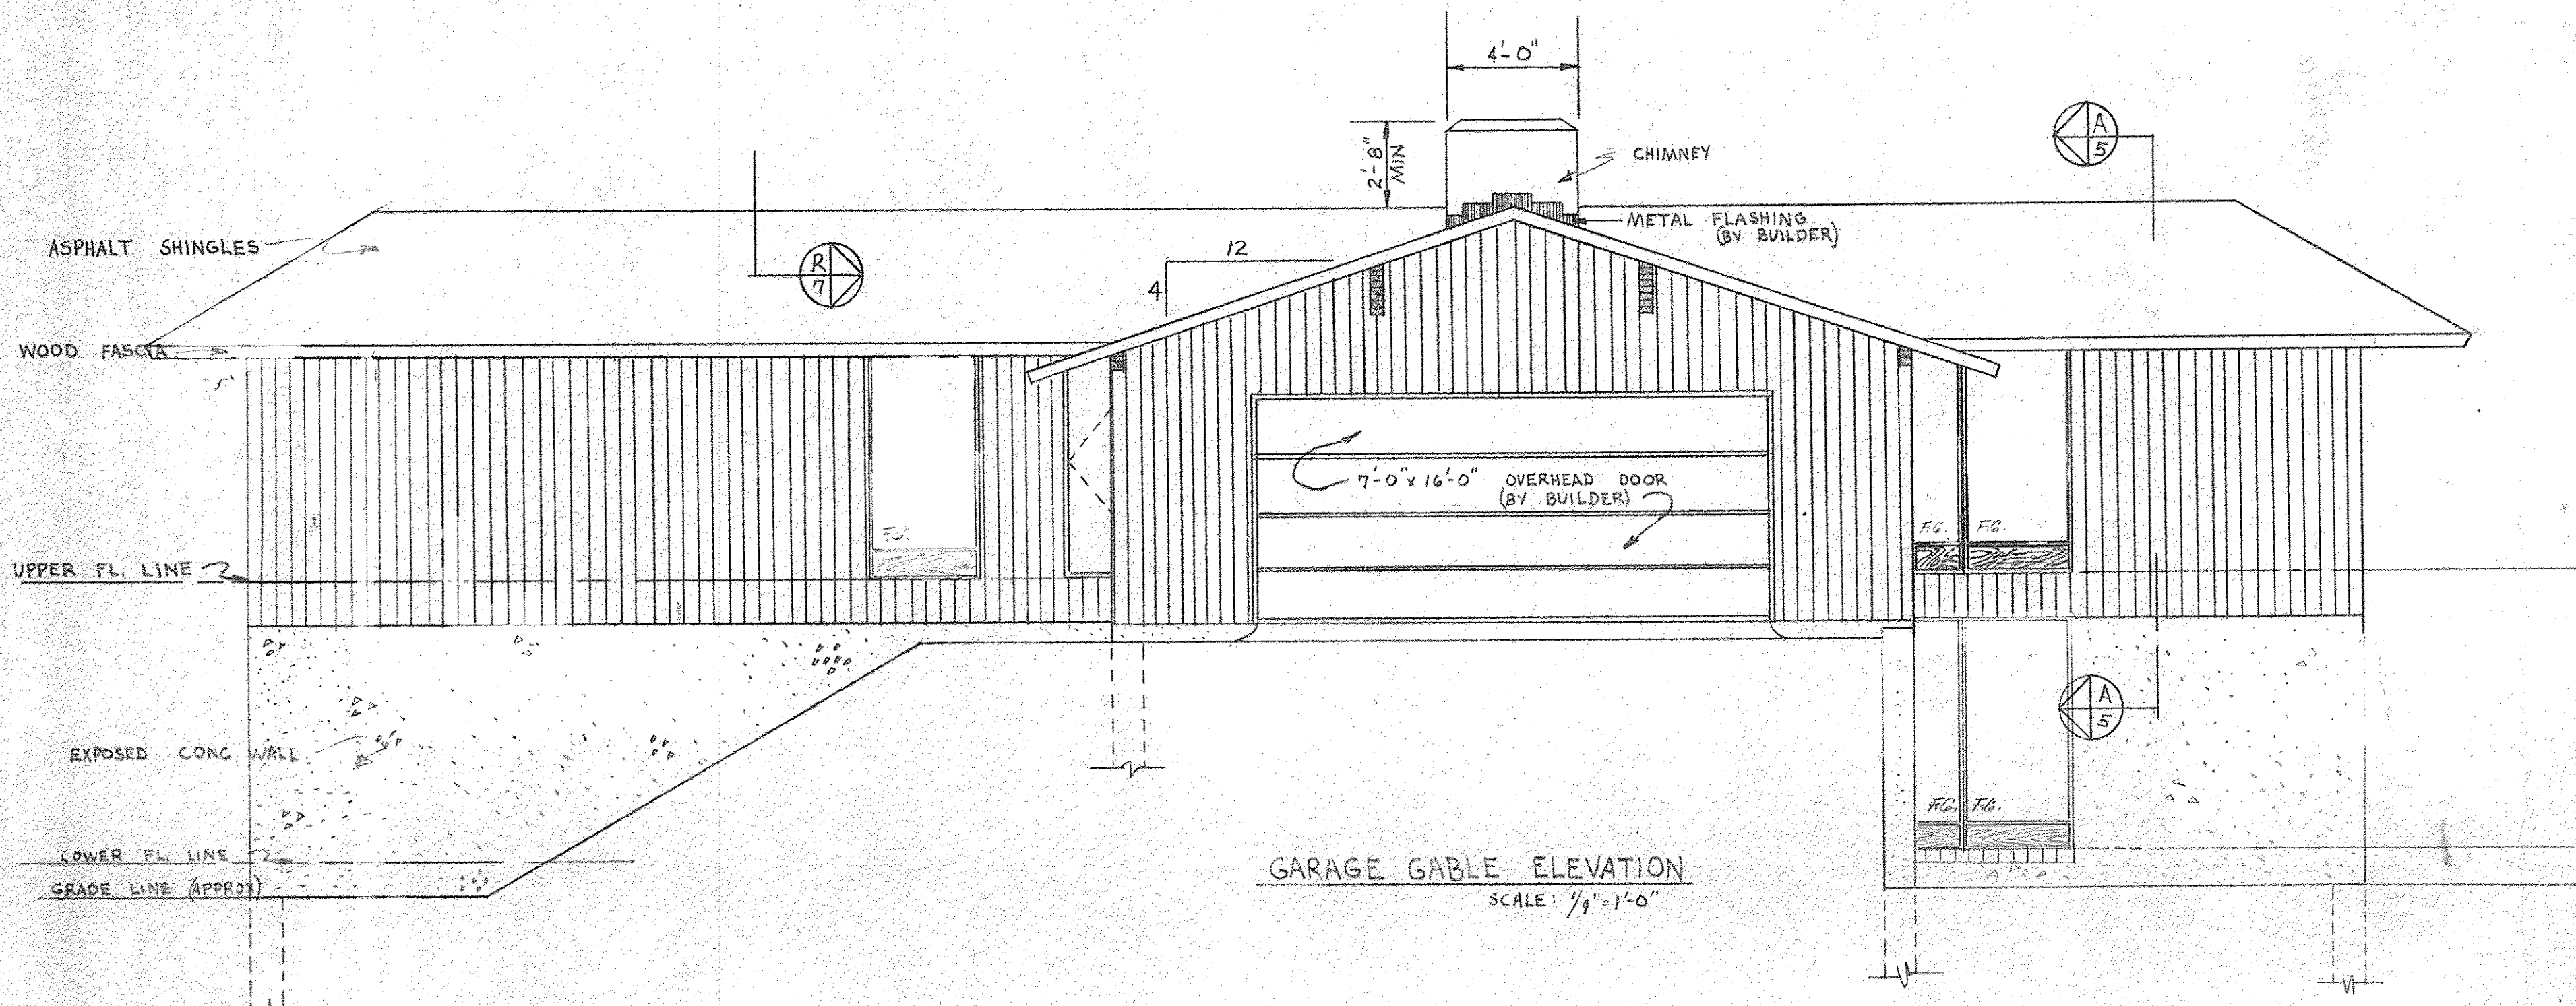

TECHBUILT

585 State Road
North Dartmouth
Massachusetts 02747
617 996 6777

Model SHER RES.
Subject GALE ELEV. & CR. SS SECTION
Drawn by J.B. Date 7/27/75
Revision No. 1 Date 1/1
Scale 1/4" = 1'-0" Sheet 5 of 5
Drawing No.

COPYRIGHT 1975 TECHBUILT, INC. ALL RIGHTS RESERVED. THESE PLANS MAY NOT BE USED IN ANY MANNER WITHOUT THE WRITTEN PERMISSION OF TECHBUILT, INC.