


PERSPECTIVE VIEWS

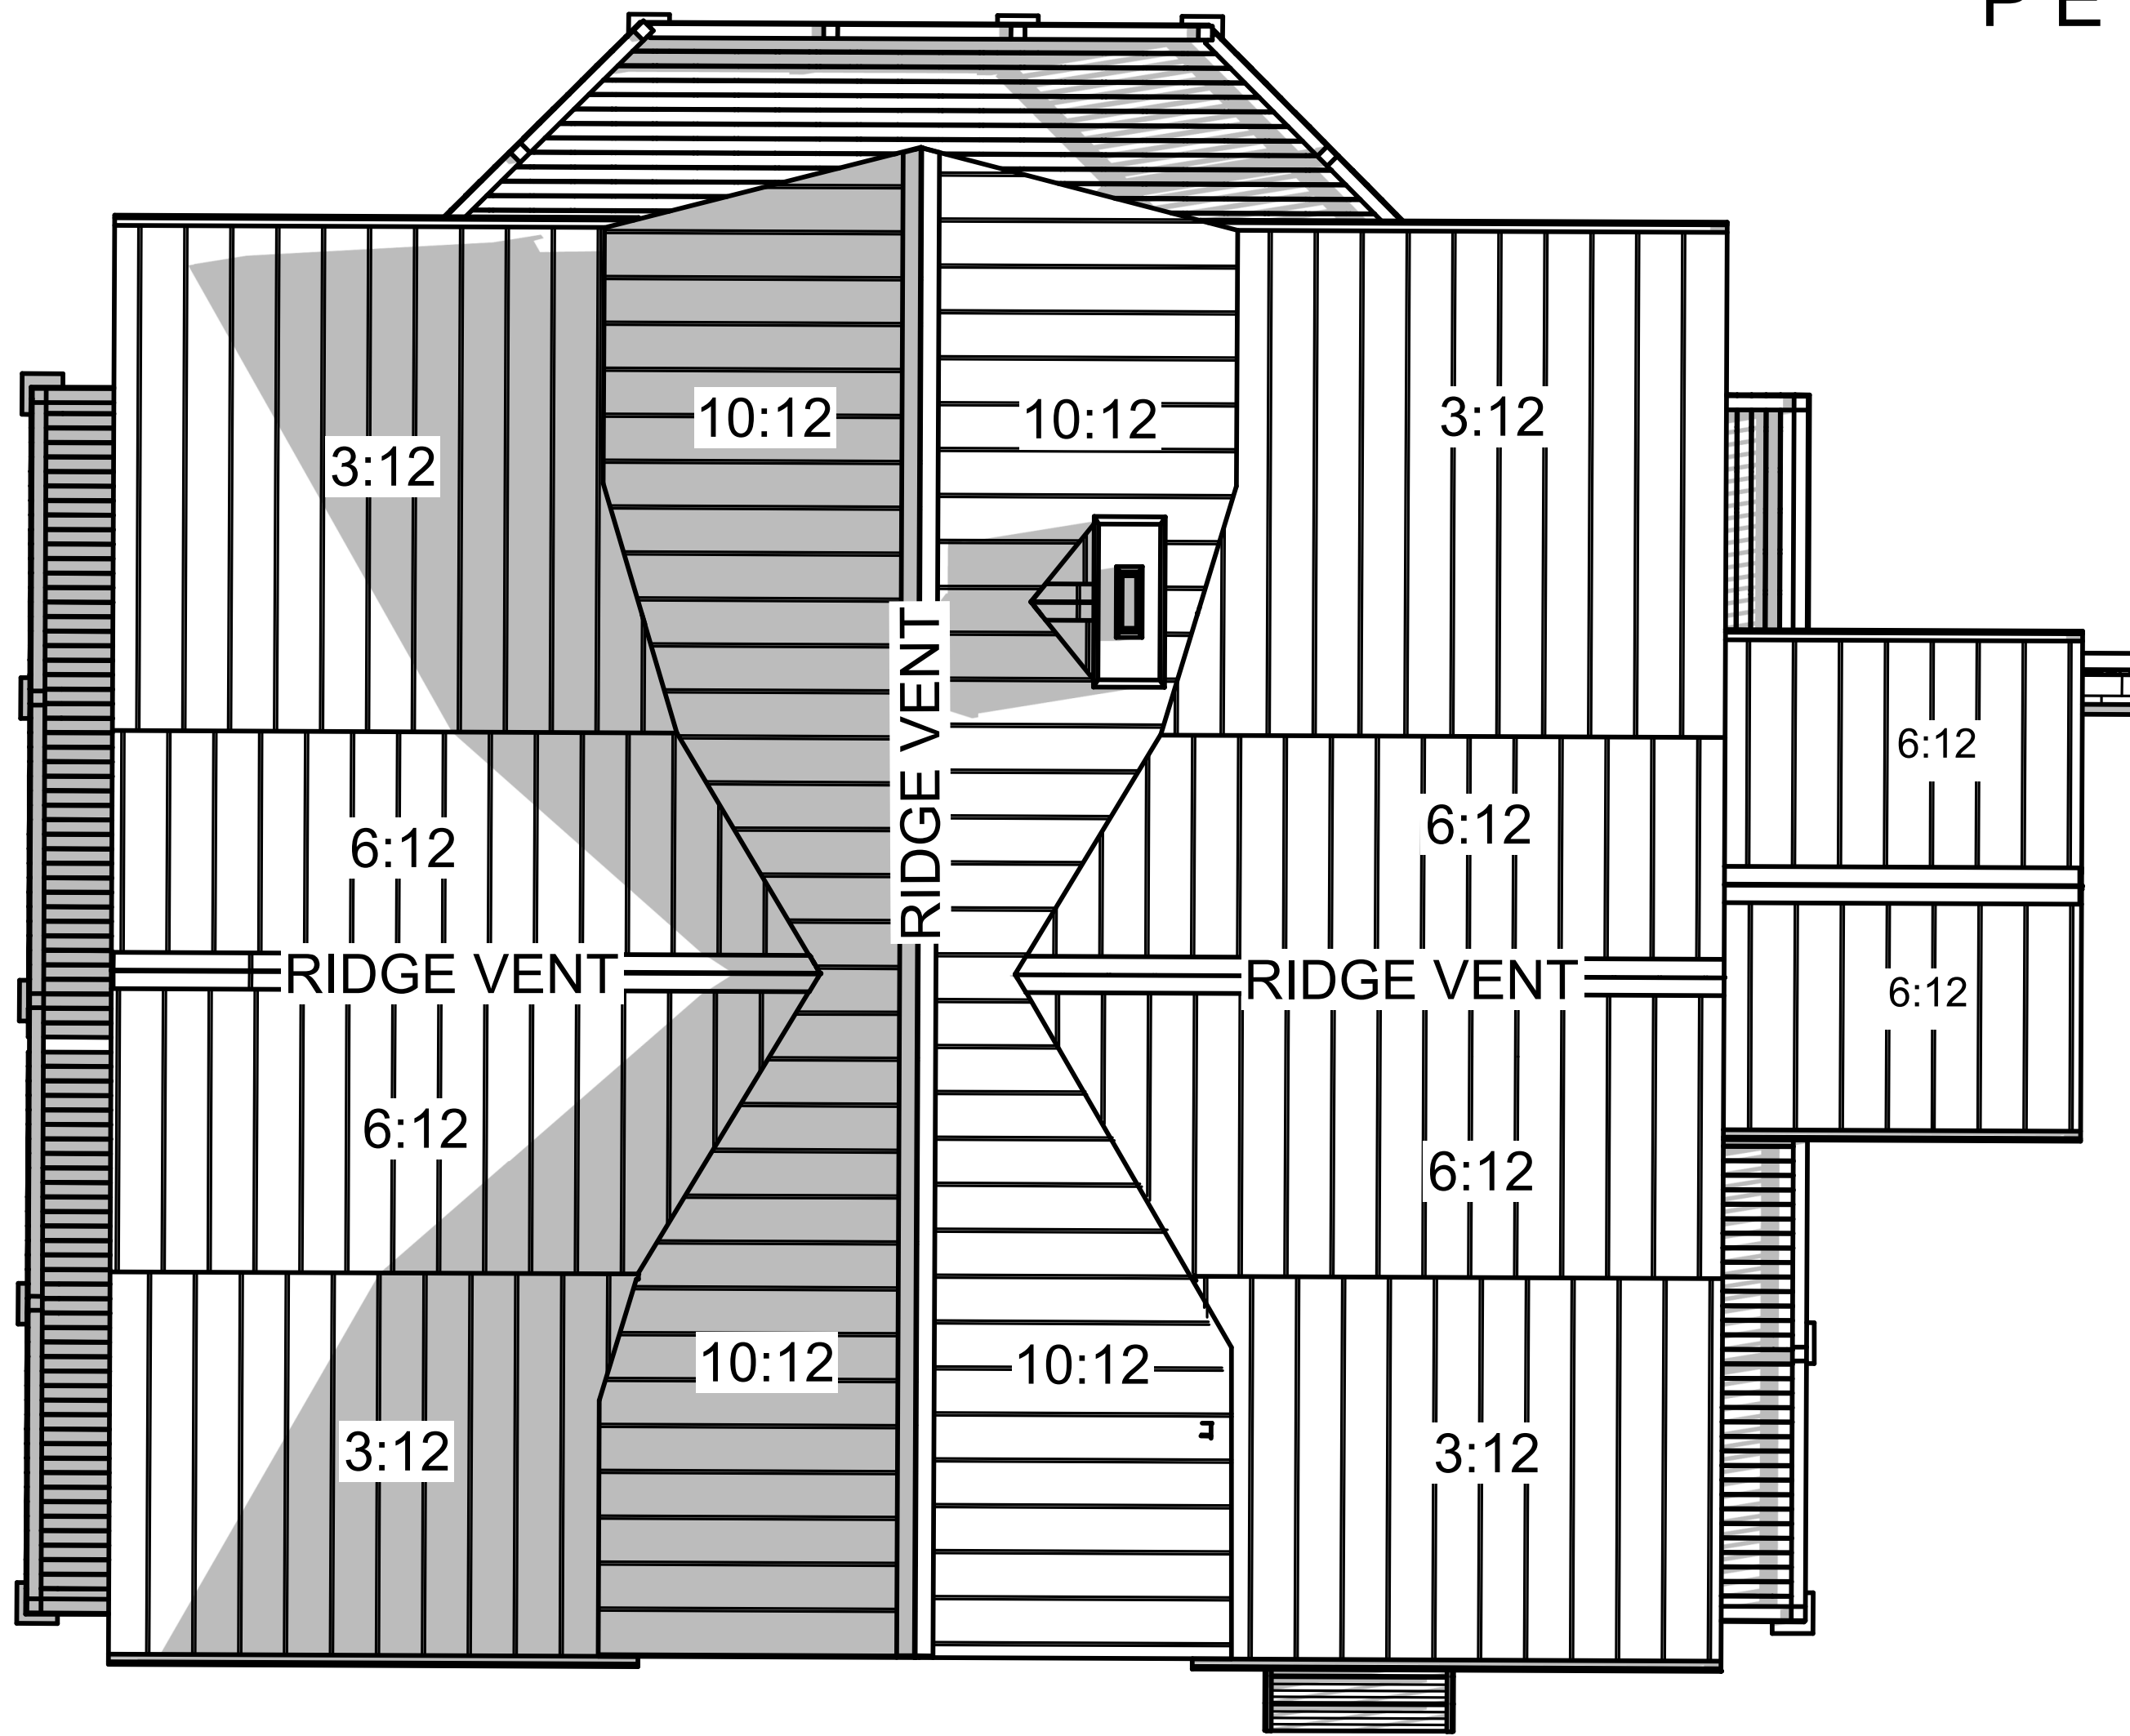


ROOF OVERVIEW




REAR PERSPECTIVE

Note: These perspective views are provided for visual reference only. They are not to scale and are not to be used as such.

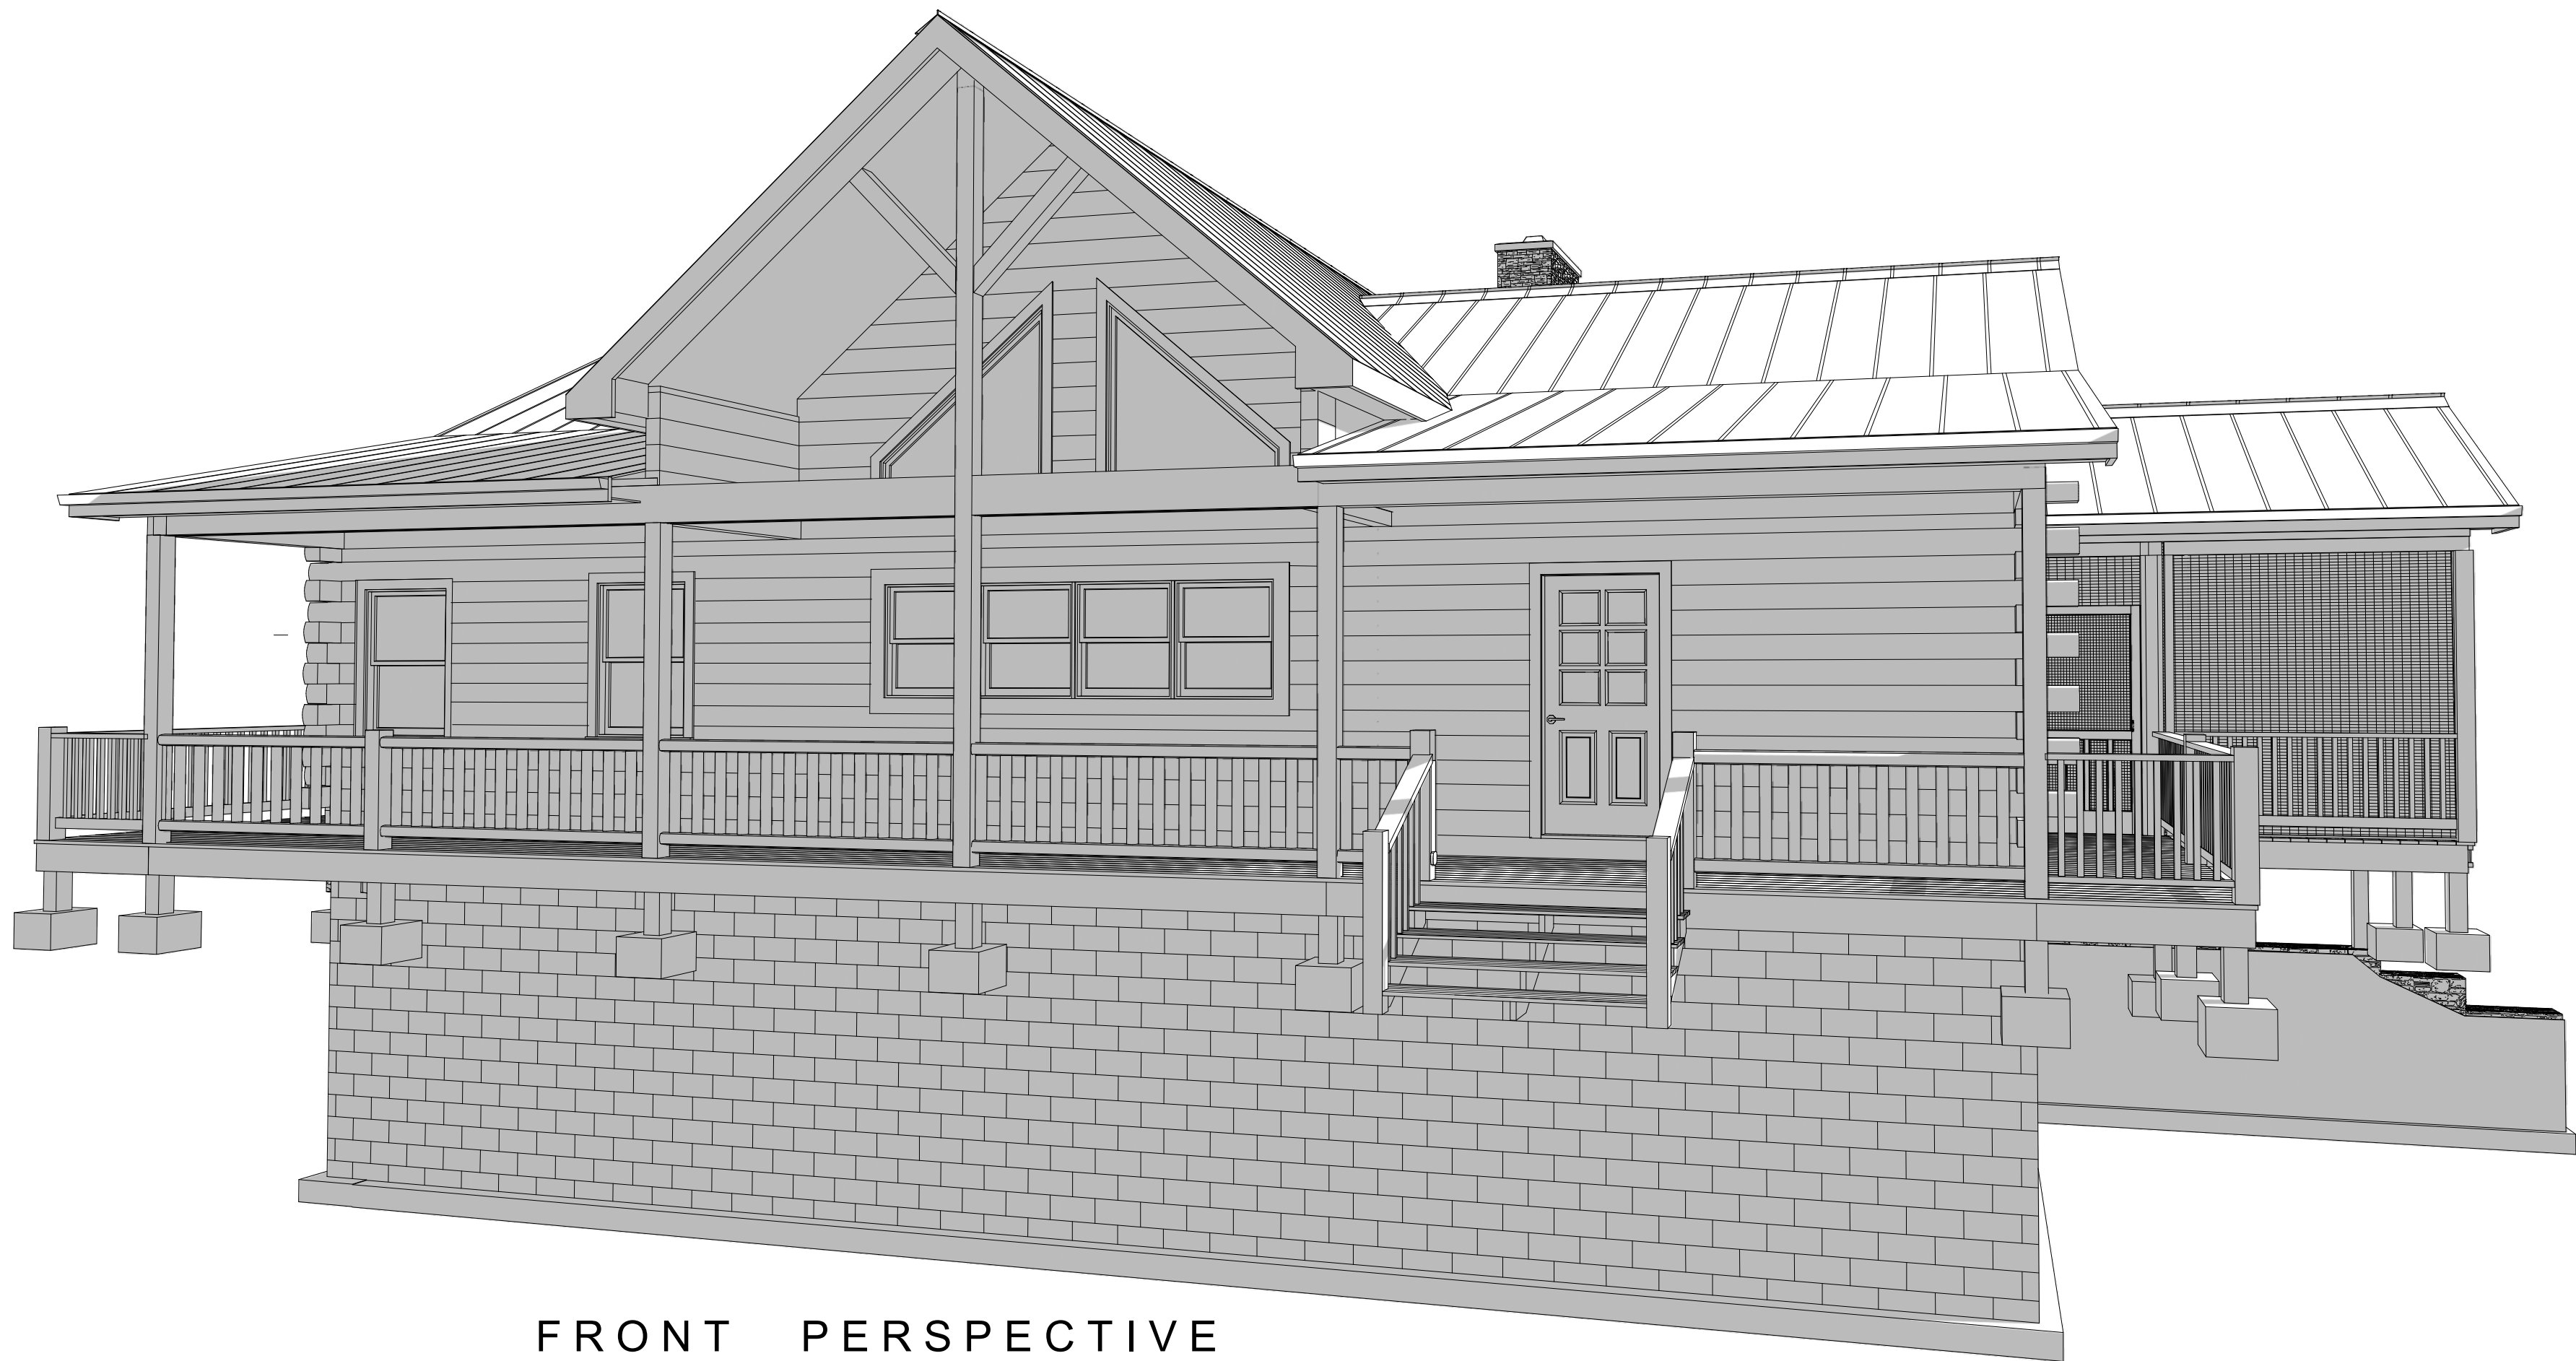

FRONT PERSPECTIVE

 - SHEET 1 PERSPECTIVE VIEWS ROOF OVERHEAD VIEW
- SHEET 2 FLOOR PLAN
- SHEET 3 BASEMENT/FOUNDATION PLAN
- SHEET 4 ROOF PLAN
- SHEET 5 FLOOR FRAMING PLAN ROOF FRAMING PLAN
- SHEET 6 EXTERIOR ELEVATIONS
- SHEET 7    
- SHEET 8        
- SHEET 9 TYPICAL WALL SECTION  

Sheet No.

1

SCALE: SEE VIEW

Aug. 6, 2021

DRAWN BY: KLT

Approved by

Insp.

Date:

PERSPECTIVE VIEWS

ROOF OVERVIEW

CHASE AND

TONYA TUNNELL

LOG HOME PLAN


Home Design / Building Management

Kenneth L. Thompson

604 A St. * Staunton, Va. 24401

540-280 4059

These drawings have been prepared for the purpose of communicating the design and obtaining necessary building permits. It is the responsibility of the builder to execute the design in a structurally sound manner and to abide by all local building codes.

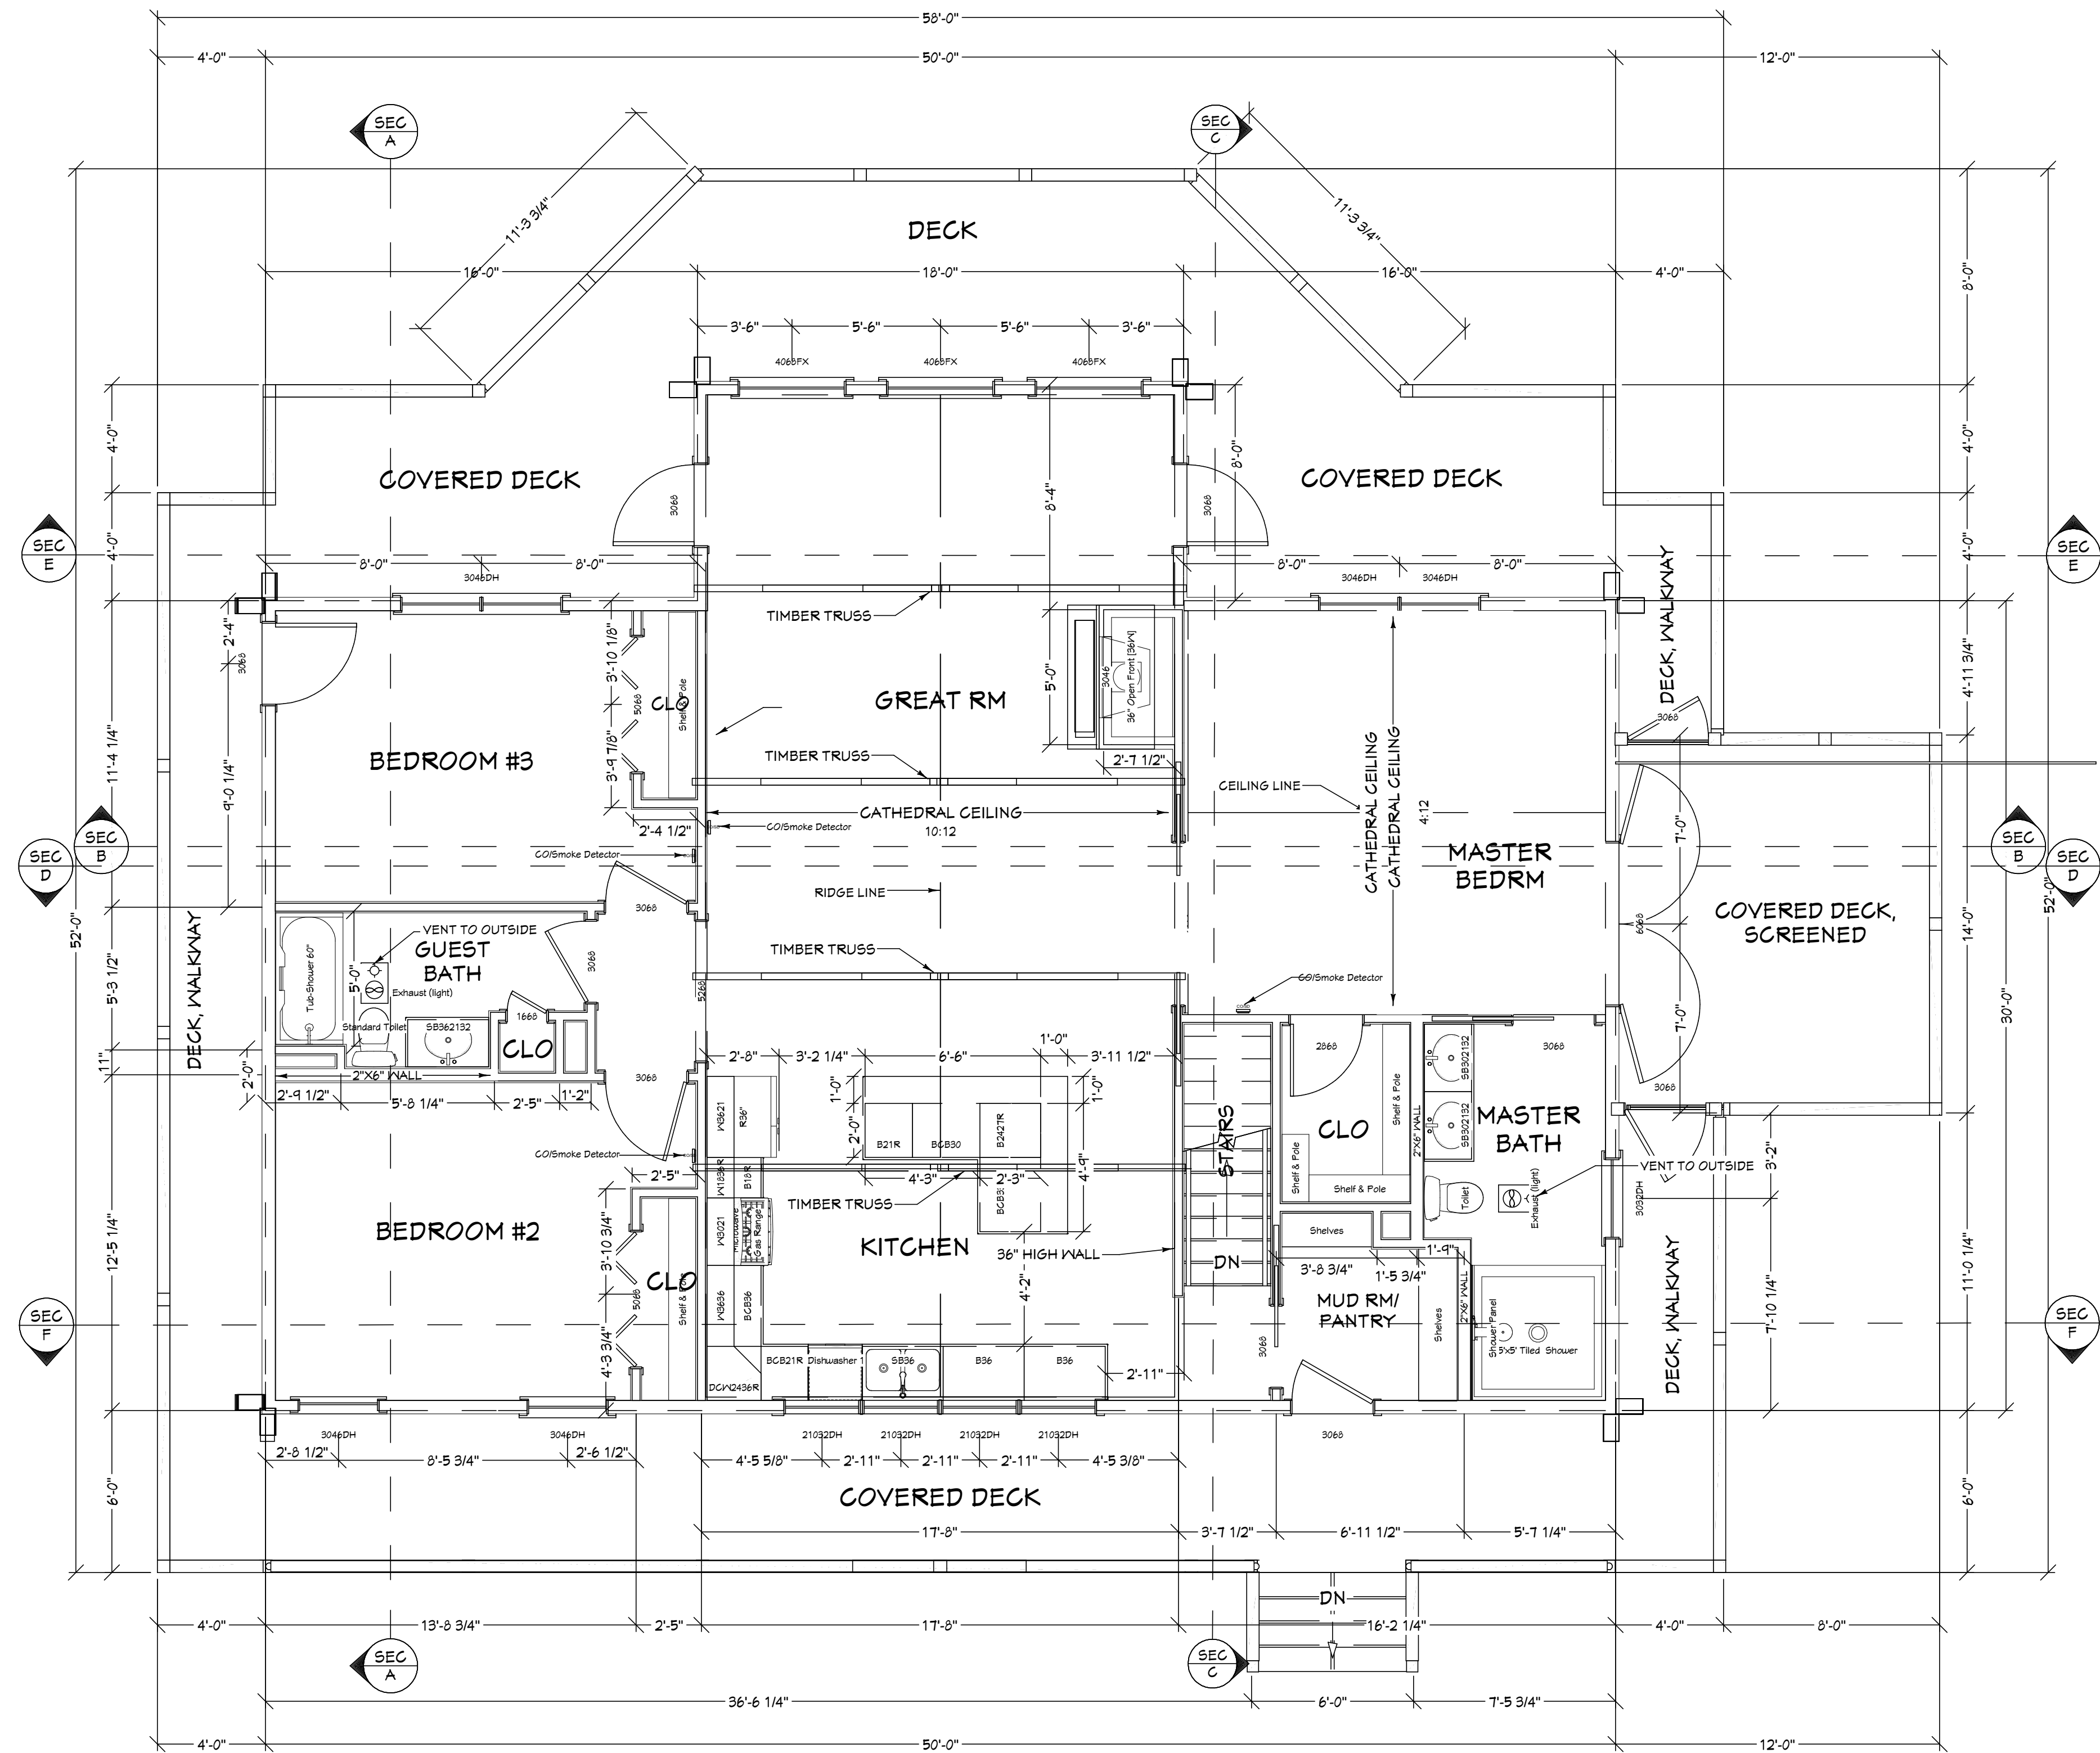

FLOOR PLAN 1/4"=1'

MAIN FLOOR 1,644.0 SQ.FT. TO EXTERIOR OF LOG WALLS
BASEMENT 1,477.0 SQ.FT. TO INSIDE TO INSIDE MASONRY WALLS
COVERED DECK 556.0 SQ.FT.
SCREENED PORCH 112.0 SQ.FT.

NOTE: ALL EXTERIOR WALLS 14 COURSE TYPICAL LOG WALLS
ALL INTERIOR WALLS 2"x4" WITH 3/4" TONGUE AND GROOVE
OR SHIP LAP BOARDS EXCEPT WHERE NOTED ON PLAN AS
2"x6" WALLS
CEILING'S FLAT EXCEPT WHERE NOTED AS CATHEDRAL
CABINETS, PLUMBING FIXTURES, LIGHT FIXTURES ETC.
TO BE PICKED BY OWNERS

These drawings have been prepared for the purpose of communicating the design and obtaining necessary building permits. It is the responsibility of the builder to execute the design in a structurally sound manner and to abide by all local building codes.

Home Design / Building Management
Kenneth L. Thompson
604 A St. * Staunton, Va.24401
540-280 4059


CHASE AND
TONYA TUNNELL
LOG HOME PLAN

FLOOR PLAN

Approved by
Insp.
Date:

SCALE: SEE VIEW
Aug.6,2021
DRAWN BY: KLT

Sheet No.
2

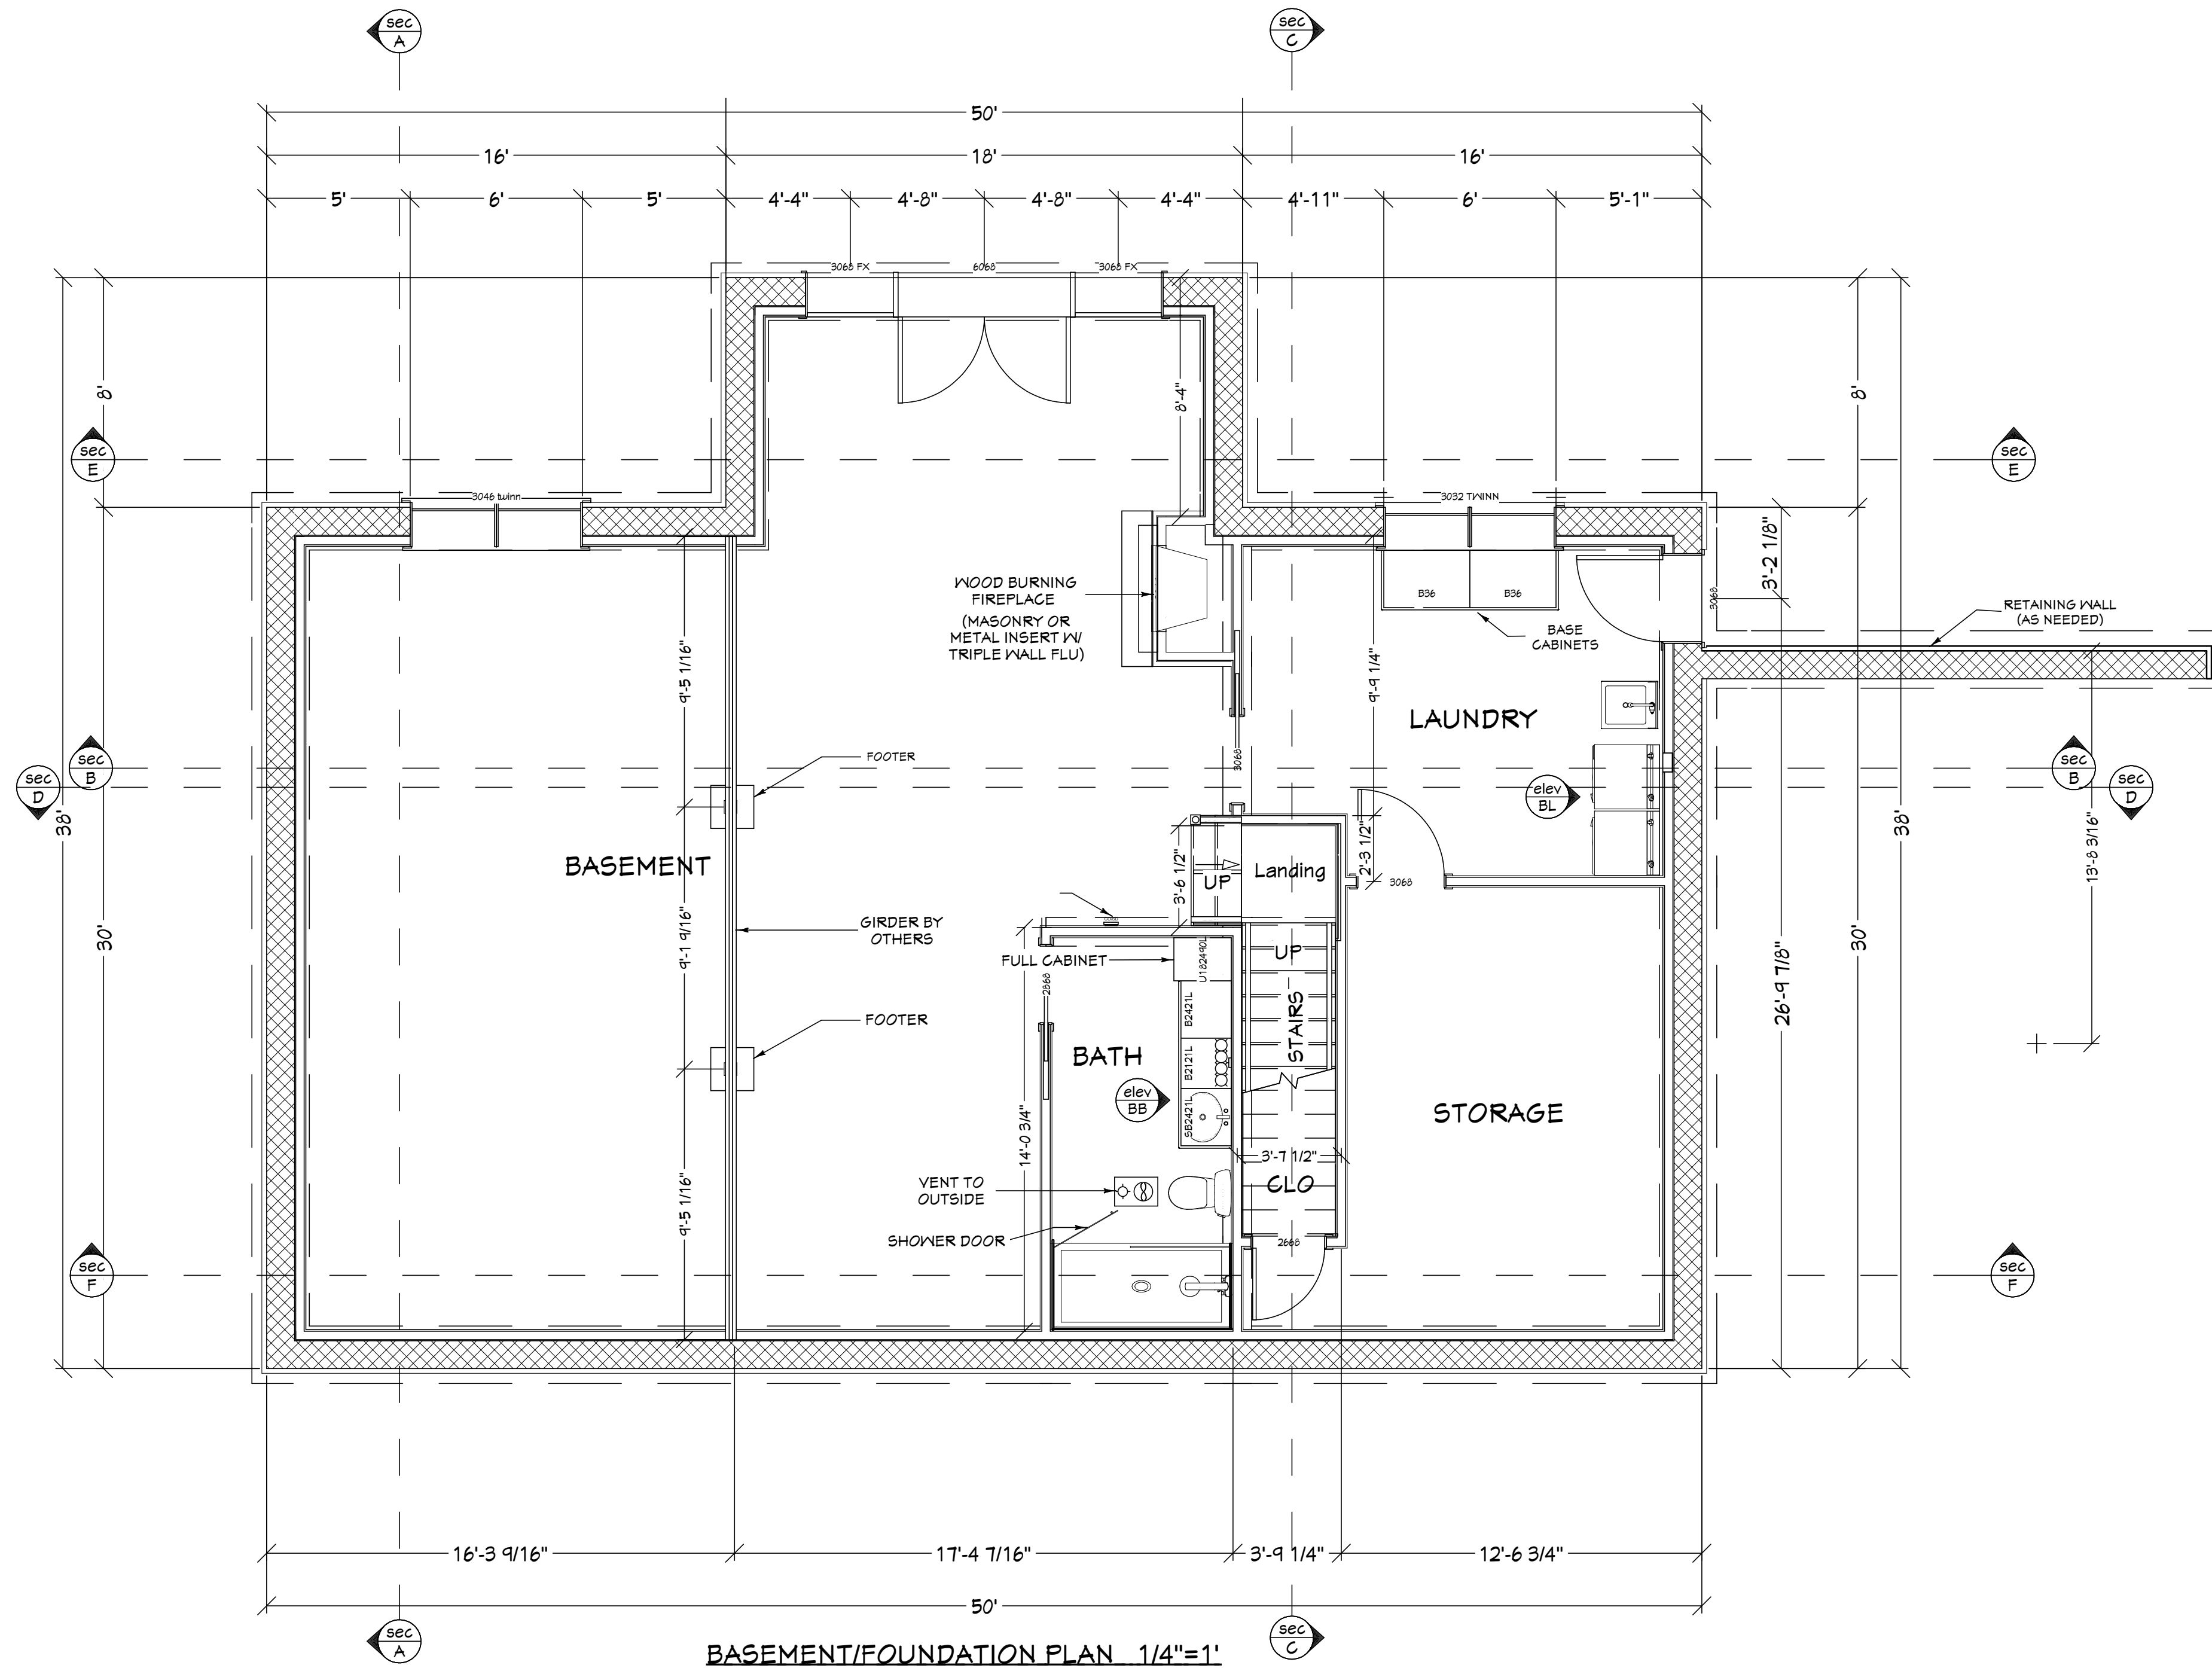

BASEMENT/FOUNDATION PLAN 1/4"=1'

These drawings have been prepared for the purpose of communicating the design and obtaining necessary building permits. It is the responsibility of the builder to execute the design in a structurally sound manner and to abide by all local building codes.

Home Design / Building Management
Kenneth L. Thompson
604 A St. * Staunton, Va. 24401
540-280 4059


CHASE AND
TONYA TUNNELL
LOG HOME PLAN

BASEMENT/
FOUNDATION PLAN

Approved by
Insp.
Date:

SCALE: SEE VIEW
Aug. 6, 2021
DRAWN BY: KLT

Sheet No.
3

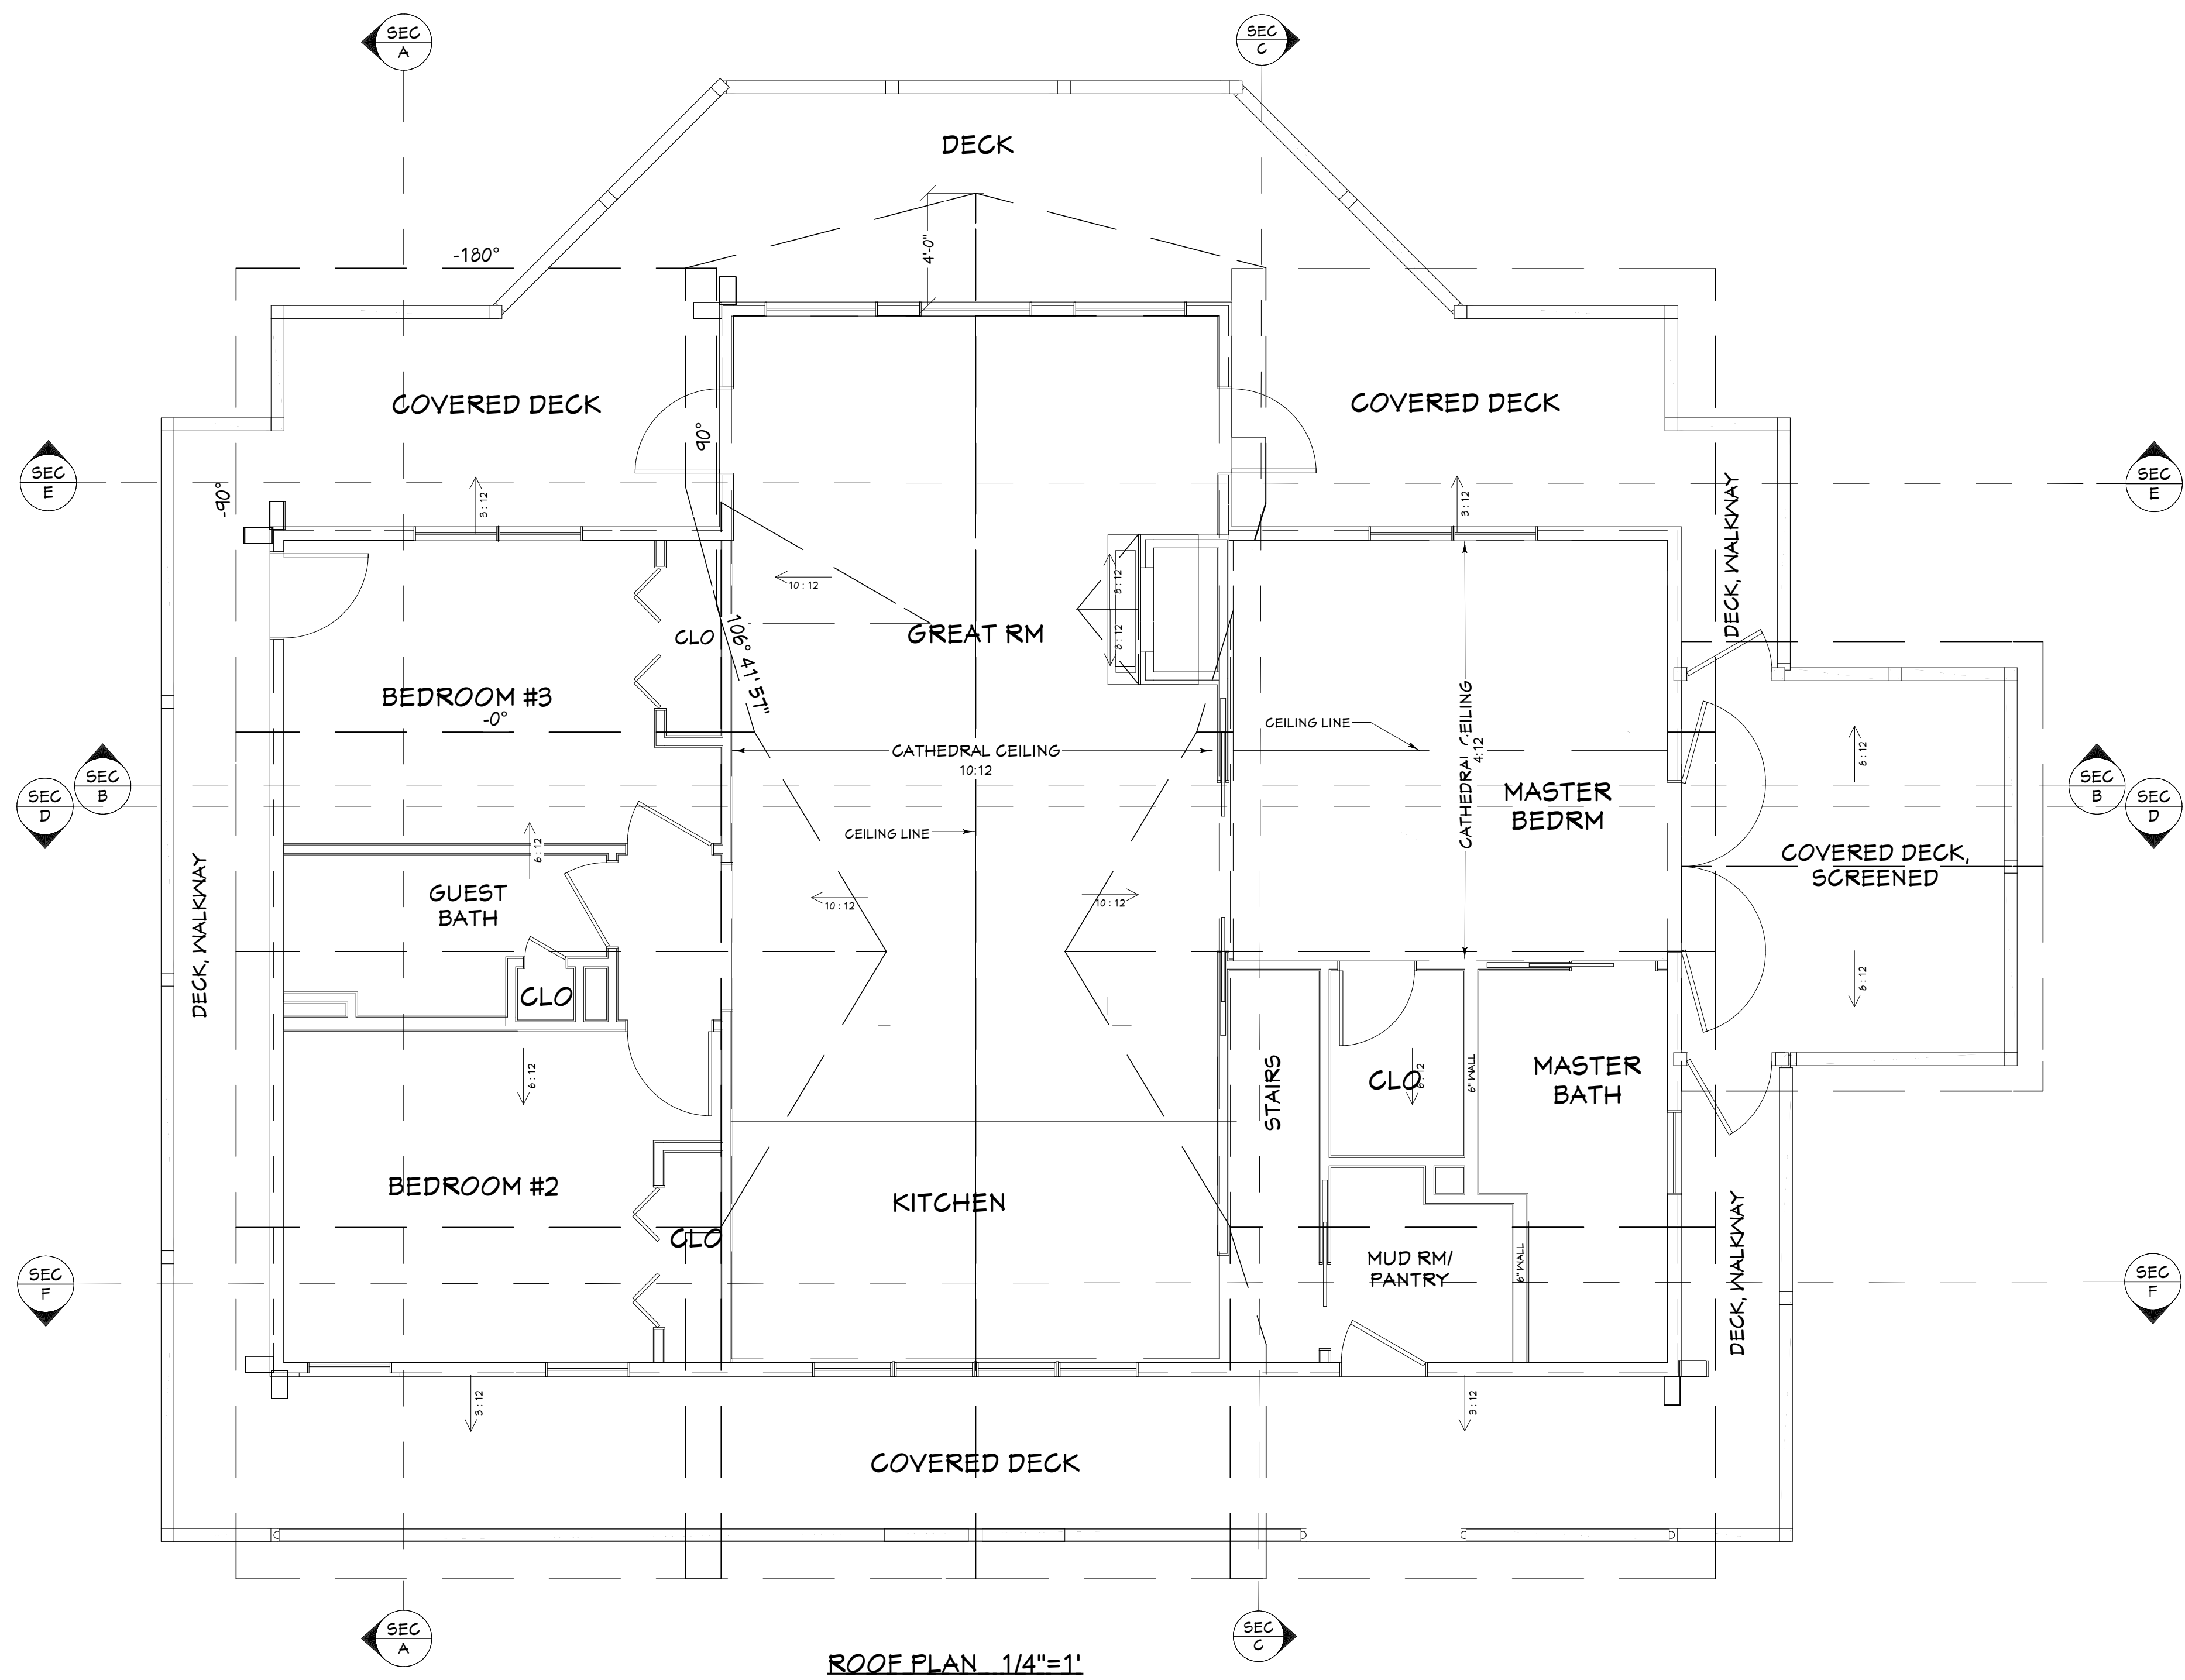

These drawings have been prepared for the purpose of communicating the design and obtaining necessary building permits. It is the responsibility of the builder to execute the design in a structurally sound manner and to abide by all local building codes.

Home Design / Building Management
Kenneth L. Thompson
604 A St. * Staunton, Va.24401
540-280 4059



CHASE AND
TONYA TUNNELL
LOG HOME PLAN

ROOF PLAN

Approved by
Insp.
Date:

SCALE: SEE VIEW
Aug.6,2021
DRAWN BY: KLT

Sheet No.
4

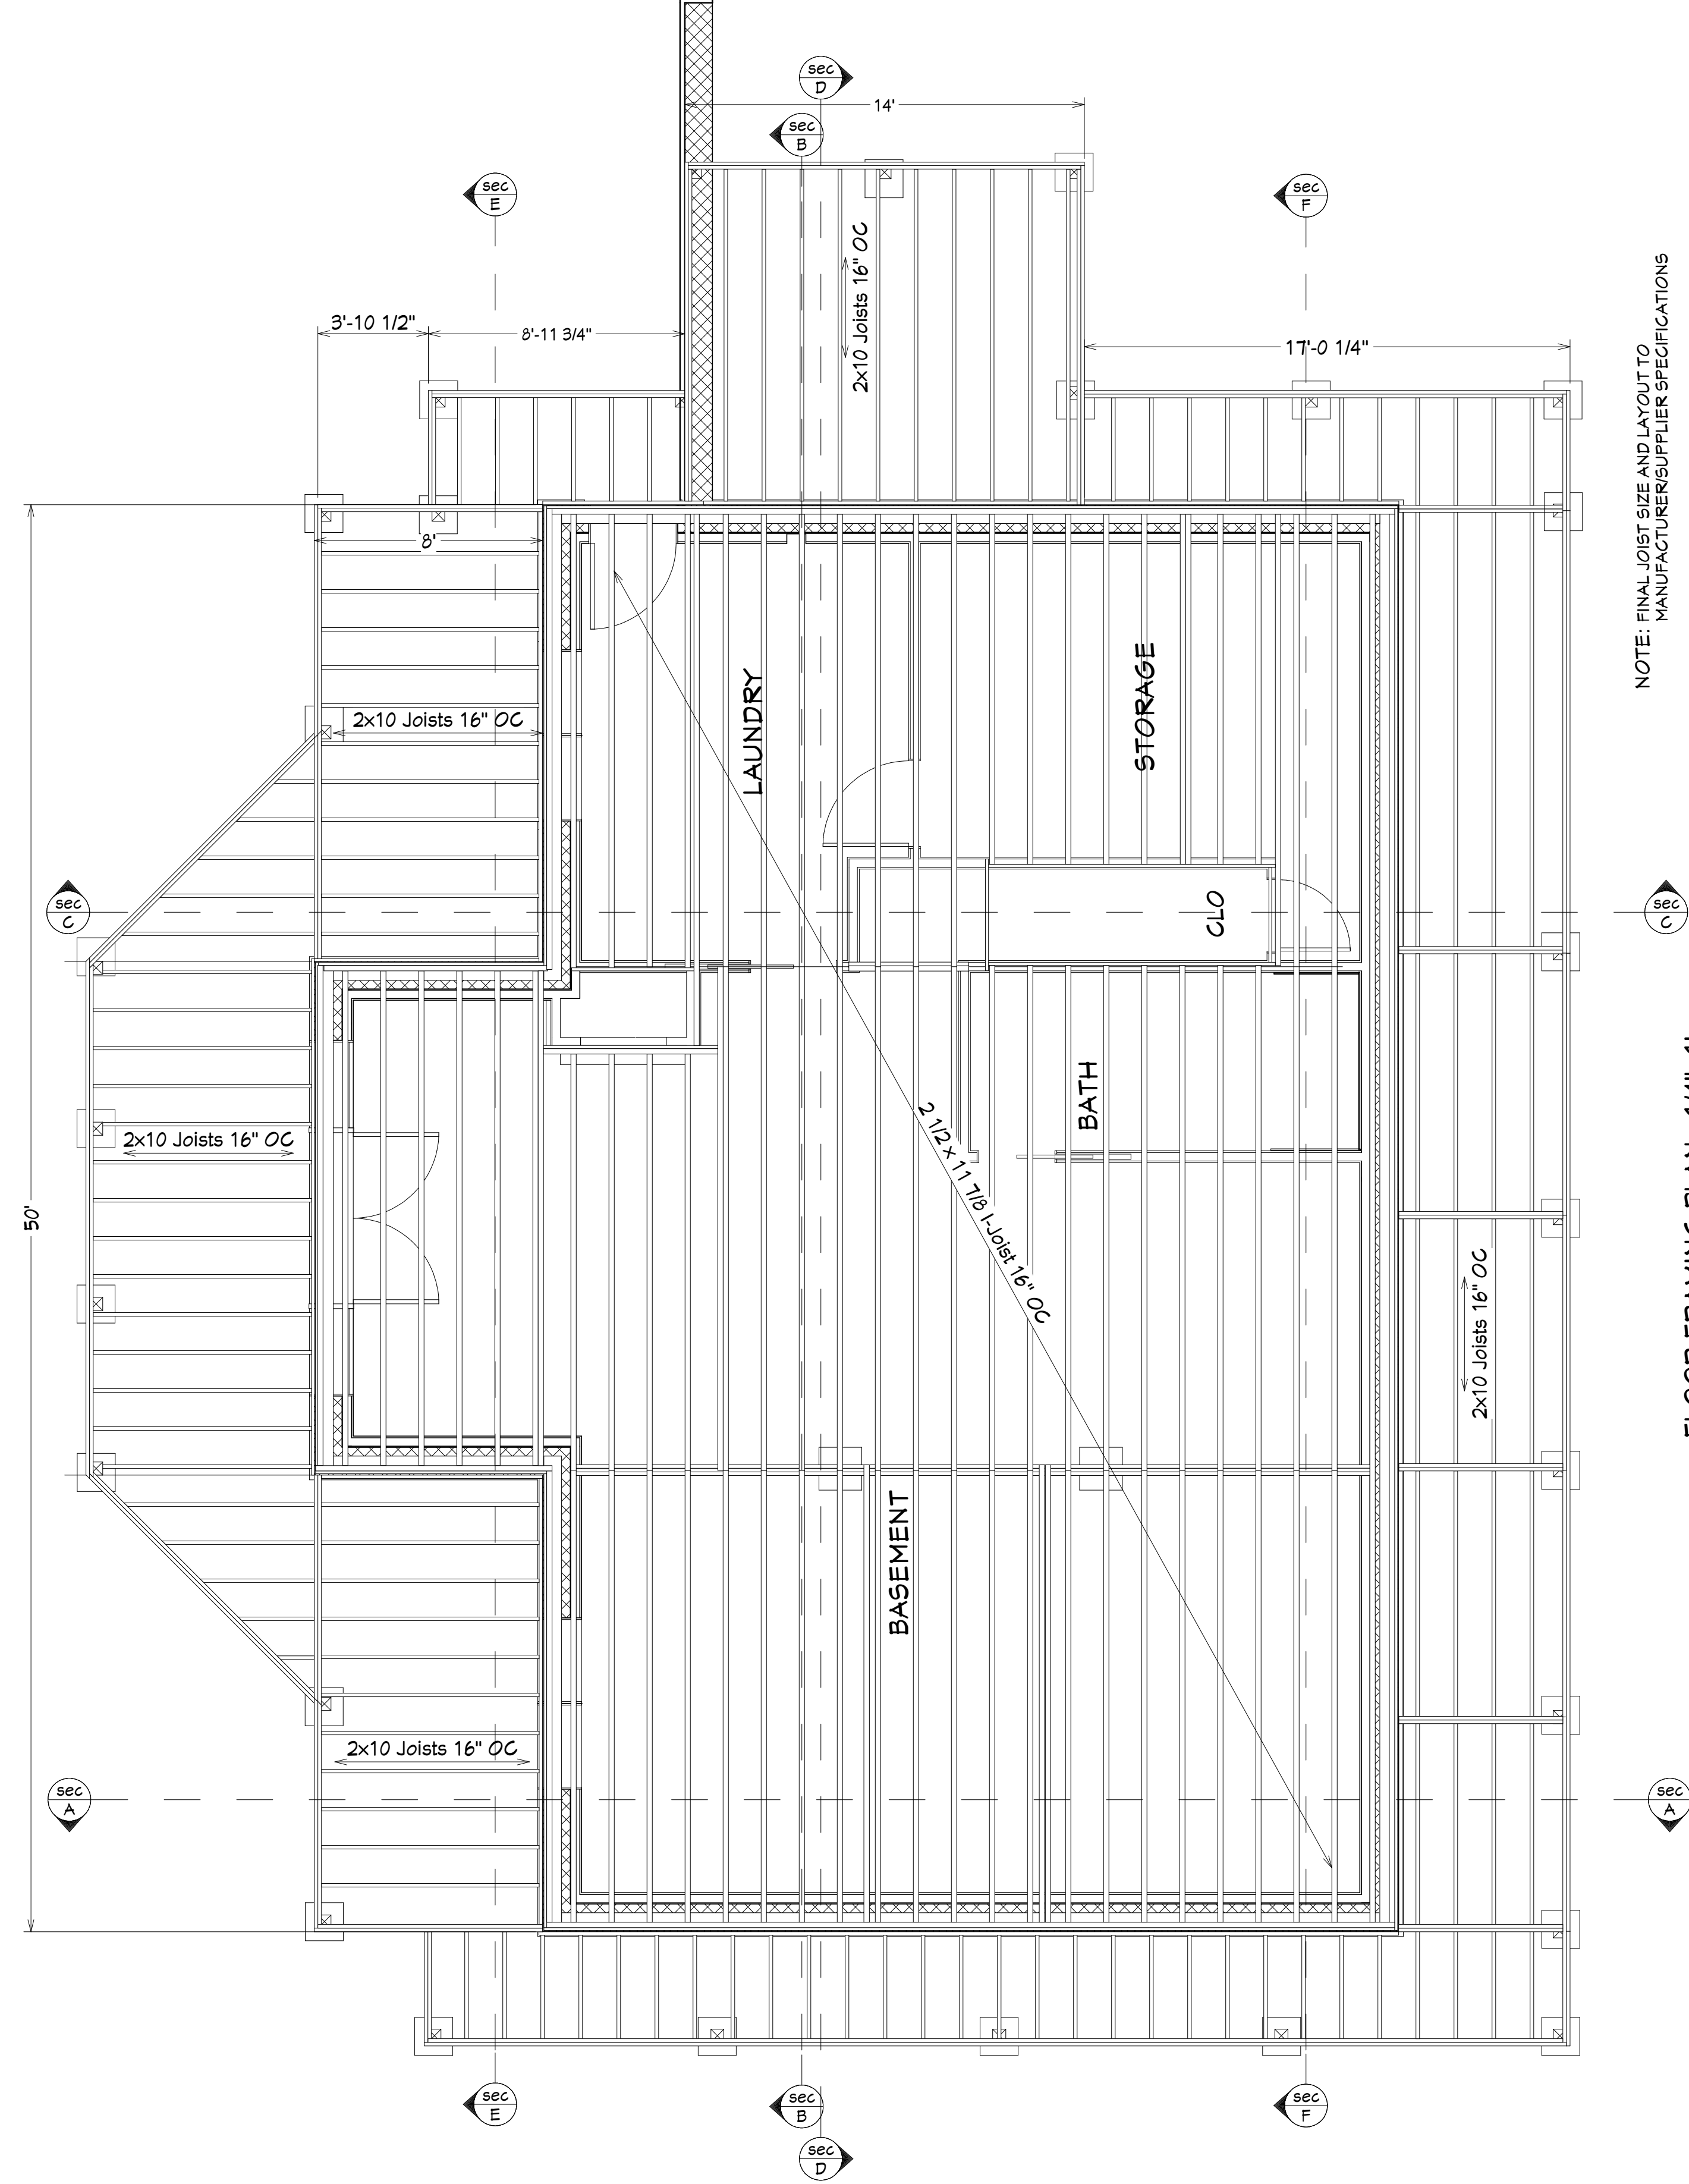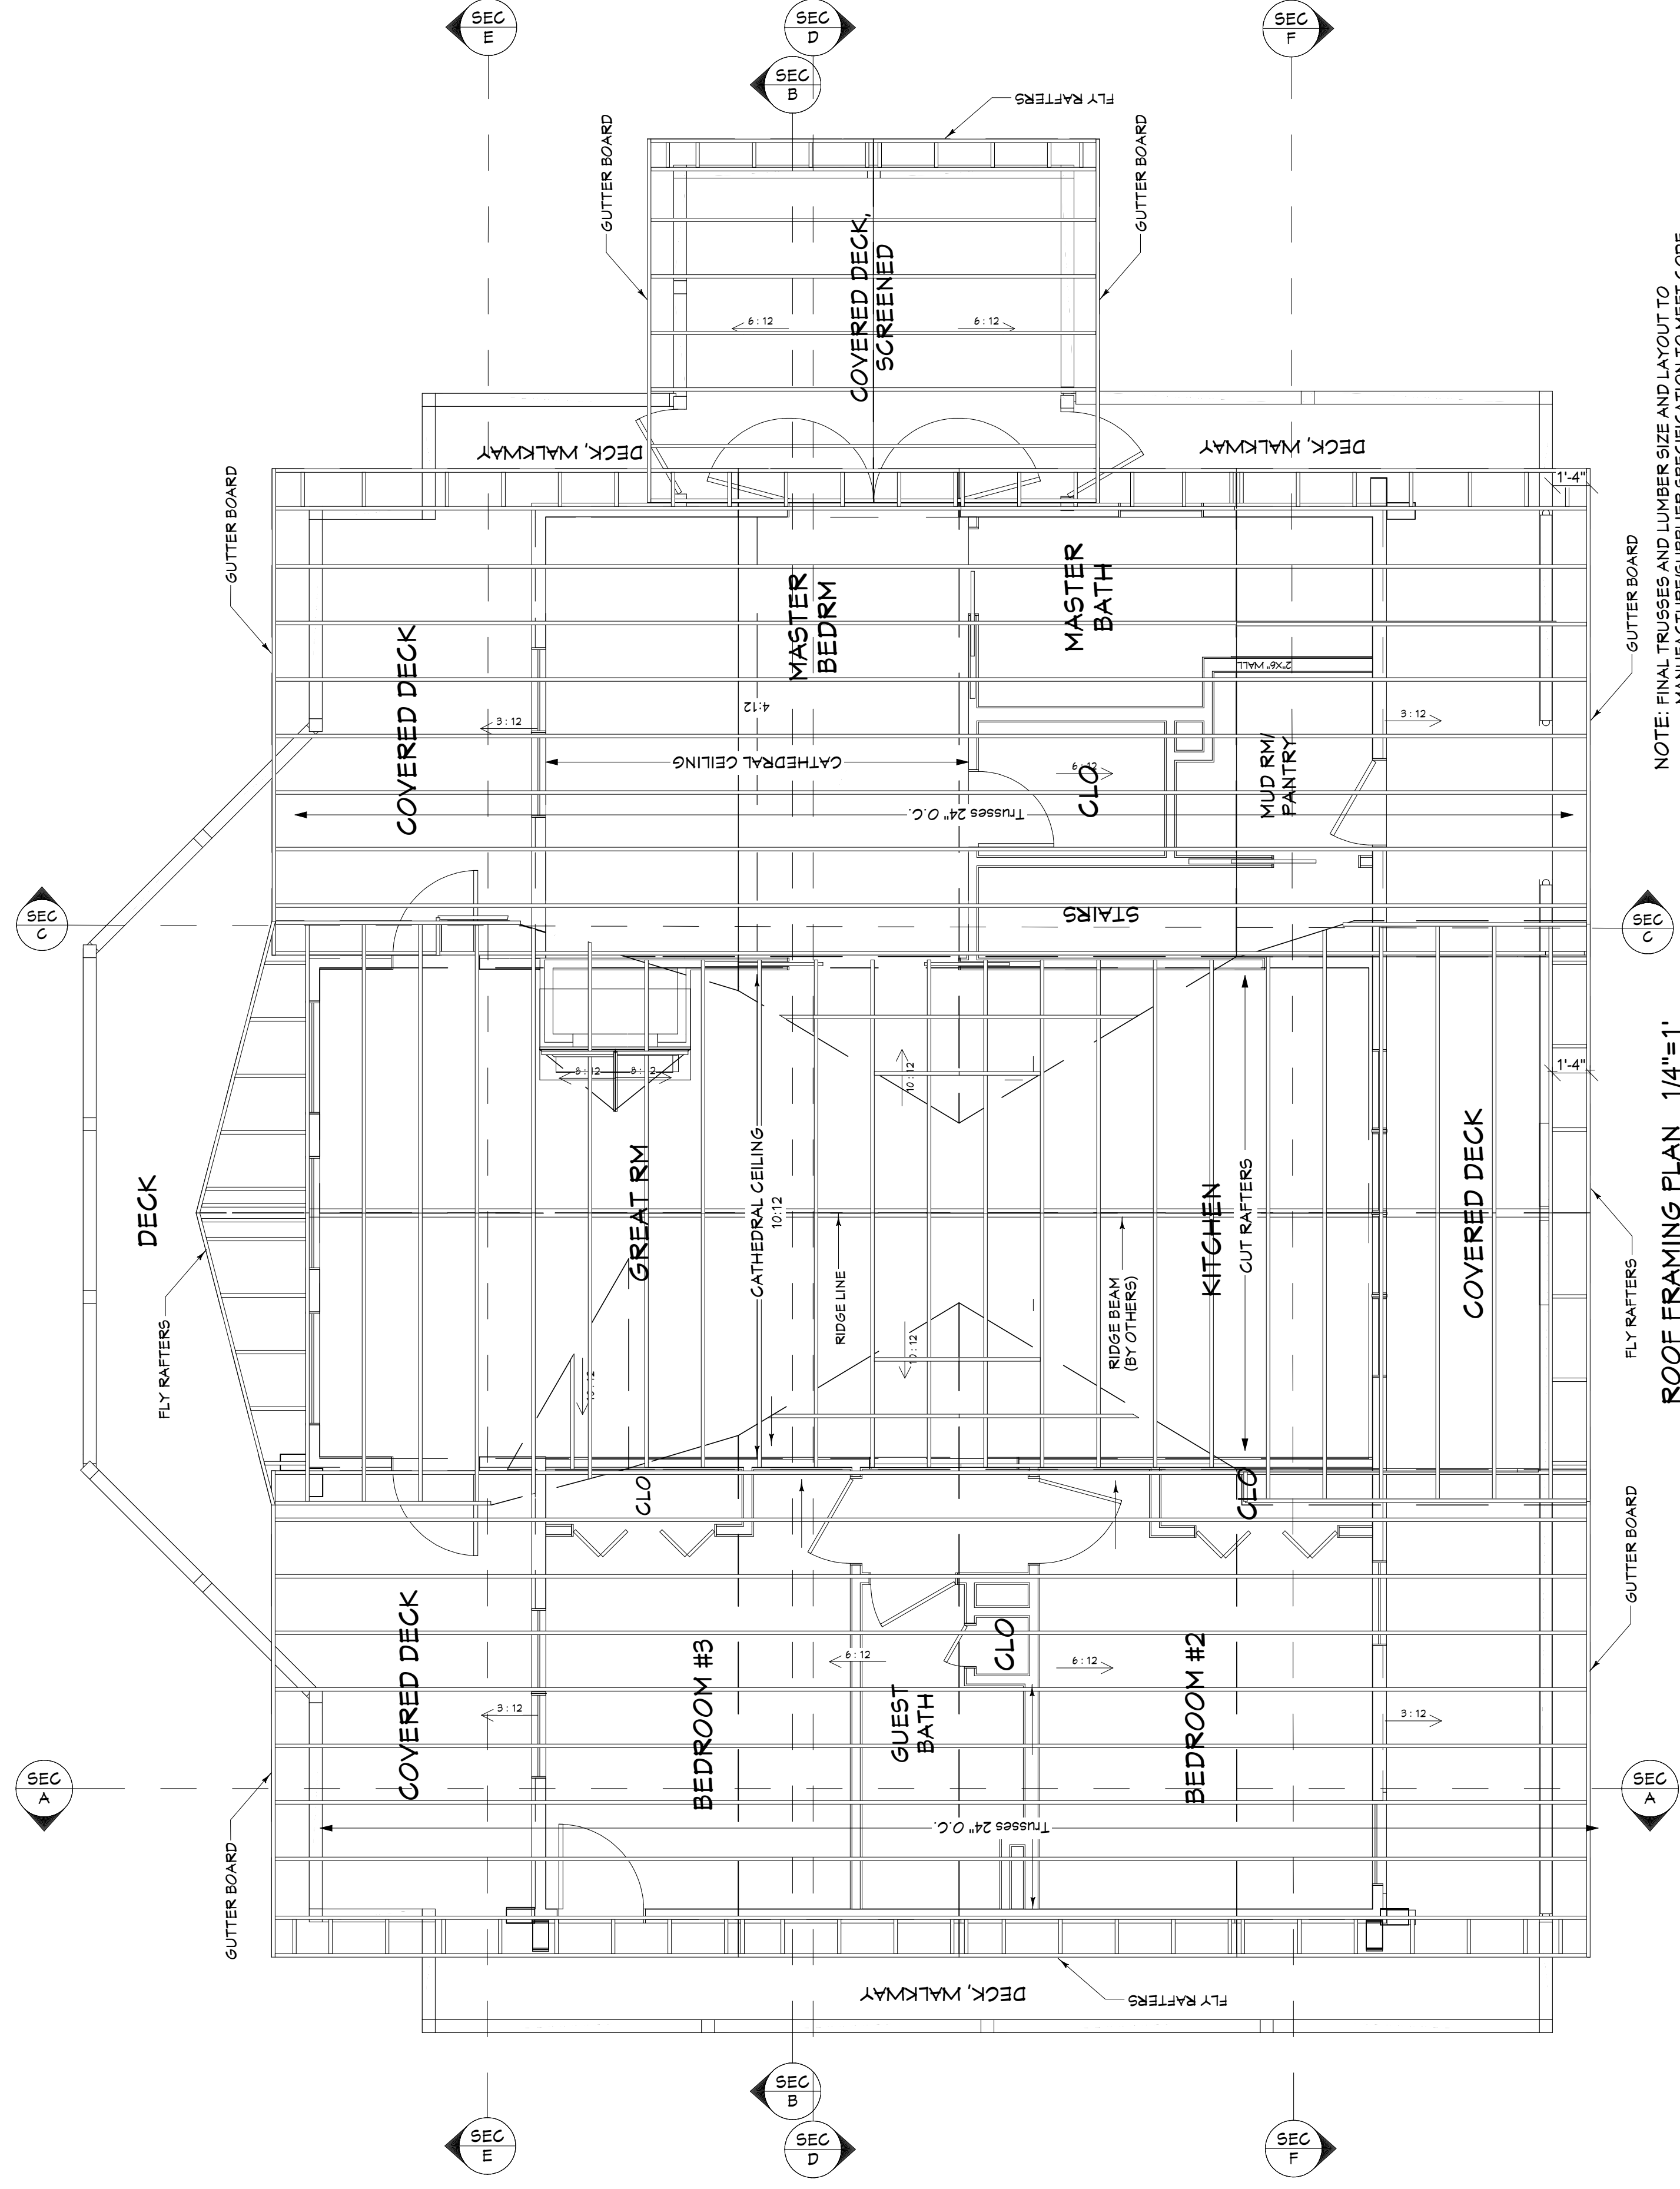

NOTE: FINAL JOIST SIZE AND LAYOUT TO MANUFACTURER/SUPPLIER SPECIFICATIONS

These drawings have been prepared for the purpose of communicating the design and obtaining necessary building permits. It is the responsibility of the builder to execute the design in a structurally sound manner and to abide by all local building codes.

Home Design / Building Management
Kenneth L. Thompson
604 A St. * Staunton, Va.24401
540-280 4059


CHASE AND
TONYA TUNNELL
LOG HOME PLAN

FLOOR FRAMING
ROOF FRAMING

Approved by
Insp.
Date:

SCALE: SEE VIEW
Aug.6,2021
DRAWN BY: KLT

Sheet No.
5

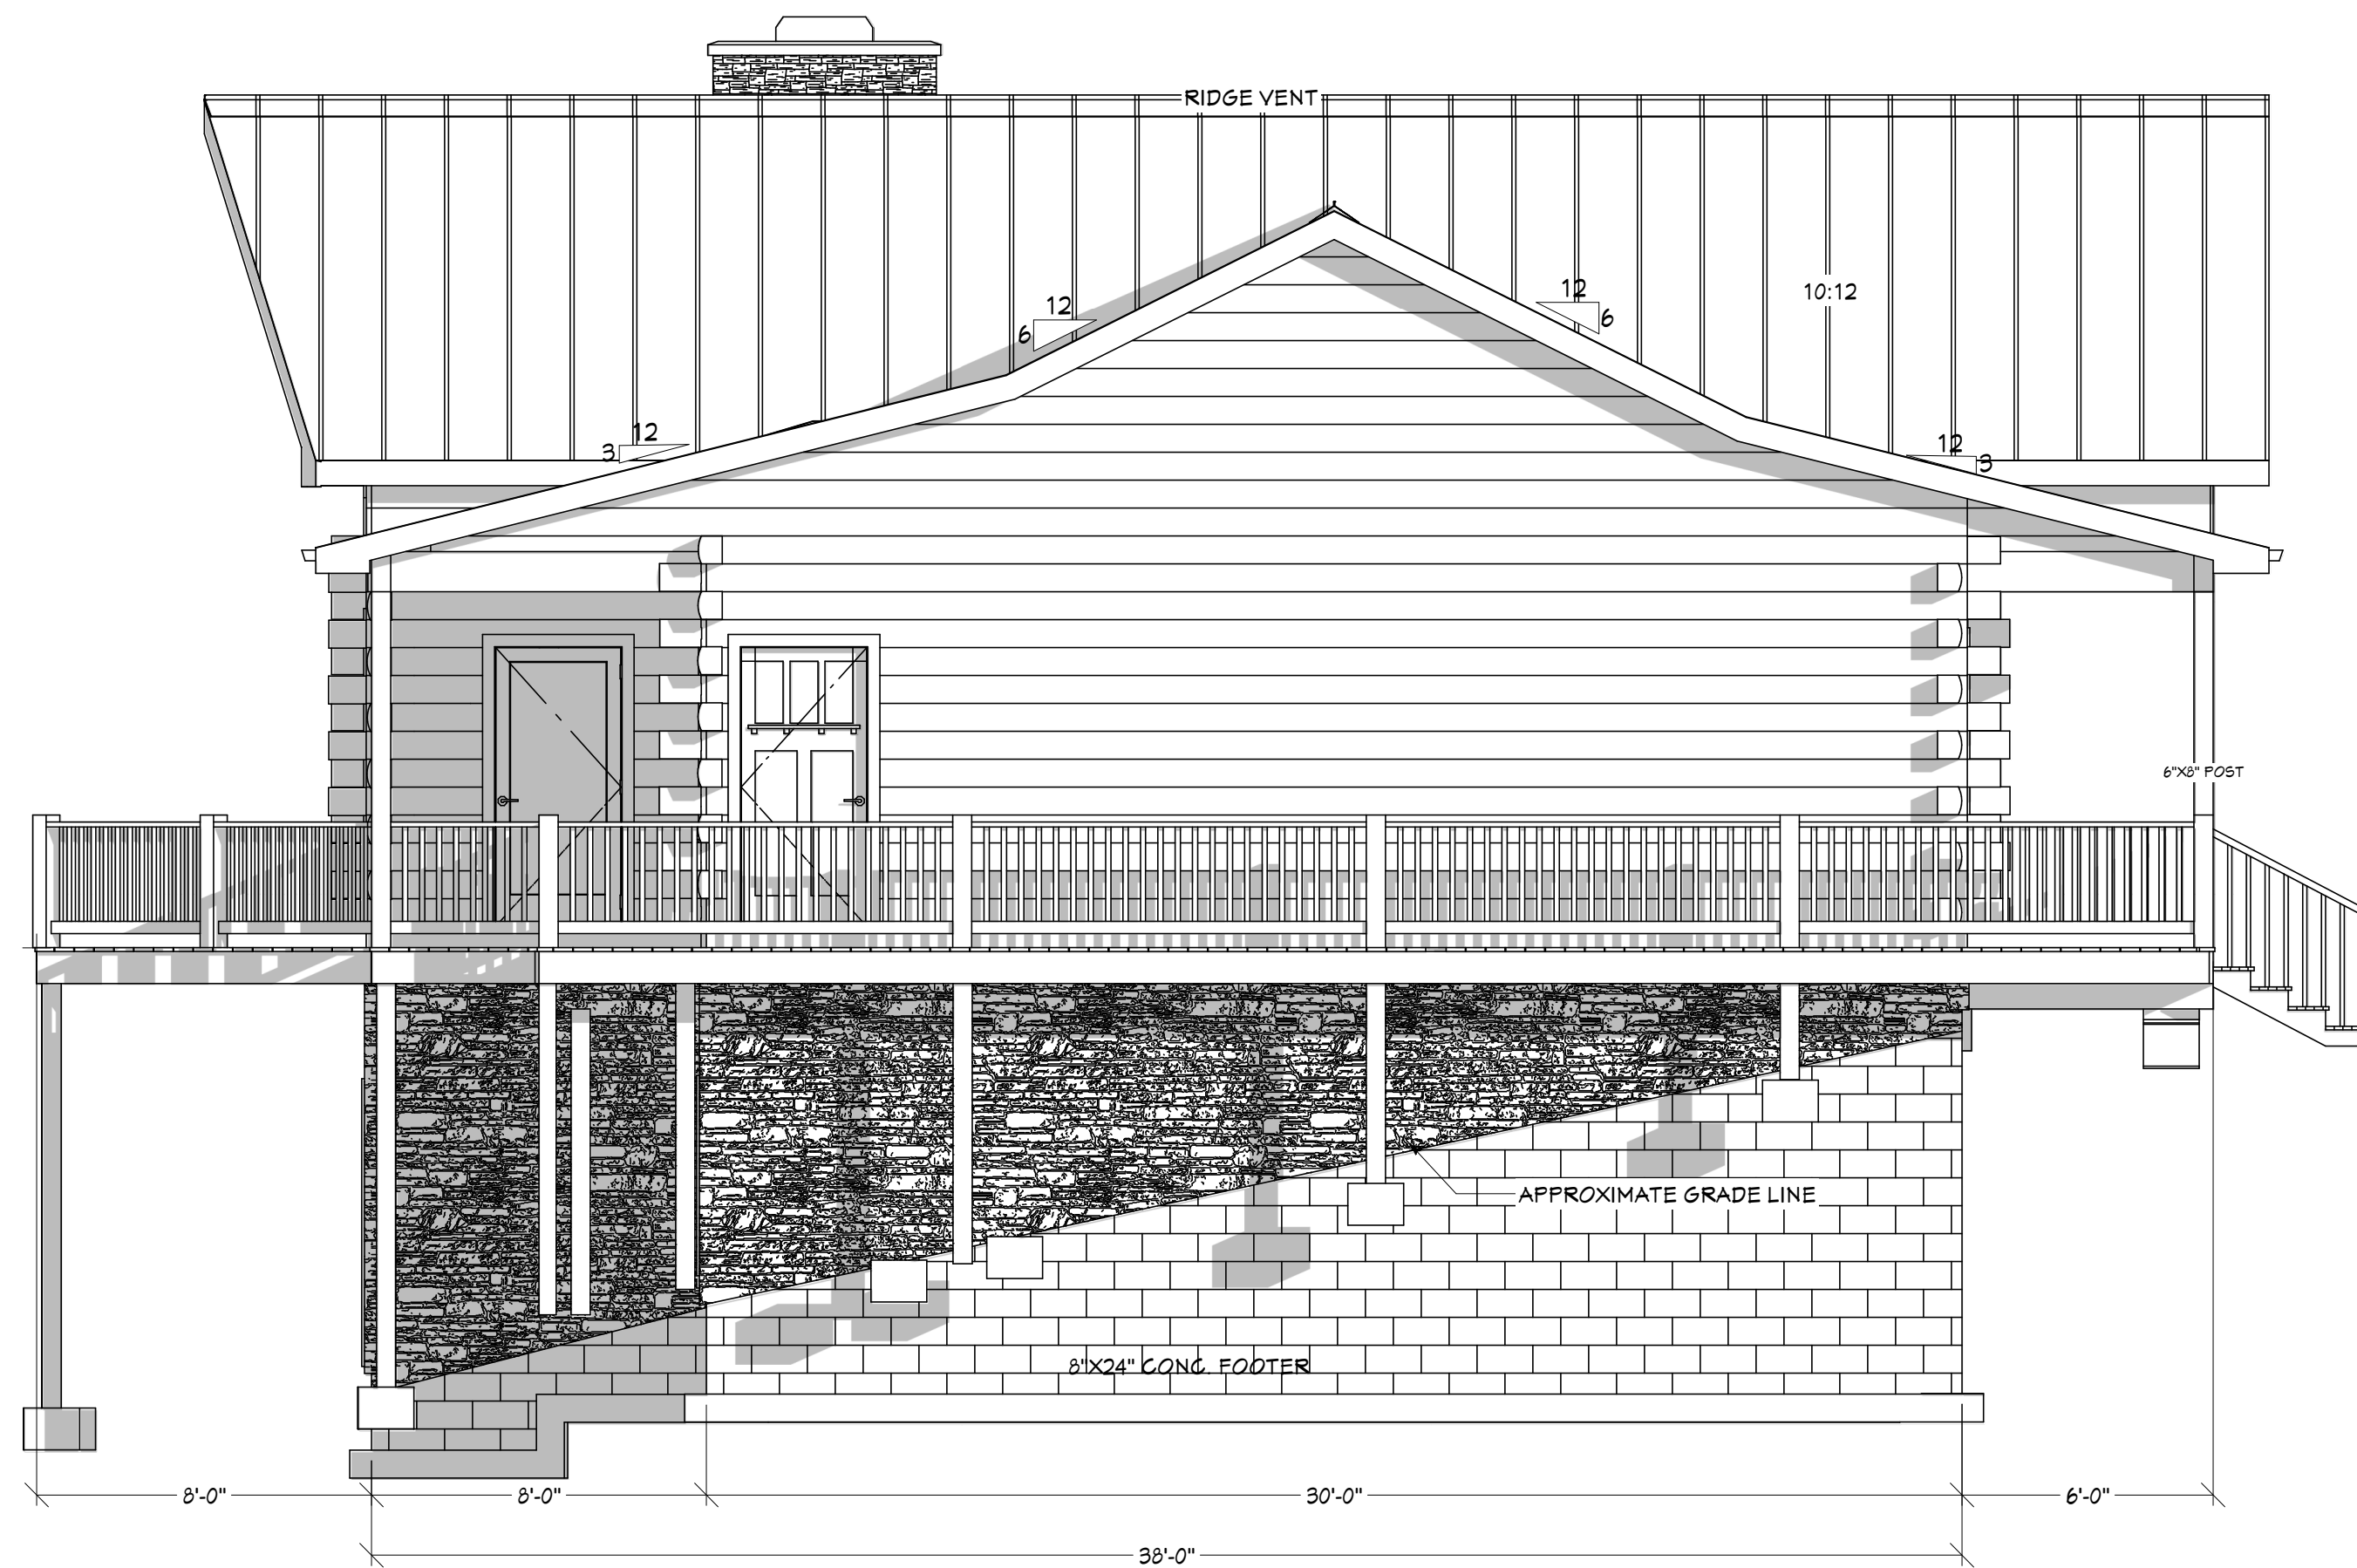

LEFT ELEVATION 1/4"=1'







REAR ELEVATION 1/4"=1'

 




RIGHT ELEVATION 1/4"=1'



FRONT ELEVATION 1/4"=1'

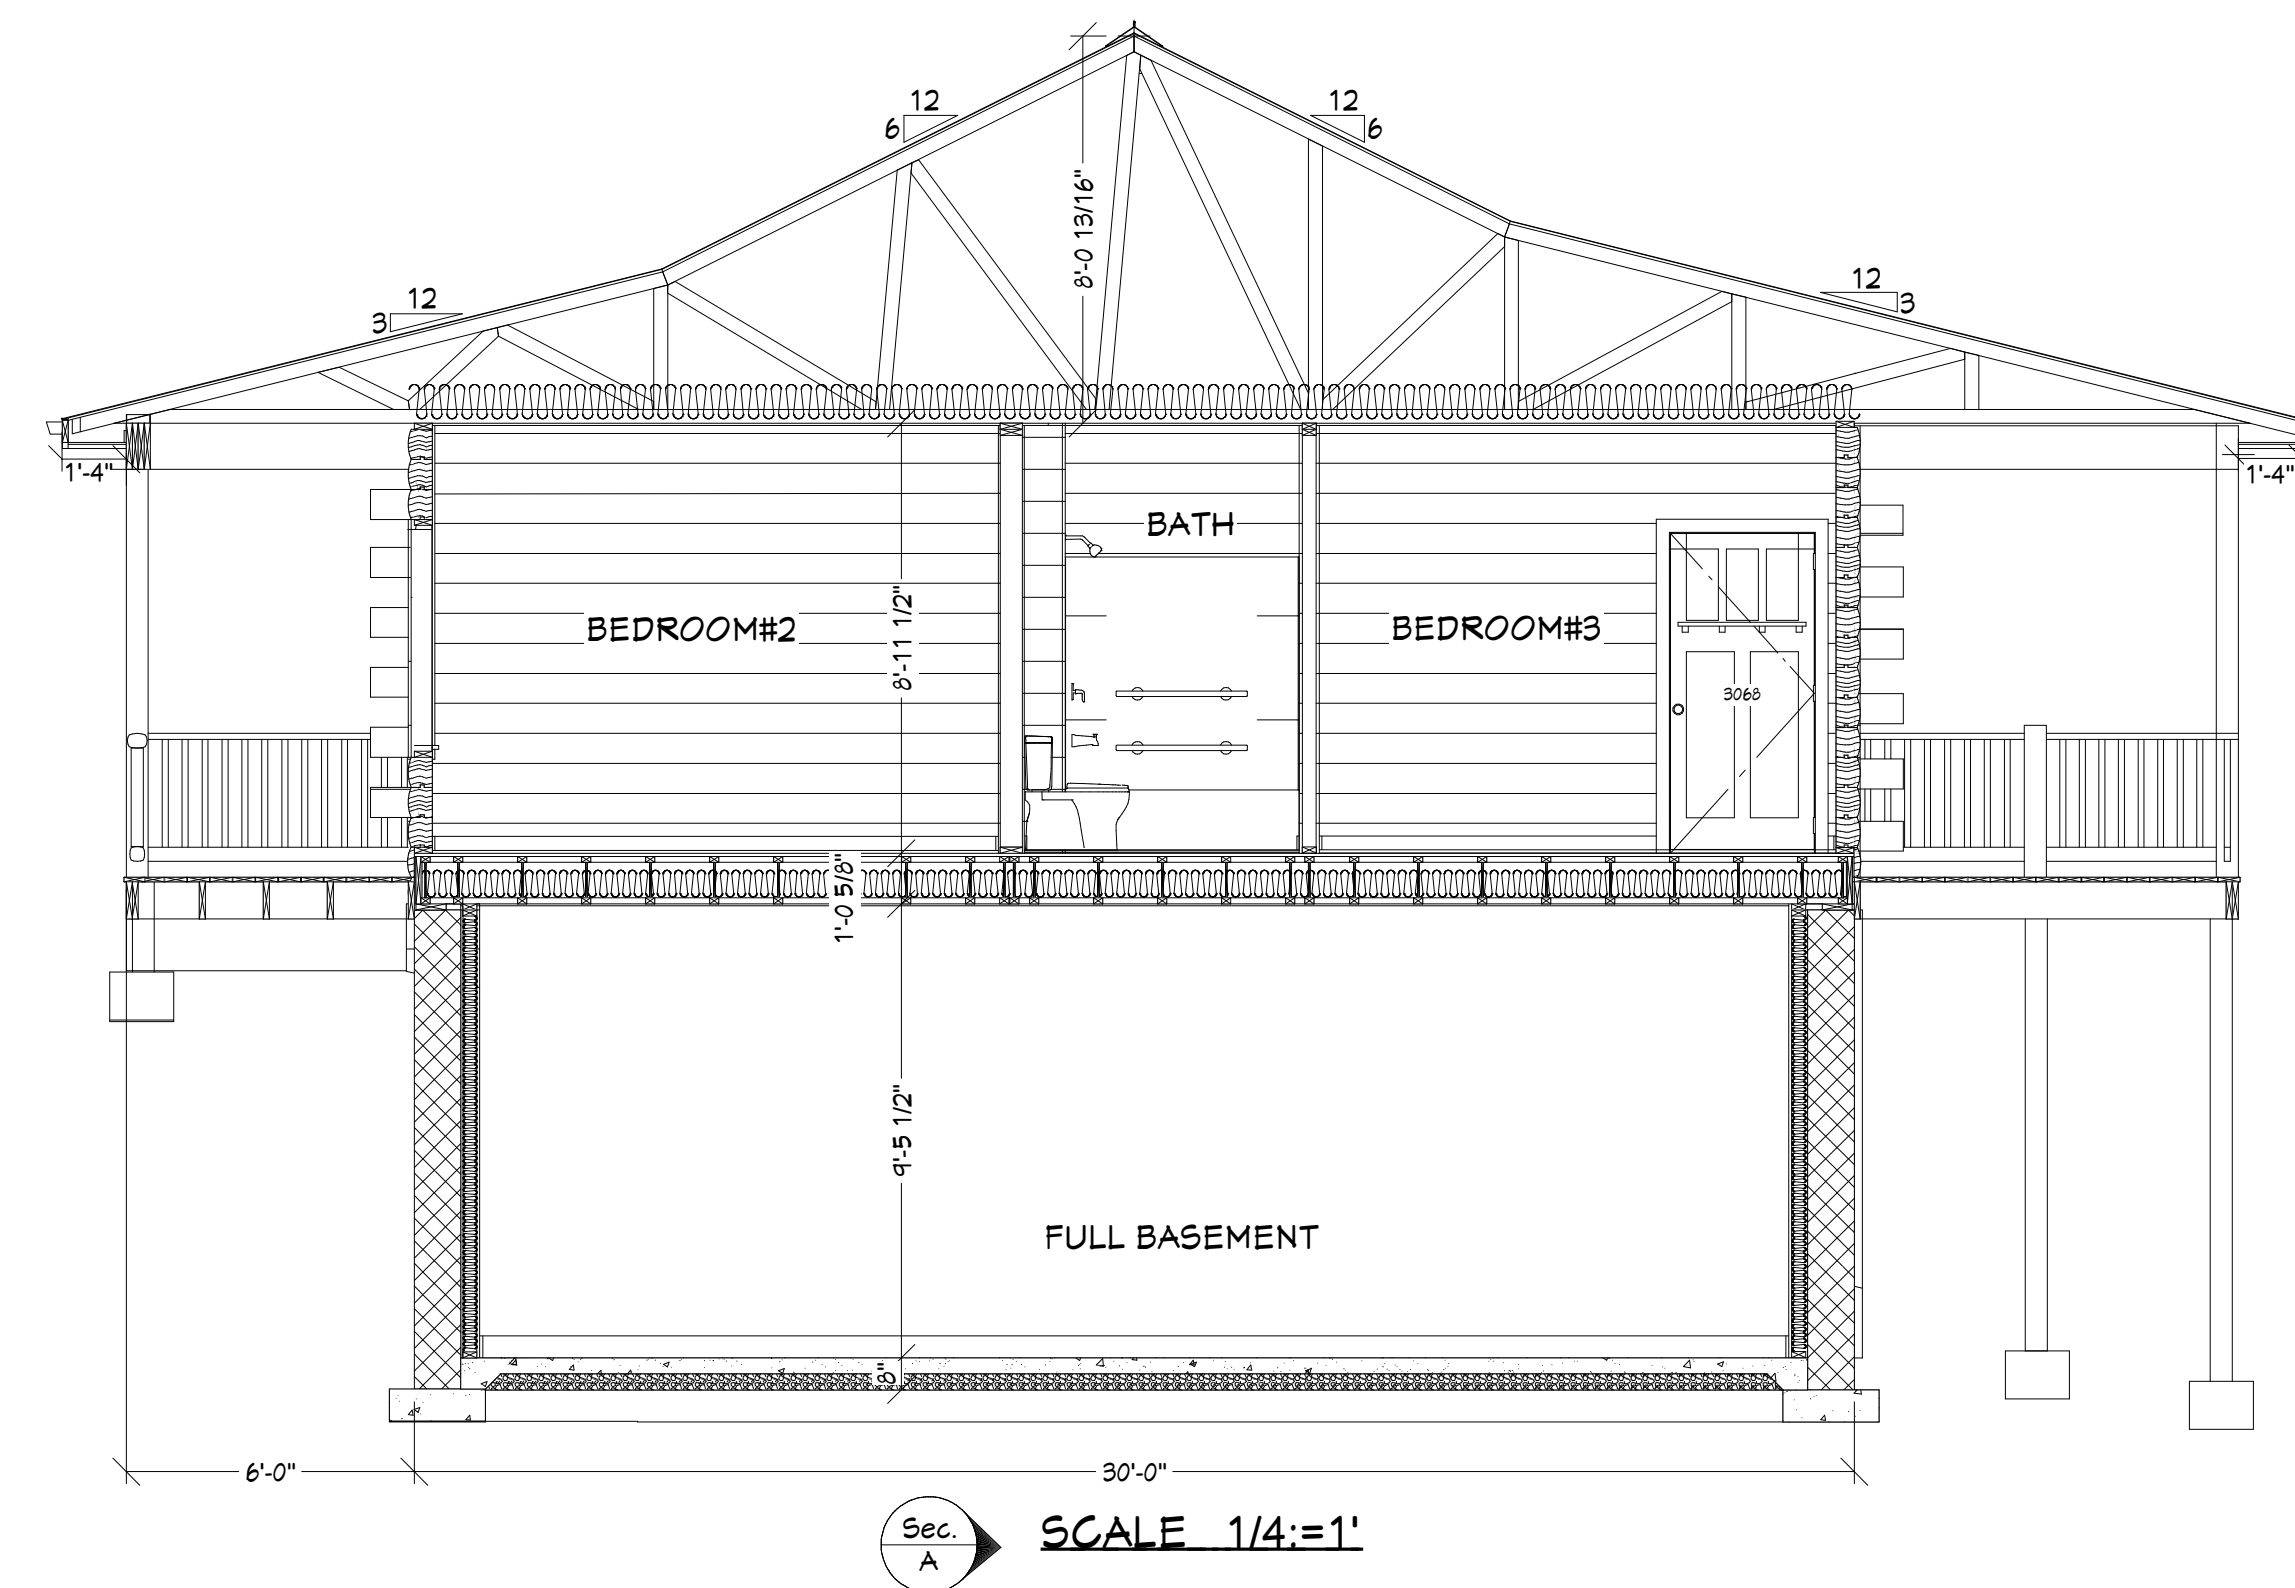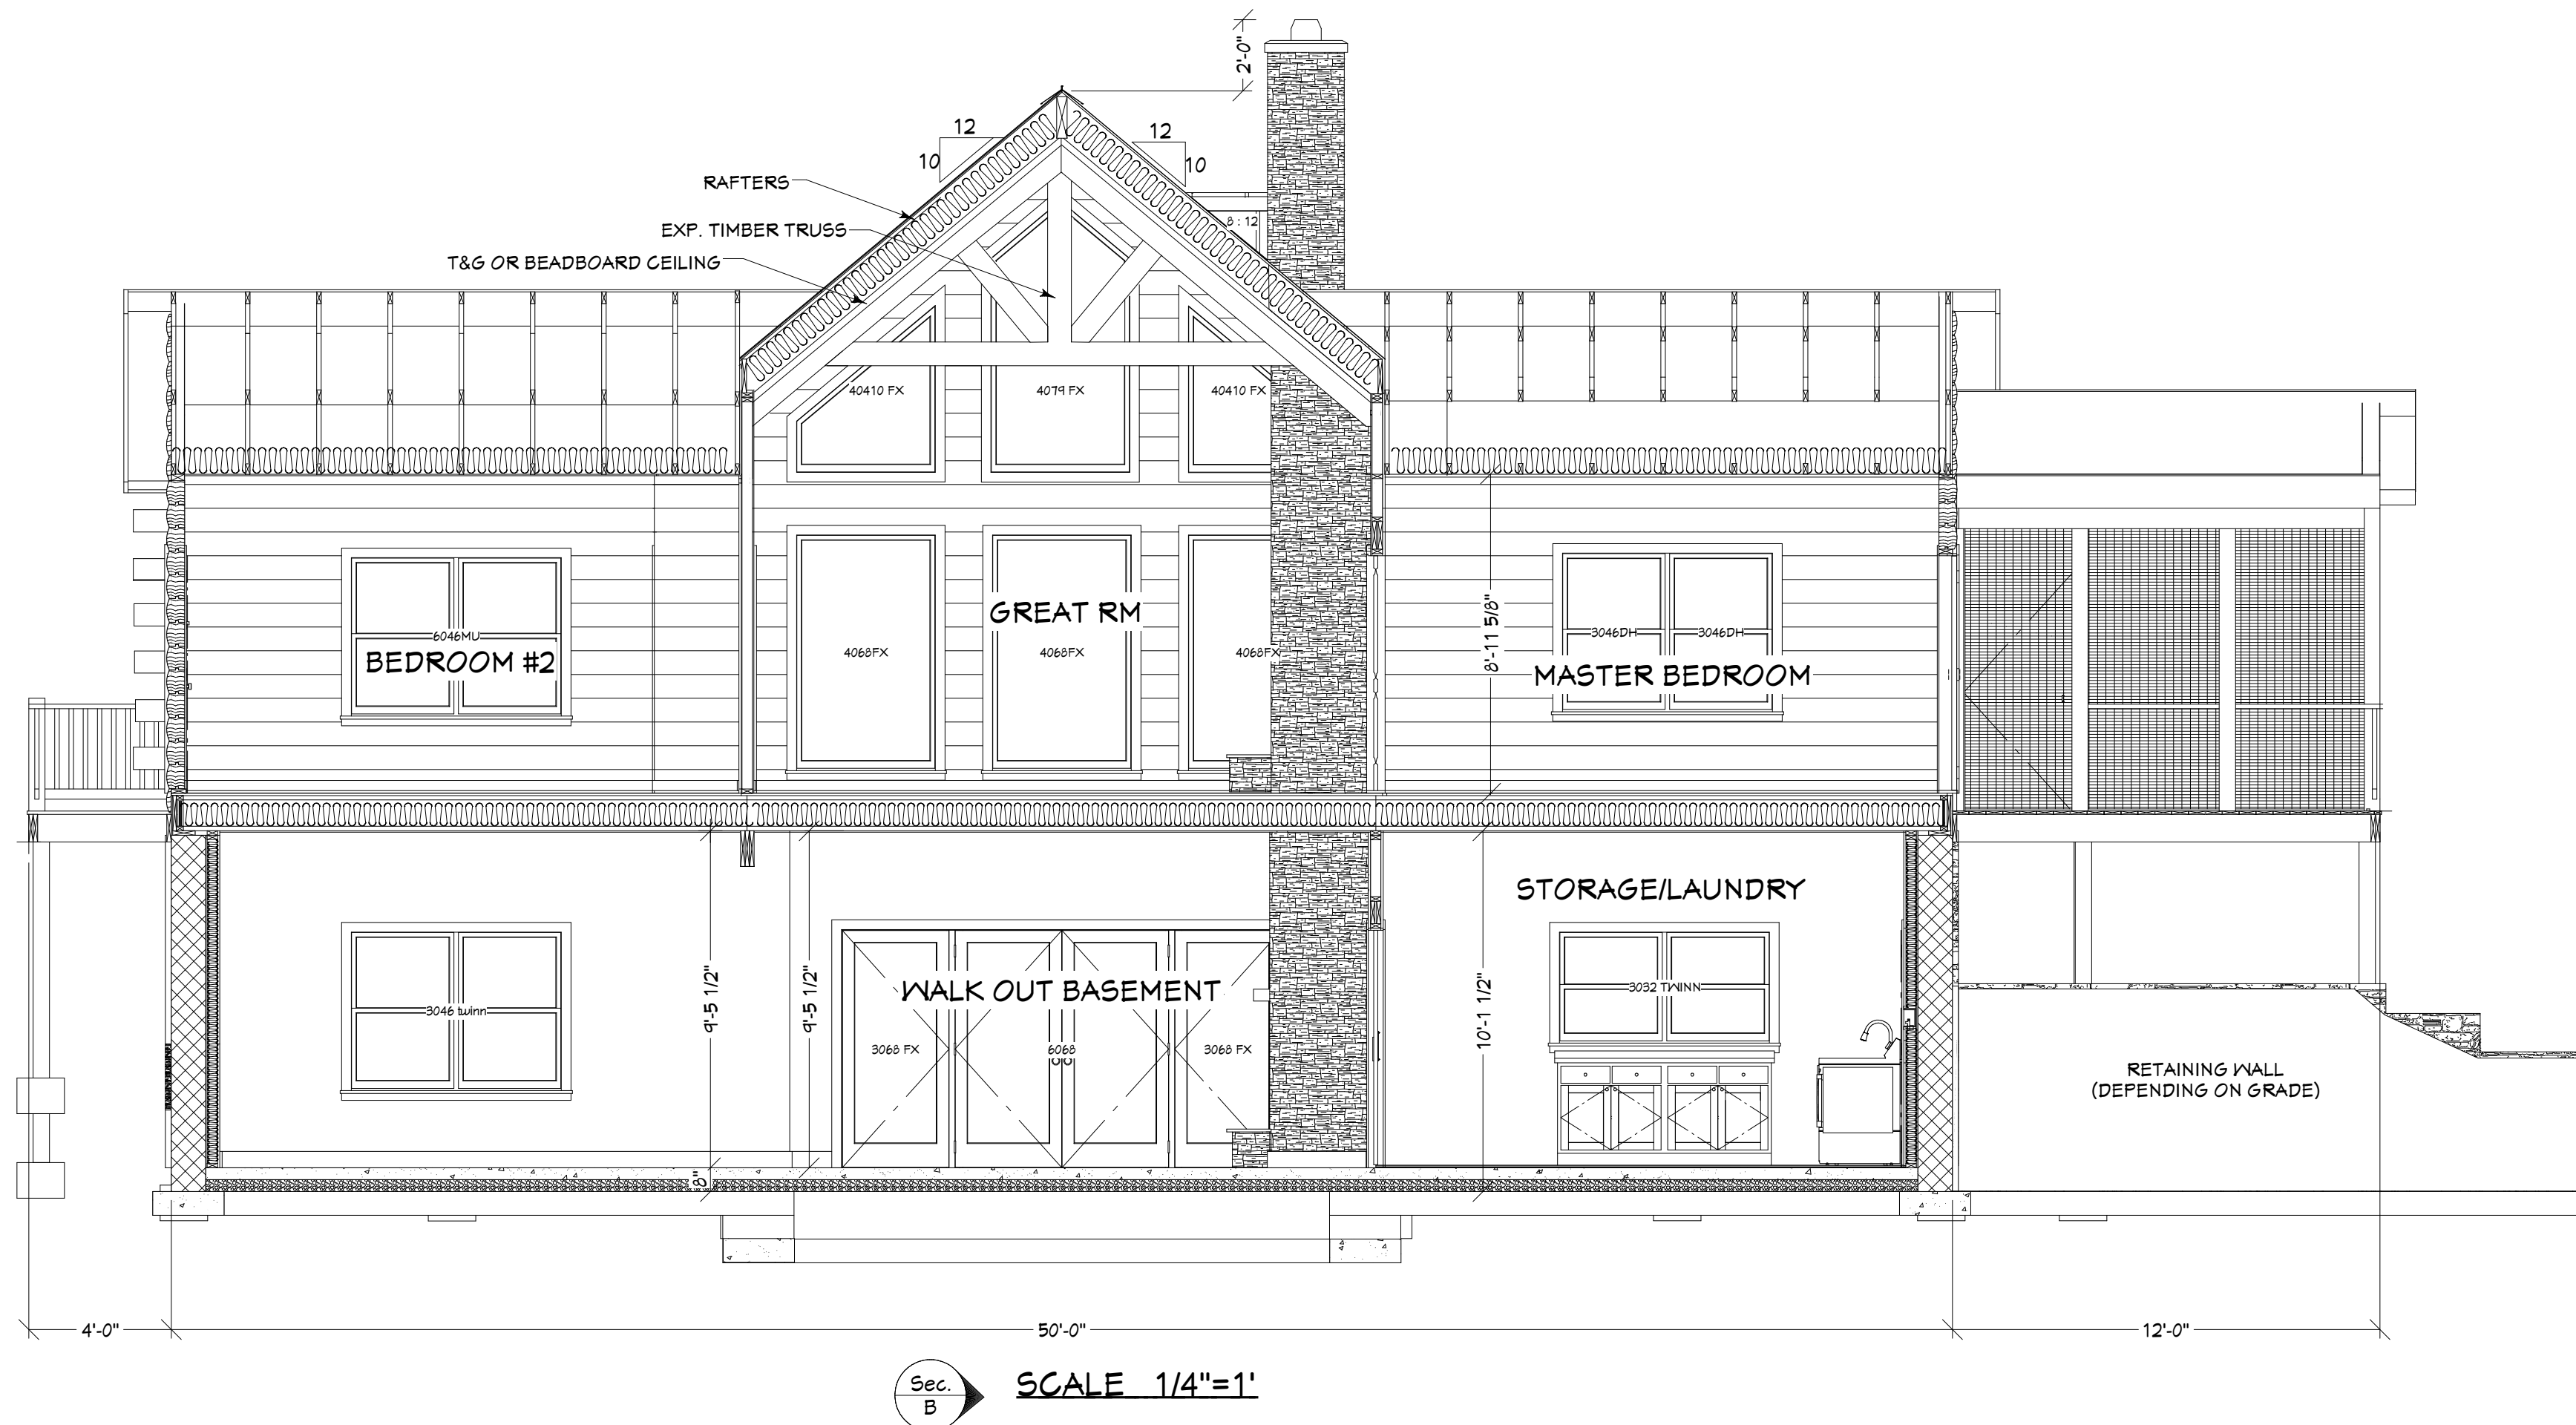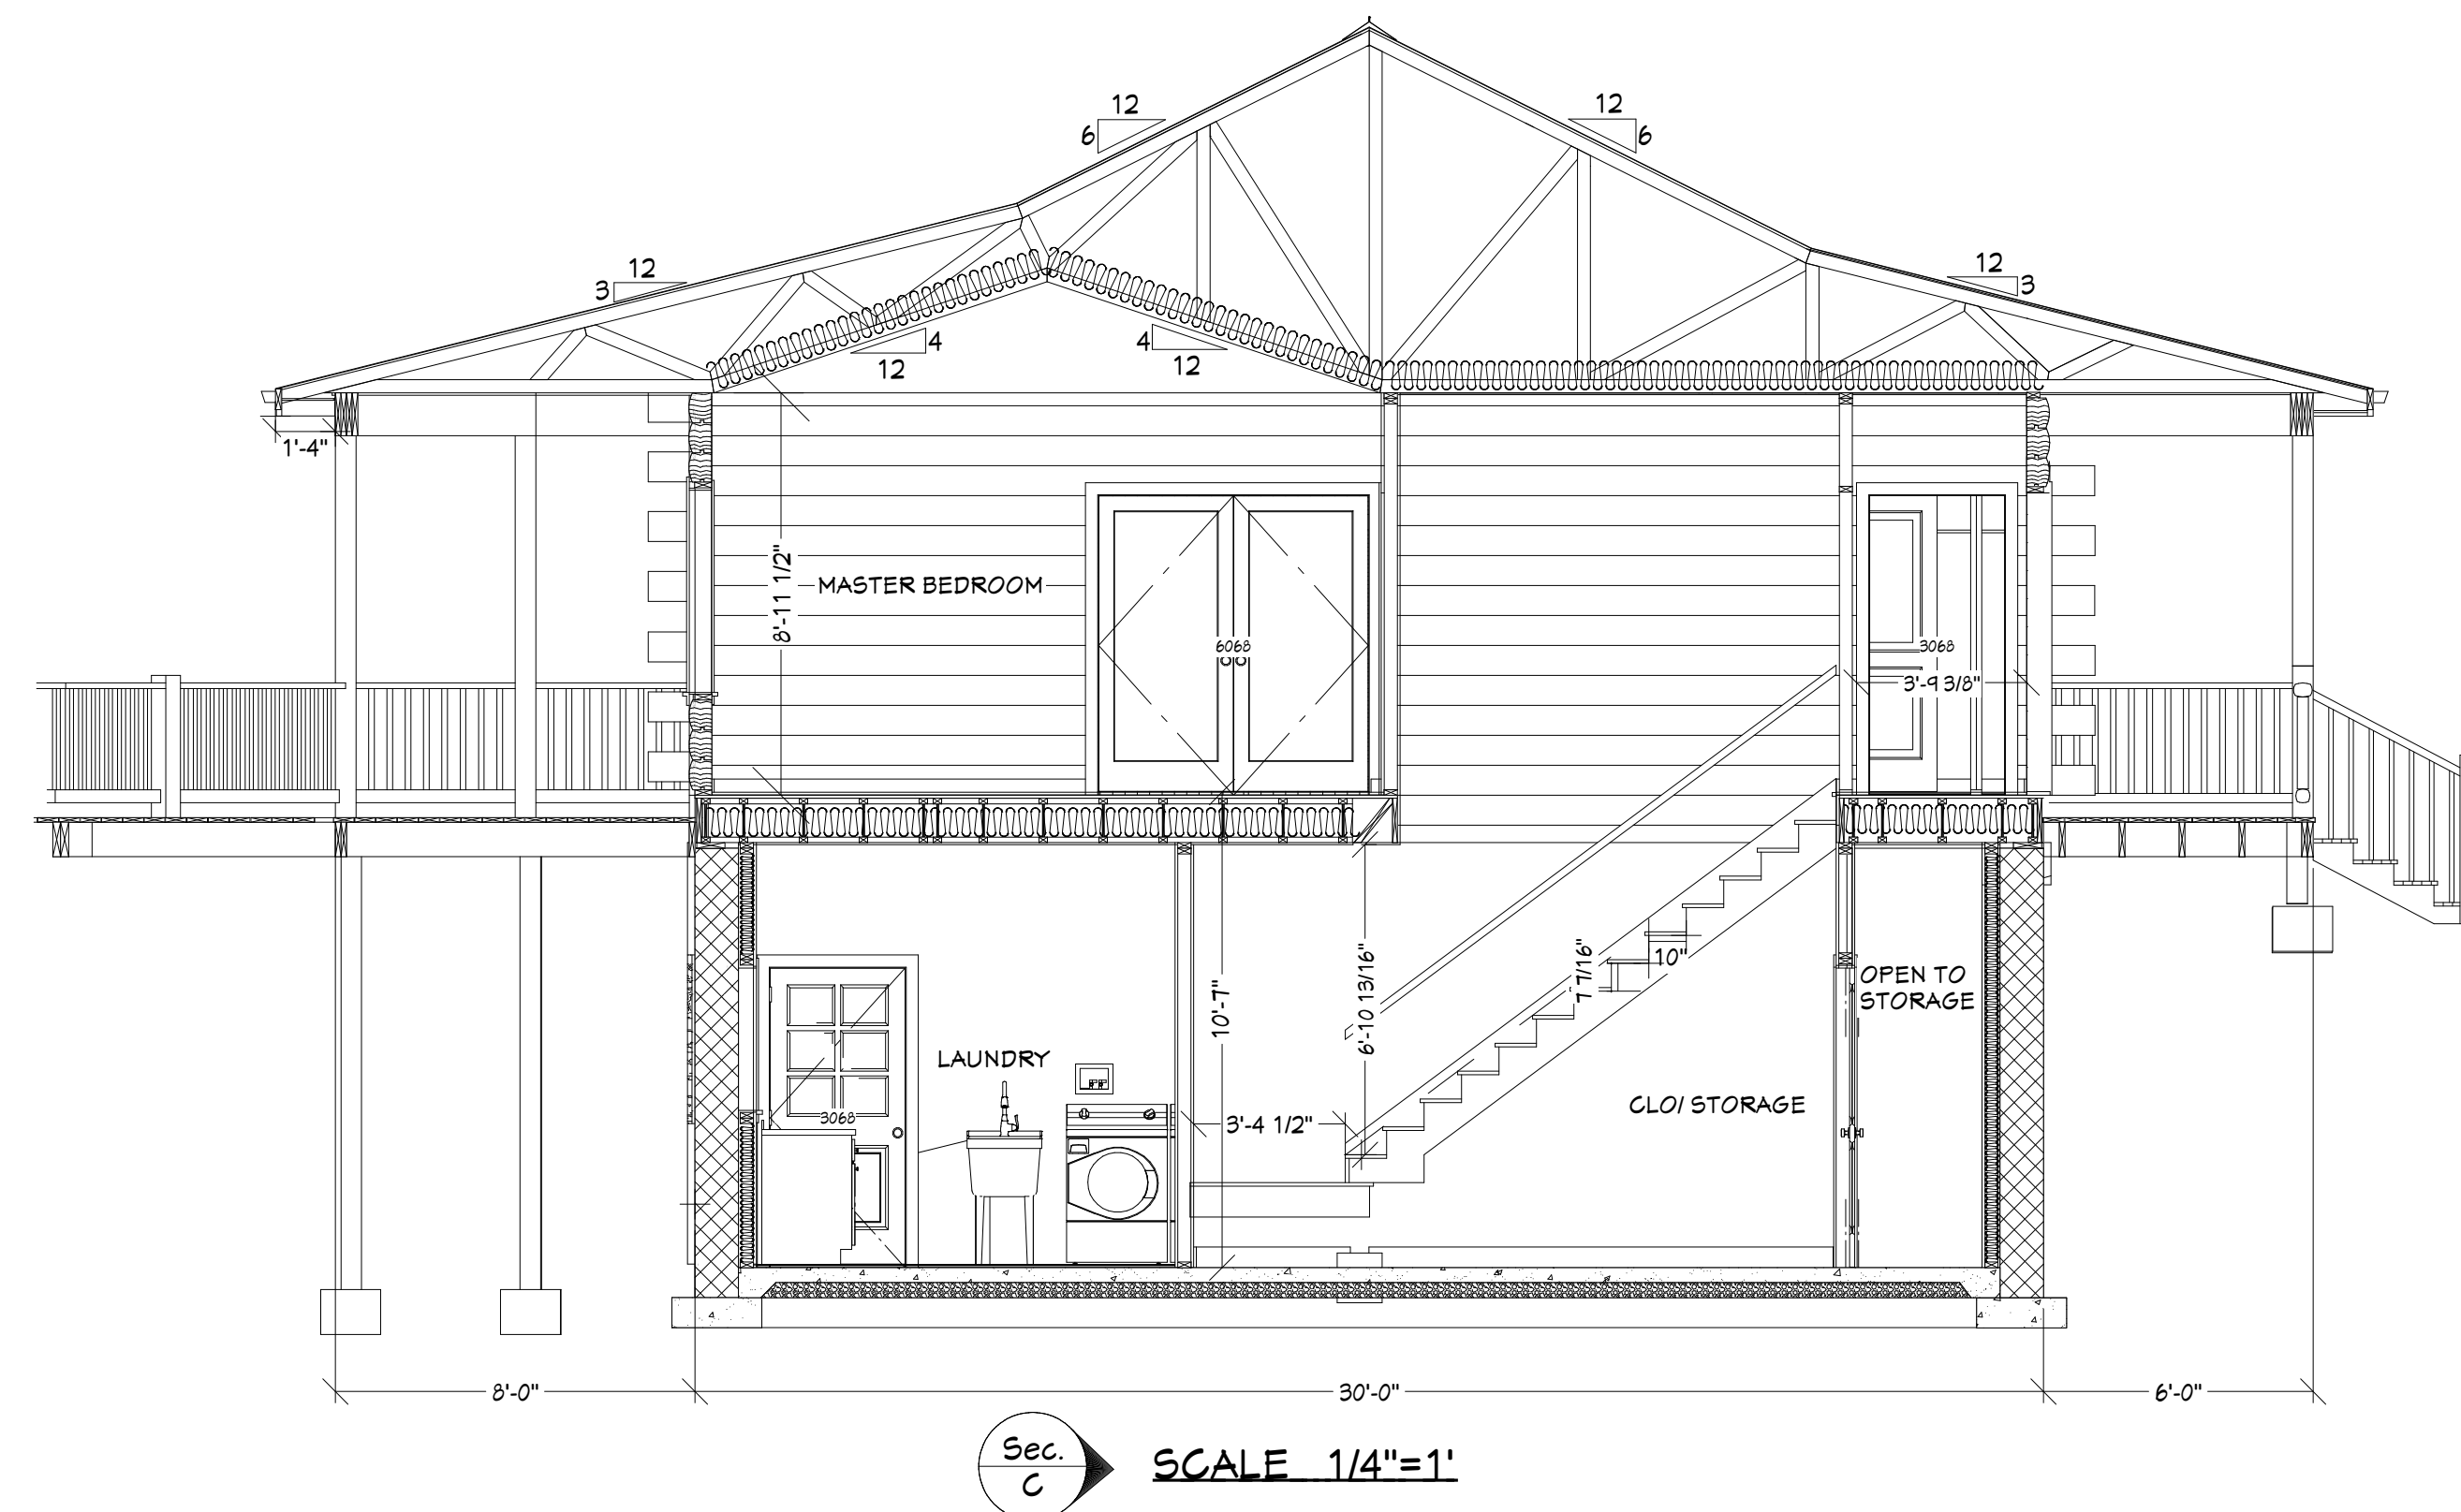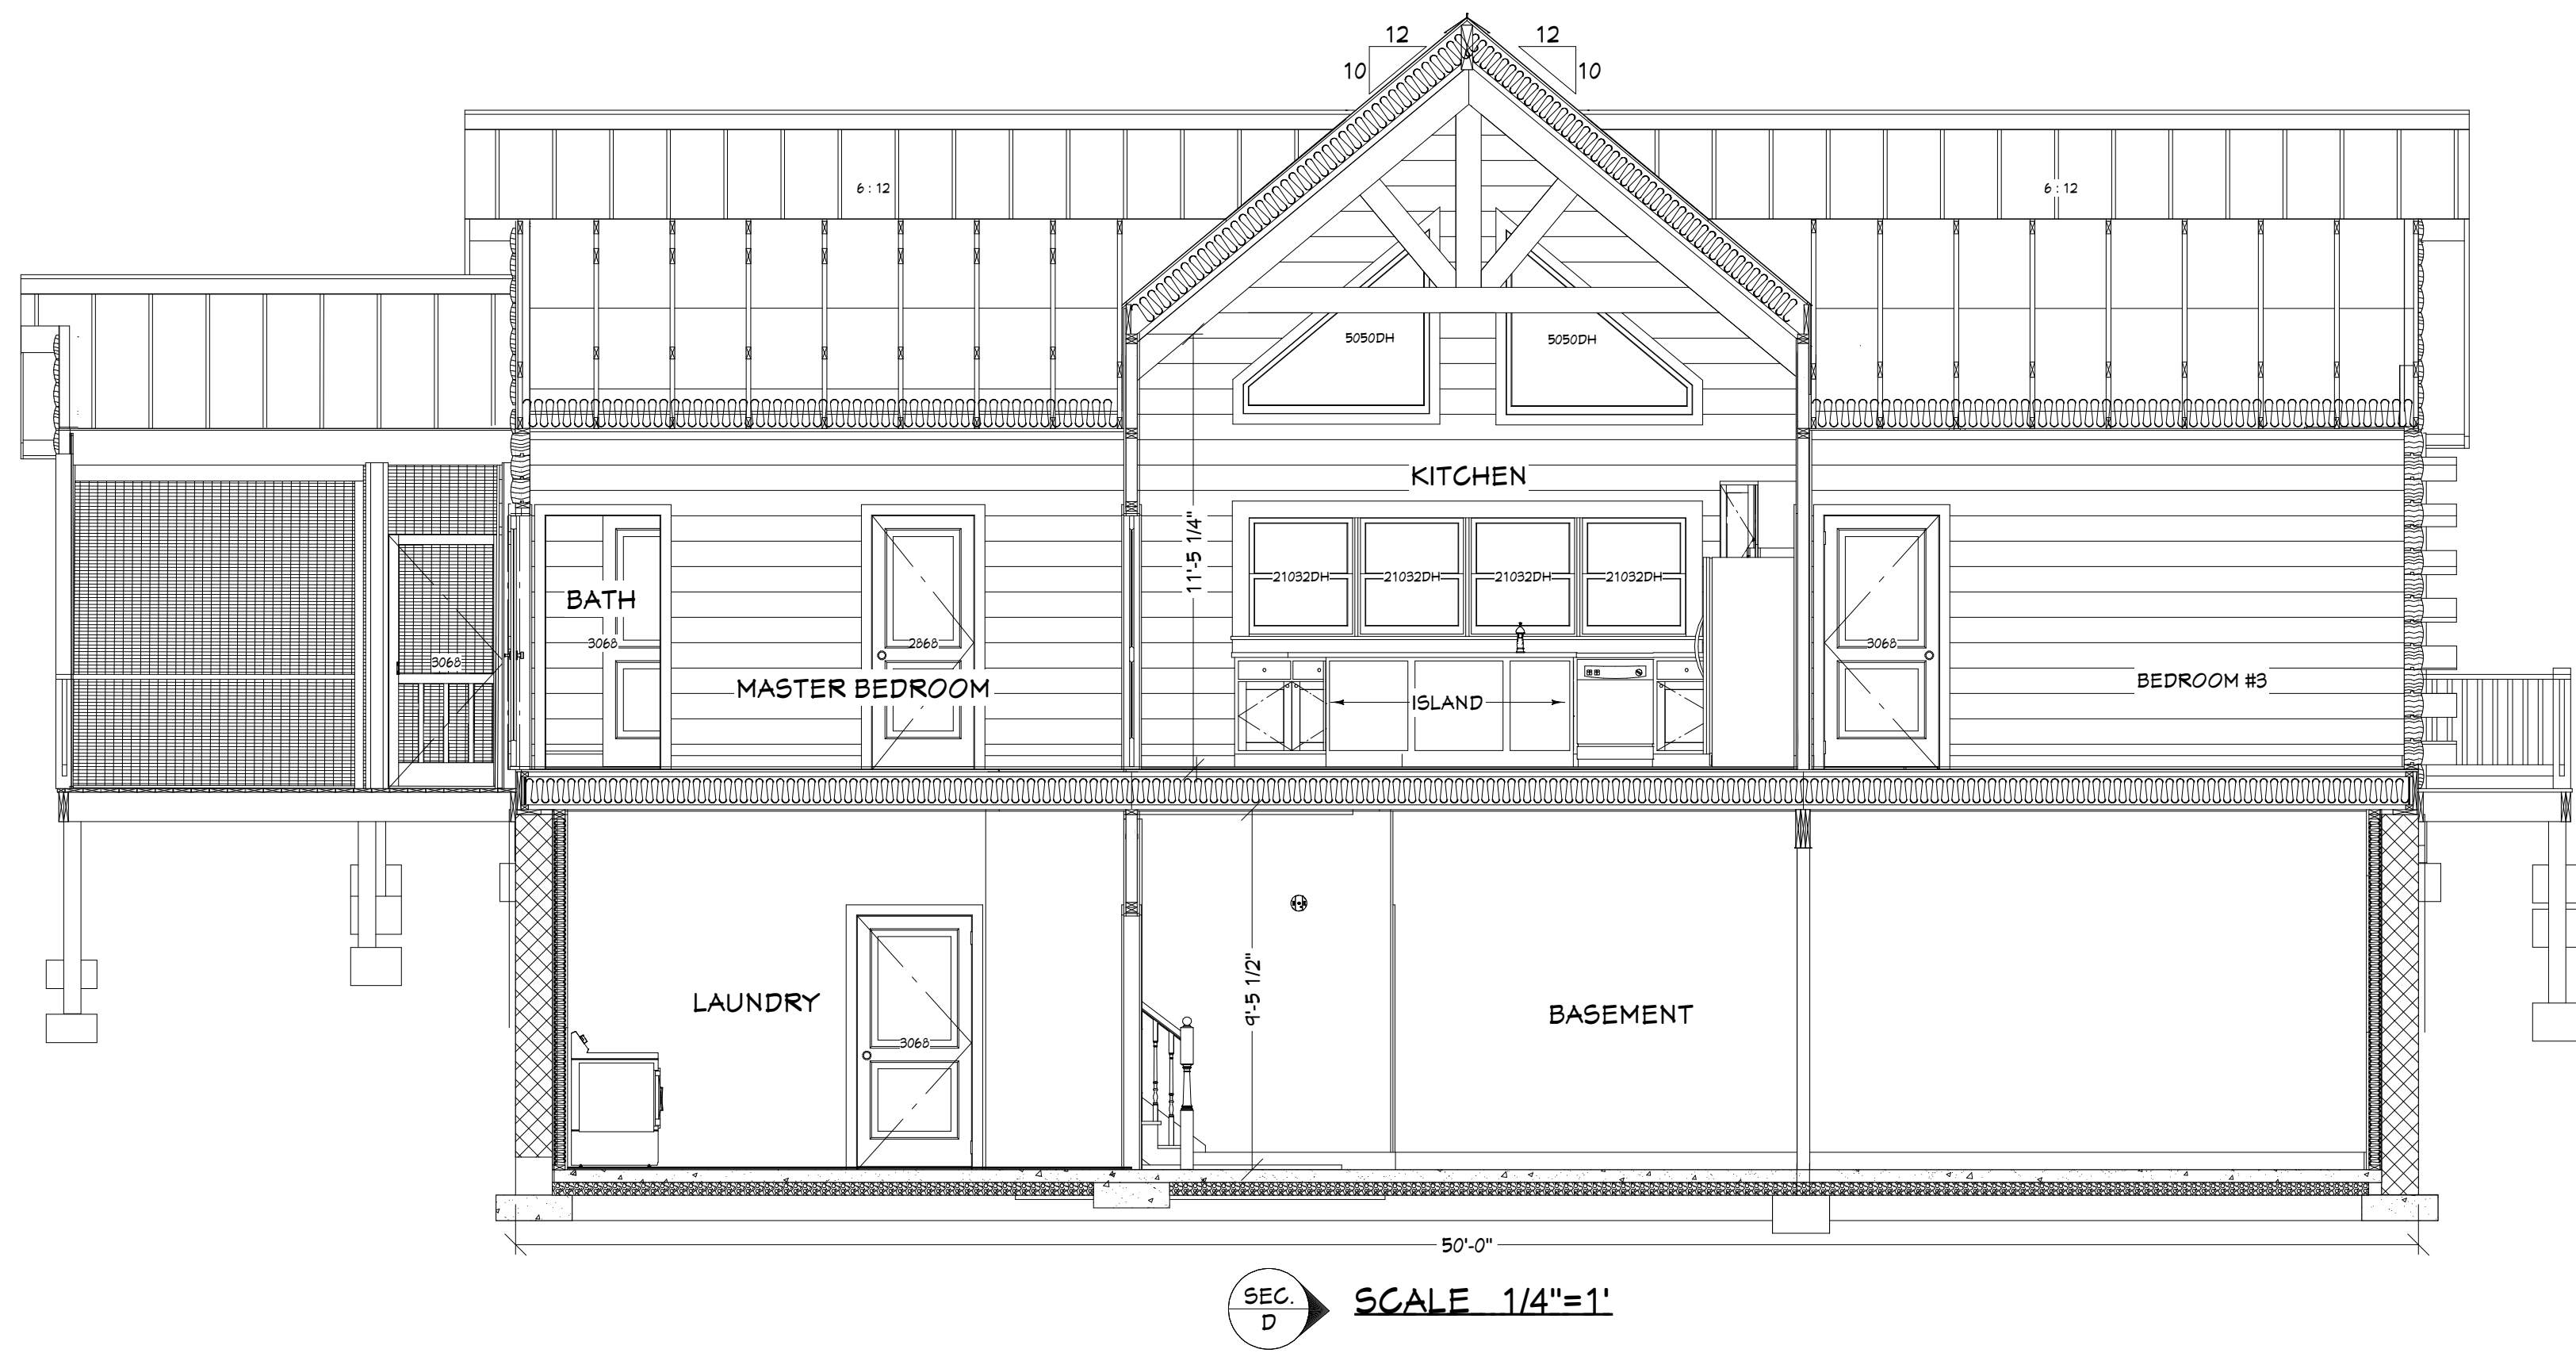

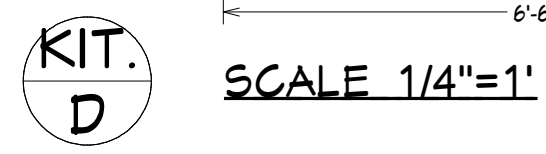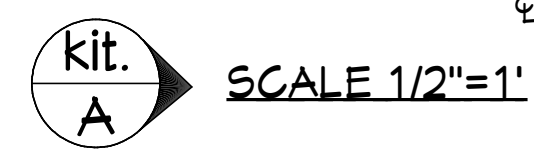

These drawings have been prepared for the purpose of communicating the design and obtaining necessary building permits. It is the responsibility of the builder to execute the design in a structurally sound manner and to abide by all local building codes.

TYPICAL WALL SECTION

R-38 MIN. CEILING INSULATION
VAPOR BARRIER
1/2" DRYWALL CEILING

METAL ROOFING
FELT PAPER
ICE & WATER SHIELD

1/2" EXTERIOR SHEATHING
2" X 4" TRUSSES 24" O.C.
1" CONT. AIR SPACE

DRIP EDGE
2" X 6" FASCIA

VENTED SOFFIT
2" X 2" SOFFIT NAILER

LOG WALL (14 COURSE)

3/4" T & G PLYWOOD SUBFLOOR

JOIST INSULATION

5/8" DRYWALL CEILING

WEB STIFFENER
RIM BOARD
1/2" EXTERIOR SHEATHING

2" STONE VENEER

2" X 4" TOP PLATE

GRADE

2" X 8" TREATED SILL PLATE
SILL SEAL
1/2" ANCHOR BOLTS 6" O.C.

3 1/2" WALL STUDS 16" O.C.
3 1/2" WALL INSULATION
VAPOR BARRIER
1/2" DRYWALL

2" X 4" TREATED
BOTTOM PLATE

4" CONCRETE FLOOR
W/ WIRE MESH


VAPOR BARRIER
4" GRAVEL BASE

12" MOD. CONCRETE BLOCK (15 COURSE)
W/ VERTICAL REINF. (IF REQUIRED)
DAMP PROOFING (TO GRADE)


8" X 24" CONT. CONCRETE FOOTING
RE-BAR (2)

4" DRAIN TILE
12" GRAVEL FILL

SCALE 3/4"=1'

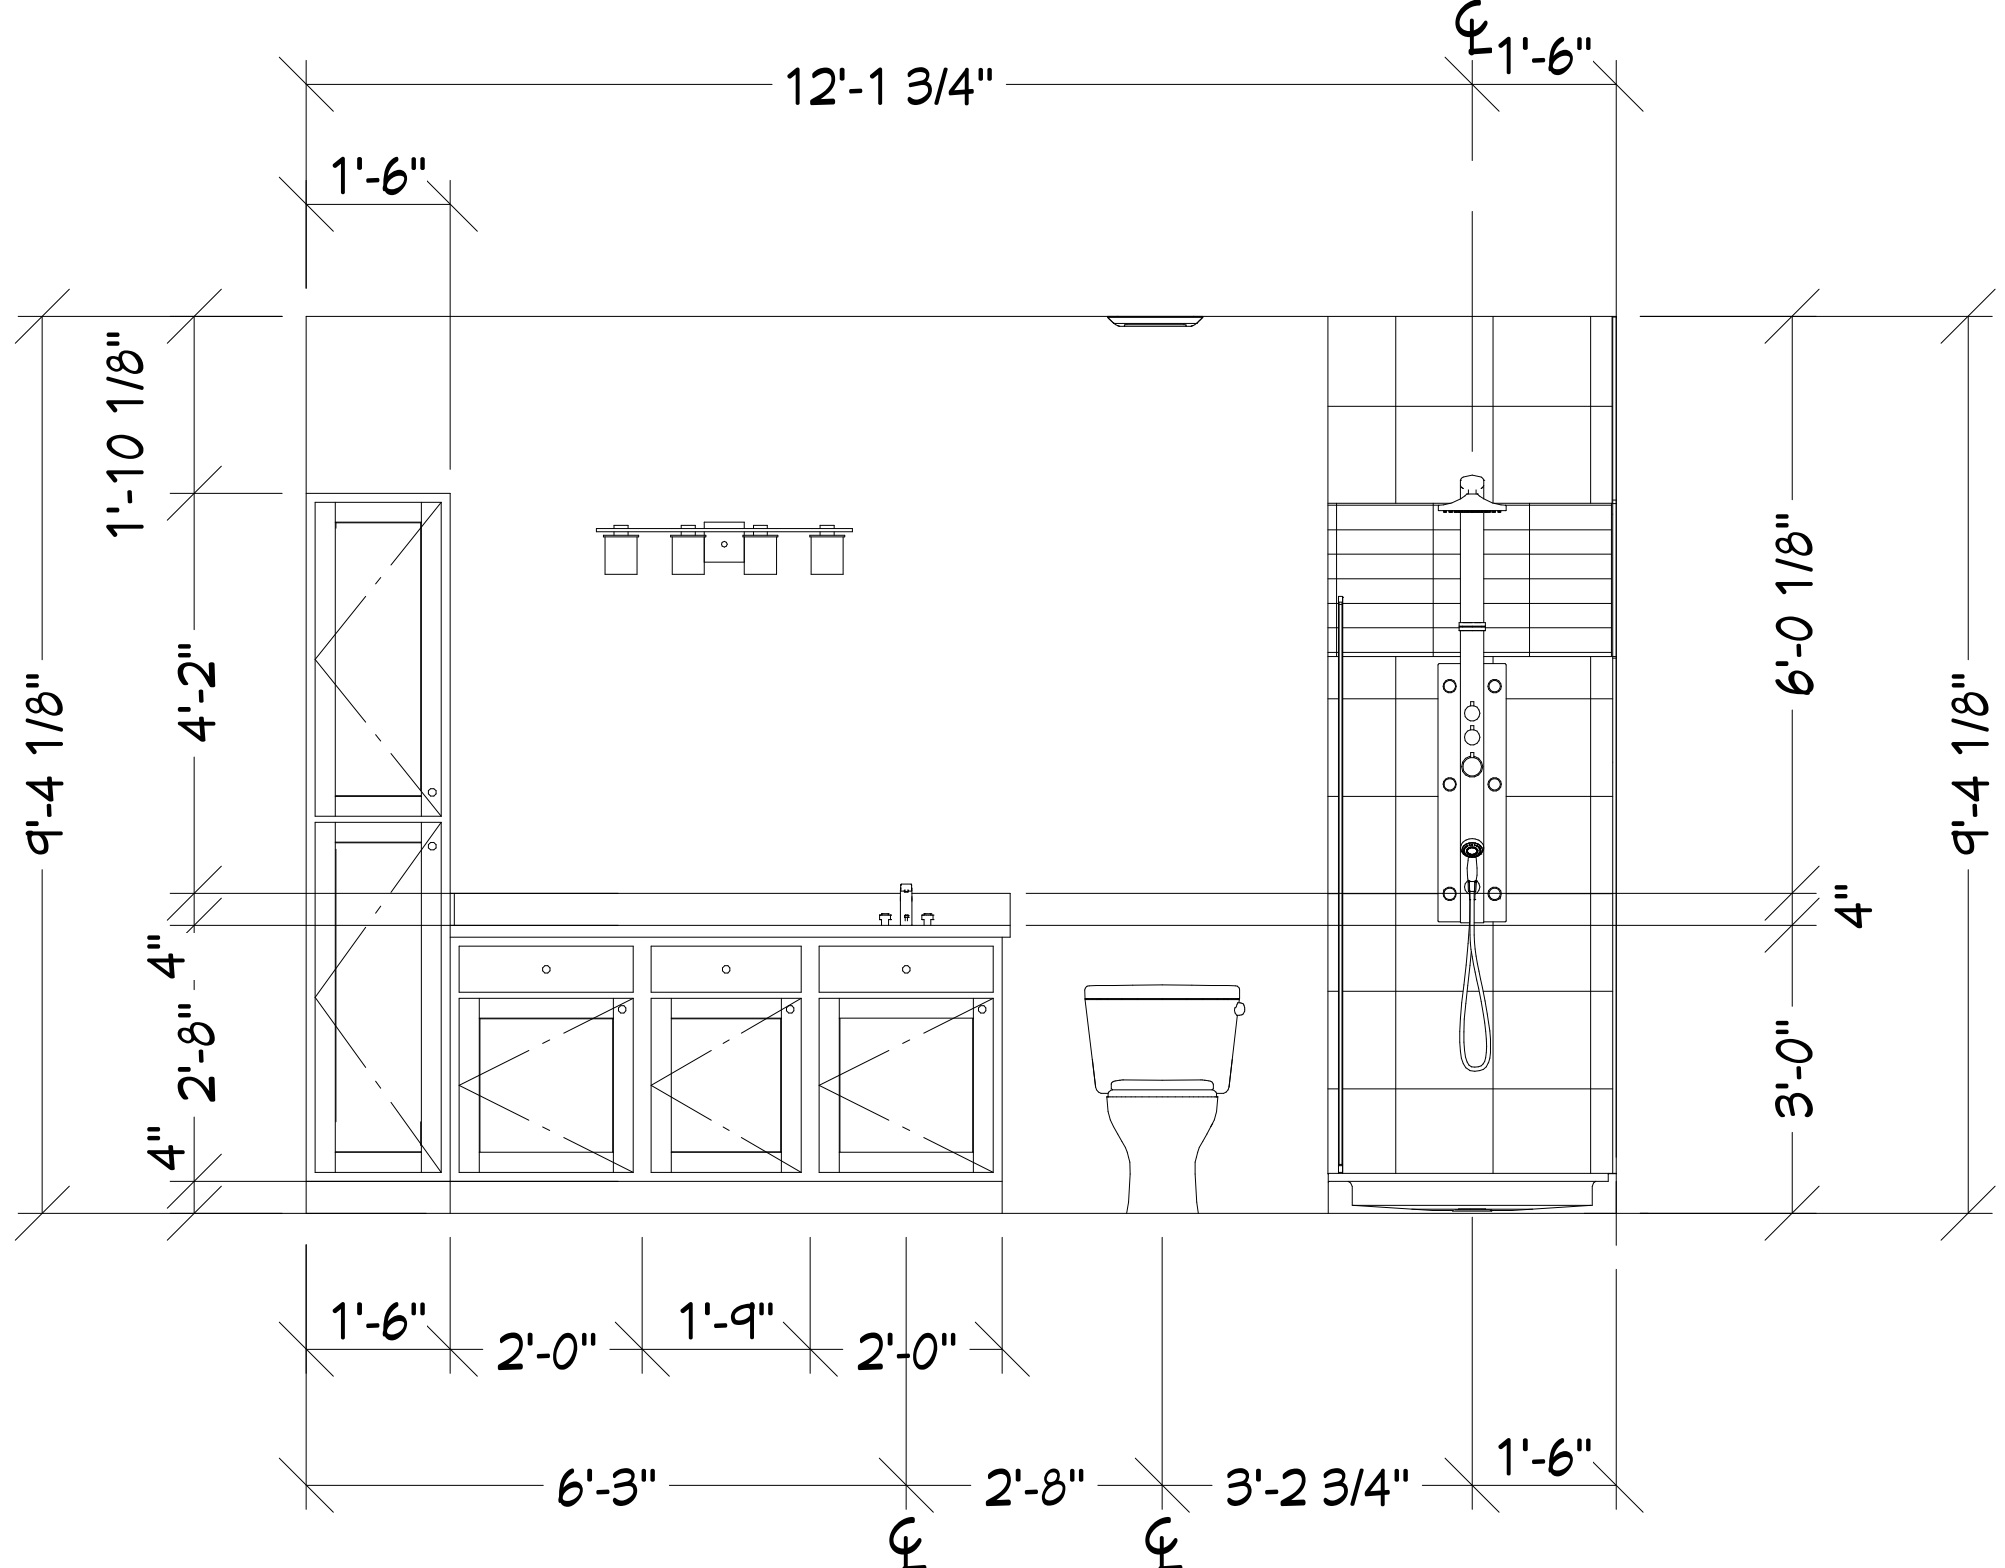

ELEV BB 1/2"=1'

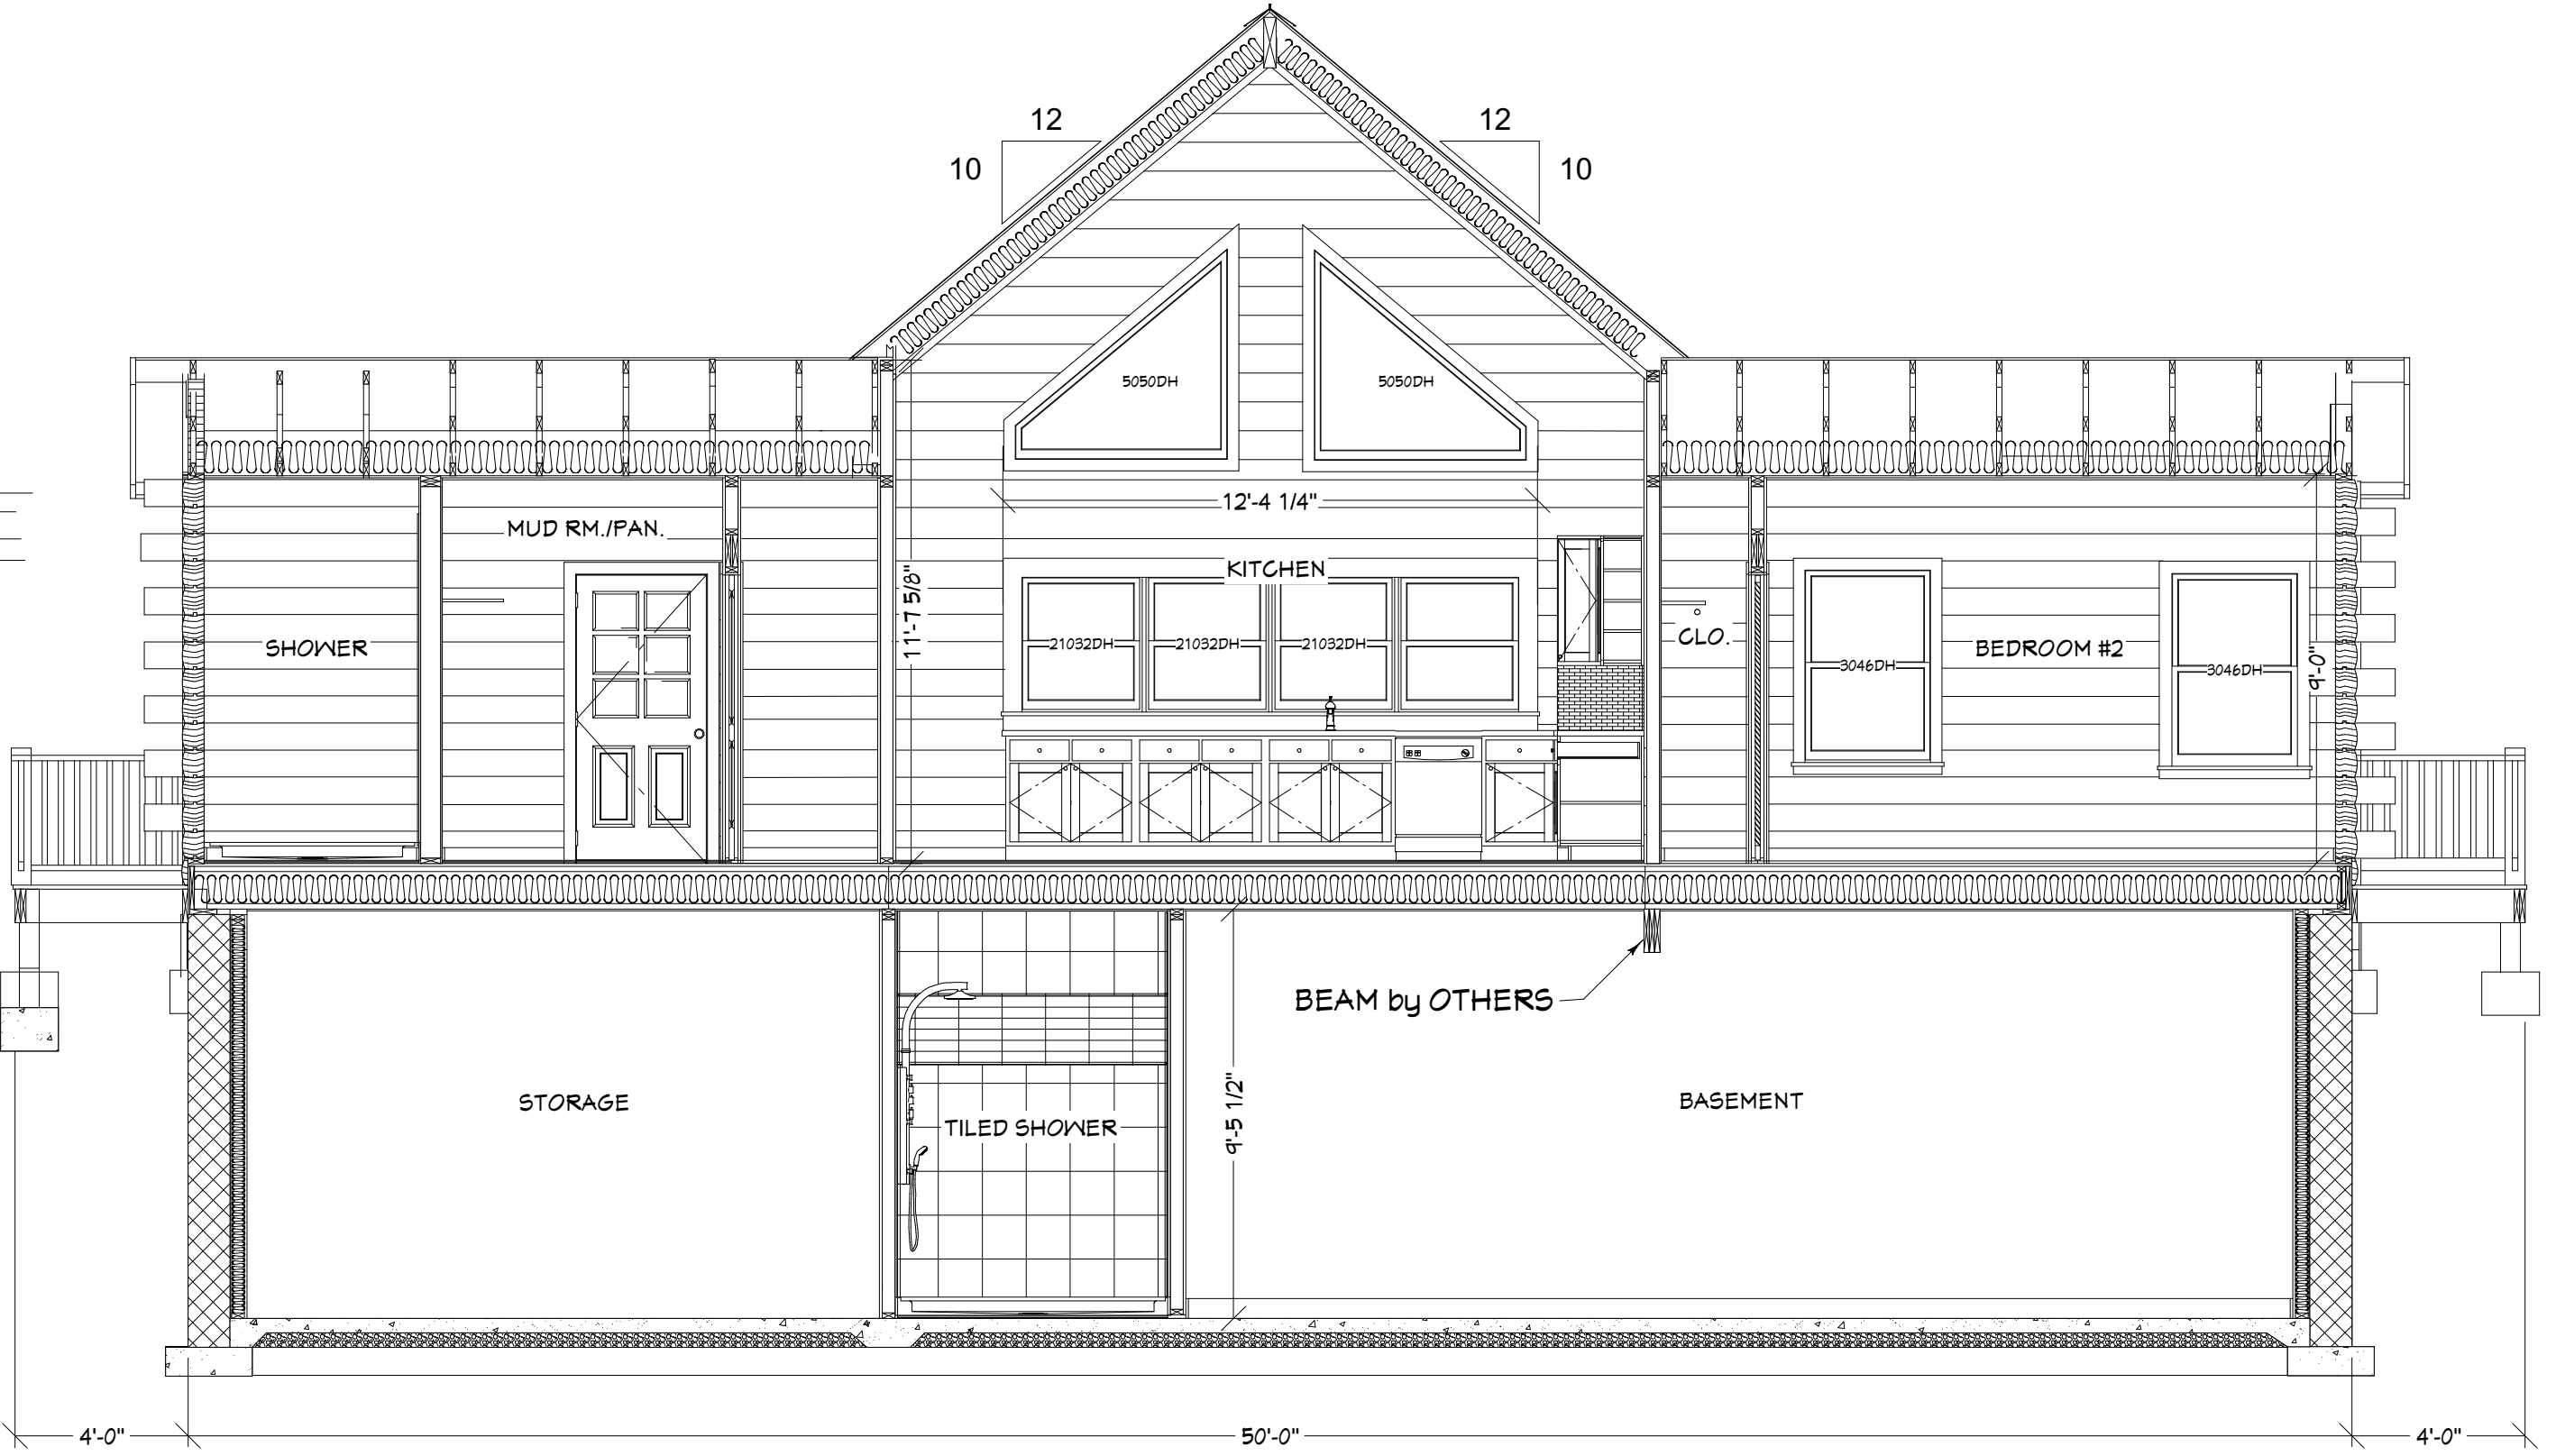

Sec. F SCALE 1/4"=1'